

AREA FOR ARCHITECT/G.C. APPROVAL STAMPS AND COMMENTS

[illegible]

PACKAGE FROM CAP THAT CONTAINED THE FOLLOWING:
 --(1) SET OF KAWNEER (RELEASE TO TAKEOFF) SHOP DRAWINGS DATED 3.31.2006
 --(21) 17" X 11" SHEETS WITH CAP'S SCOPE OF WORK HIGHLIGHTED IN YELLOW
 --CAP QUOTATIONS 5094-REV2 DATED 7.17.06, 5095-REV2 DATED 7.17.06, 5299 DATED 7.12.06 AND 5092-REV2 DATED 7.17.06
 --CAP TRANSMITTAL DATED 7.24.2006 INDICATING ALL PANELS ON THE JOB TO BE 4mm REYNOBOND
 --DRAWING SHEETS (FROM CD-ROM OF .PLT FILES):
 COVER SHEET, A-CVR-1 THROUGH A15-05 ALL DATED 10.06.05 AND MARKED ADDENDUM 2

1. PANEL SYSTEM USED ON THIS PROJECT....
 - COLUMBIA ARCHITECTURAL PRODUCTS, INC. (NOTED ON DRAWINGS AS CAP)
 - 4mm REYNOBOND ALUMINUM COMPOSITE PANELS
2. FINISH OF EXPOSED ALUMINUM:
 - SEE THE PANEL TYPE SCHEDULE BELOW FOR THIS INFORMATION
3. EXCLUSIONS (ITEMS NOT BEING FURNISHED OR INSTALLED BY COLUMBIA ARCHITECTURAL PRODUCTS, INC.)...
 - A. COPING, GRAVEL STOP, FLASHING OR ANY OTHER SHEET METAL WORK.
 - B. UNLOADING AND DISTRIBUTION OF THE PANELS AND PANEL CLIPS.
 - C. FURRING AND FRAMING MEMBERS REQUIRED FOR PANEL SUPPORT.
 - D. FIELD MEASUREMENTS.
 - E. FASTENERS, BACKER ROD AND SEALANT. INSTALLATION OF THESE SAME ITEMS.
 - F. INSTALLATION OF PANELS AND PANEL CLIPS.
 - G. DELIVERY.
 - H. PENETRATIONS FOR OTHER TRADES.

ALL FASTENERS SHOWN ON THIS SHOP DRAWING ARE FOR REFERENCE ONLY. ACTUAL FASTENER TYPES AND SIZES SHOULD BE BASED ON ACTUAL CONDITIONS AND/OR CONSTRUCTION MATERIALS FOUND ON SITE.

ALL PART NUMBERS SHOWN ON THIS SHOP DRAWING SHOULD BE VERIFIED PRIOR TO ORDERING MATERIALS.

ALL DIMENSIONS SHOWN ON THIS SHOP DRAWING SHOULD BE CHECKED/VERIFIED PRIOR TO THE ORDERING OF ANY MATERIALS AND PRIOR TO THE FABRICATION AND INSTALLATION OF ANY MATERIALS.

ALL STEEL CLIP ASS'Y'S AND INTERNAL STEEL REINFORCING SHOWN ON THIS SHOP DRAWING ARE FOR REFERENCE ONLY. ACTUAL STEEL SIZES AND THICKNESSES SHOULD BE DETERMINED BY OTHERS BASED ON THE ARCHITECT'S WINDOWLOAD/DEADLOAD REQUIREMENTS OUTLINED IN THE SPECIFICATIONS.

FABRICATION AND INSTALLATION OF THE FRAMING AND GLASS SHOWN ON THIS SHOP DRAWING SHOULD BE PERFORMED IN ACCORDANCE WITH INDUSTRY STANDARDS AND THE RESPECTIVE MANUFACTURER'S INSTRUCTIONS AND GUIDELINES.


THESE DRAWINGS WERE PREPARED WITHOUT THE BENEFIT OF A FULL SET OF ARCHITECTURAL DRAWINGS. SOME PERIMETER CONDITIONS MAY BE SHOWN AS UNKNOWN. THESE CONDITIONS SHOULD BE VERIFIED PRIOR TO FABRICATION AND INSTALLATION FOR THEIR EFFECT ON THE WORK BEING PERFORMED.

THESE DRAWINGS WERE PREPARED WITHOUT THE BENEFIT OF STRUCTURAL DRAWINGS. THIS MAY AFFECT THE LOCATION AND SIZING OF STEEL CLIP CONNECTIONS AND SPLICE JOINTS. THE STRUCTURAL ANALYSIS IN THESE AREAS SHOULD BE VERIFIED PRIOR TO FABRICATION AND INSTALLATION OF THE WORK.







SHOP DRAWING DISCLAIMER: THIS DISCLAIMER APPLIES TO ACCURATE DRAFTING'S CUSTOMER AS WELL AS ANY PARTY USING THESE DRAWINGS TO OBTAIN INFORMATION NEEDED TO ORDER, COORDINATE, FABRICATE AND INSTALL MATERIALS FOR THIS PROJECT. THIS APPLIES ALSO TO TRADES OTHER THAN GLASS AND GLAZING. THIS SHOP DRAWING IS AN INTERPRETATION OF THE ARCHITECT'S DRAWINGS BY ACCURATE DRAFTING COMPANY. THIS DRAWING WAS GENERATED FOR ACCURATE DRAFTING'S CUSTOMER. THE INTERPRETATION OF THE ARCHITECT'S DRAWINGS IS AFFECTED BY THE INFORMATION GIVEN TO ACCURATE BY IT'S CUSTOMER AS WELL AS INDUSTRY STANDARDS AND MANUFACTURER TECHNICAL INFORMATION. IN CASES WHERE ACCURATE IS NOT PROVIDED WITH THE NECESSARY INFORMATION IT WILL BE ACCURATE'S DECISION WHETHER TO ASSUME, EXTRAPOLATE OR OMIT THIS INFORMATION IN ORDER TO COMPLETE THE SHOP DRAWINGS. IT IS THE RESPONSIBILITY OF ACCURATE'S CUSTOMER (OR THE END USER IF APPLICABLE) TO REVIEW THE SHOP DRAWINGS. REVIEW OF THE SHOP DRAWINGS INCLUDES, BUT IS NOT LIMITED, TO THE FOLLOWING ITEMS: DIMENSIONS, QUANTITIES, HANDING OF DOORS/FRAME/ COLORS, THICKNESSES, SAFETY GLASS, GLASS TYPES, COATING TYPES, COATING LOCATIONS, DOOR STYLE TYPES, FRAMING TYPES, HARDWARE, ALIGNMENT OF HORIZONTAL AND/OR VERTICAL FRAMING MEMBERS WITH ARCHITECTURAL ACCENTS/TRIM. ACCURATE DRAFTING NOR IT'S DRAFTSMAN SHALL BE LIABLE OR RESPONSIBLE FINANCIALLY FOR ANY ERRORS AND/OR OMISSIONS FROM THESE SHOP DRAWINGS. ARCHITECTURAL AND/OR CONTRACTOR APPROVAL DOES NOT RELIEVE ACCURATE'S CUSTOMER FROM REVIEWING THESE DRAWINGS AS NOTED ABOVE.

NOTE: IN CASES WHERE NO ARCHITECTURAL DRAWINGS WERE PROVIDED TO ACCURATE THE SAME DISCLAIMER ITEMS NOTED ABOVE STILL APPLY TO WHATEVER INFORMATION WAS PROVIDED TO ACCURATE TO PERFORM THE SHOP DRAWINGS.

R.O. - ROOF OPENING.	SYMBOLS USED ON ELEVATIONS FOR SPECIAL ANCHOR CONDITIONS.....
F.S. - FRAME SIZE.	WINDLOAD CLIP ASS'Y
D.L.O. - DAYLITE OPENING.	DEADLOAD CLIP ASS'Y
D.O. - DOOR OPENING.	WINDLOAD DEADLOAD CLIP ASS'Y
R.D.O. - REQUIRED.	
OPP. - OPPOSITE.	SPLICE JOINT
R.H. - RIGHT HAND.	
L.H. - LEFT HAND.	
S.L. - SINGLE ACTING.	
D.A. - DOUBLE ACTING.	
STL. - STEEL.	
ALUM. - ALUMINUM.	
B.O. - BY OTHERS.	
F.V. - FIELD OF VIEW.	
ANG. - ANGLE.	
CHAN. - CHANNEL.	
SHT. - SHEET.	
DTG. - DETAIL.	
ELEV. - ELEVATION.	
IG. - INSULATED GLASS.	INDICATES THE LOCATION AND FASTENER TYPE DESIGNATION (REFER TO THE FASTENER SCHEDULE ON SHEET #1 IF AVAILABLE)
O.B. - OUTBOARD.	
LB. - INBOARD.	
AS. - AIR SPACE.	
SURF. - SURFACE.	
FLSHG. - FLASHING.	
WDWG. - WINDOW.	
P.O. - PROJECT.	
P.I. - PROJECT IN.	
HDWE. - HARDWARE.	
EA. - EACH.	
FLR. - FLOOR.	
EXT. - EXTERIOR.	
INT. - INTERIOR.	
EM. - EMBEDED.	
SPAND. - SPANDELR.	
INSUL. - INSULATION.	
A.F.F. - ABOVE FINISHED FLOOR.	
ID. - INSIDE DIMENSION.	
O.D. - OUTSIDE DIMENSION.	
DTG. - DETAIL.	
JE. - JOINT.	
B.J. - BUTT JOINT.	
CL. - CENTERLINE.	
T.O. - TOP OF HORIZONTAL.	
B.O.B. - BOTTOM OF HORIZONTAL.	
F.B. - FACE OF BRICK.	
F.O.S. - FACE OF STOREFRONT.	
N.A. - ANSWER NEEDED FROM ARCHITECT, OR GENERAL CONTRACTOR.	
G.C. - GENERAL CONTRACTOR.	
ARCH. - ARCHITECT.	
N.T.S. - NOT TO SCALE.	CLOUD INDICATES AREA OF REVISION AND TRIANGLE WITH NUMBER INDICATES REVISION NUMBER
SM. - SIMILAR.	
VER. - VERIFY.	
AND. - ANODIZED.	
PTD. - PAINTED.	
S.S. - STAINLESS STEEL.	
P.H. - PINTLE HOLE.	

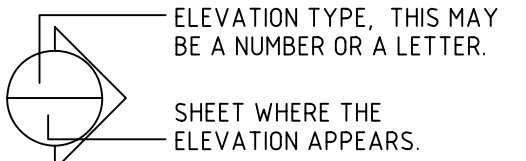

 CONFIGURATION OF A TYPICAL INSULATED GLASS UNIT (I.G.)

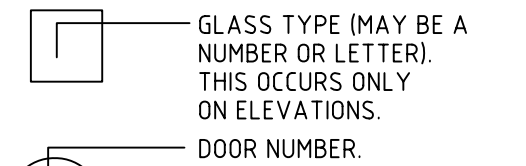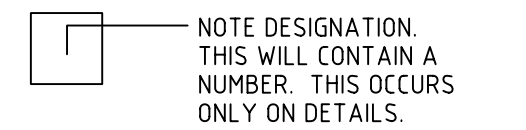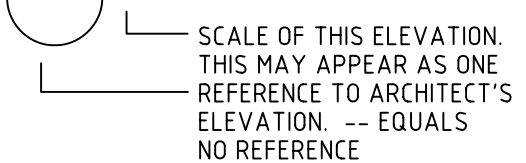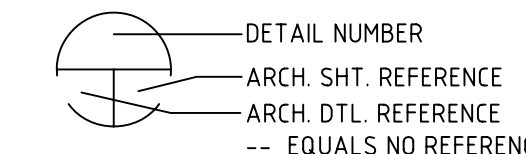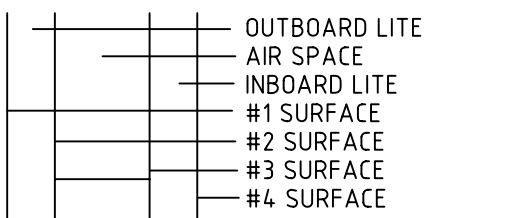

OPUS CENTER @
ROCKSPRING
PARK, BETHESDA
MARYLAND

SHEET #:

1

FABRICATION RELEASE:
THE PANEL DIMENSIONS HAVE BEEN REVIEWED AND
APPROVED AS NOTED ON THIS DRAWING. THE
PANELS ARE HEREBY RELEASED FOR FABRICATION

ARCHITECT'S GLASS REFERENCES

NONE P1 4mm (.157") REYNOBOND ARCHITECTURAL
PANEL CONSISTING OF...

.020" ALUMINUM FACE SHEET
POLYETHYLENE CORE
.020" ALUMINUM BACK SHEET

PANEL FINISH:
(OF FACE SHEET ONLY)
KYNAR PAINTED FINISH
COLOR: "BRIGHT SILVER METALLIC"

NOTE: THE BACK SHEET WILL BE PRIMED AND PAINTED (NOT THE SAME FINISH AS THE FACE SHEET)

REVISION #	DATE	BY

REVISIONS

DRAWINGS PREPARED FOR.....

10722 TUCKER STREET
BELTSVILLE, MARYLAND 20705
PHONE: 410.792.2059 (MARYLAND)
PHONE: 301.937.4383 (WASHINGTON D.C.)
FAX: 301.937.6850


DRAWN BY: WOOD DATE: 8.28.2006
E-MAIL: adisales@accuratedrafting.com

SCALES:
 (UNLESS NOTED OTHERWISE AT THE
 INDIVIDUAL DRAWINGS)
 ELEVATIONS: 1/4" = 1'-0"
 DETAILS: 1/2 SIZE (1/2" = 1")


DRAWINGS PREPARED BY.....

8126 Foxdale Drive, Norfolk, Virginia 23518
Phone #: (757) 587-1898 Fax #: (757) 587-1897
Website: www.accuratedrafting.com Email: adisales@accuratedrafting.com


OPUS CENTER @ ROCKSPRING PARK
PARTIAL KEY PLAN
GROUND FLOOR
NOT TO SCALE

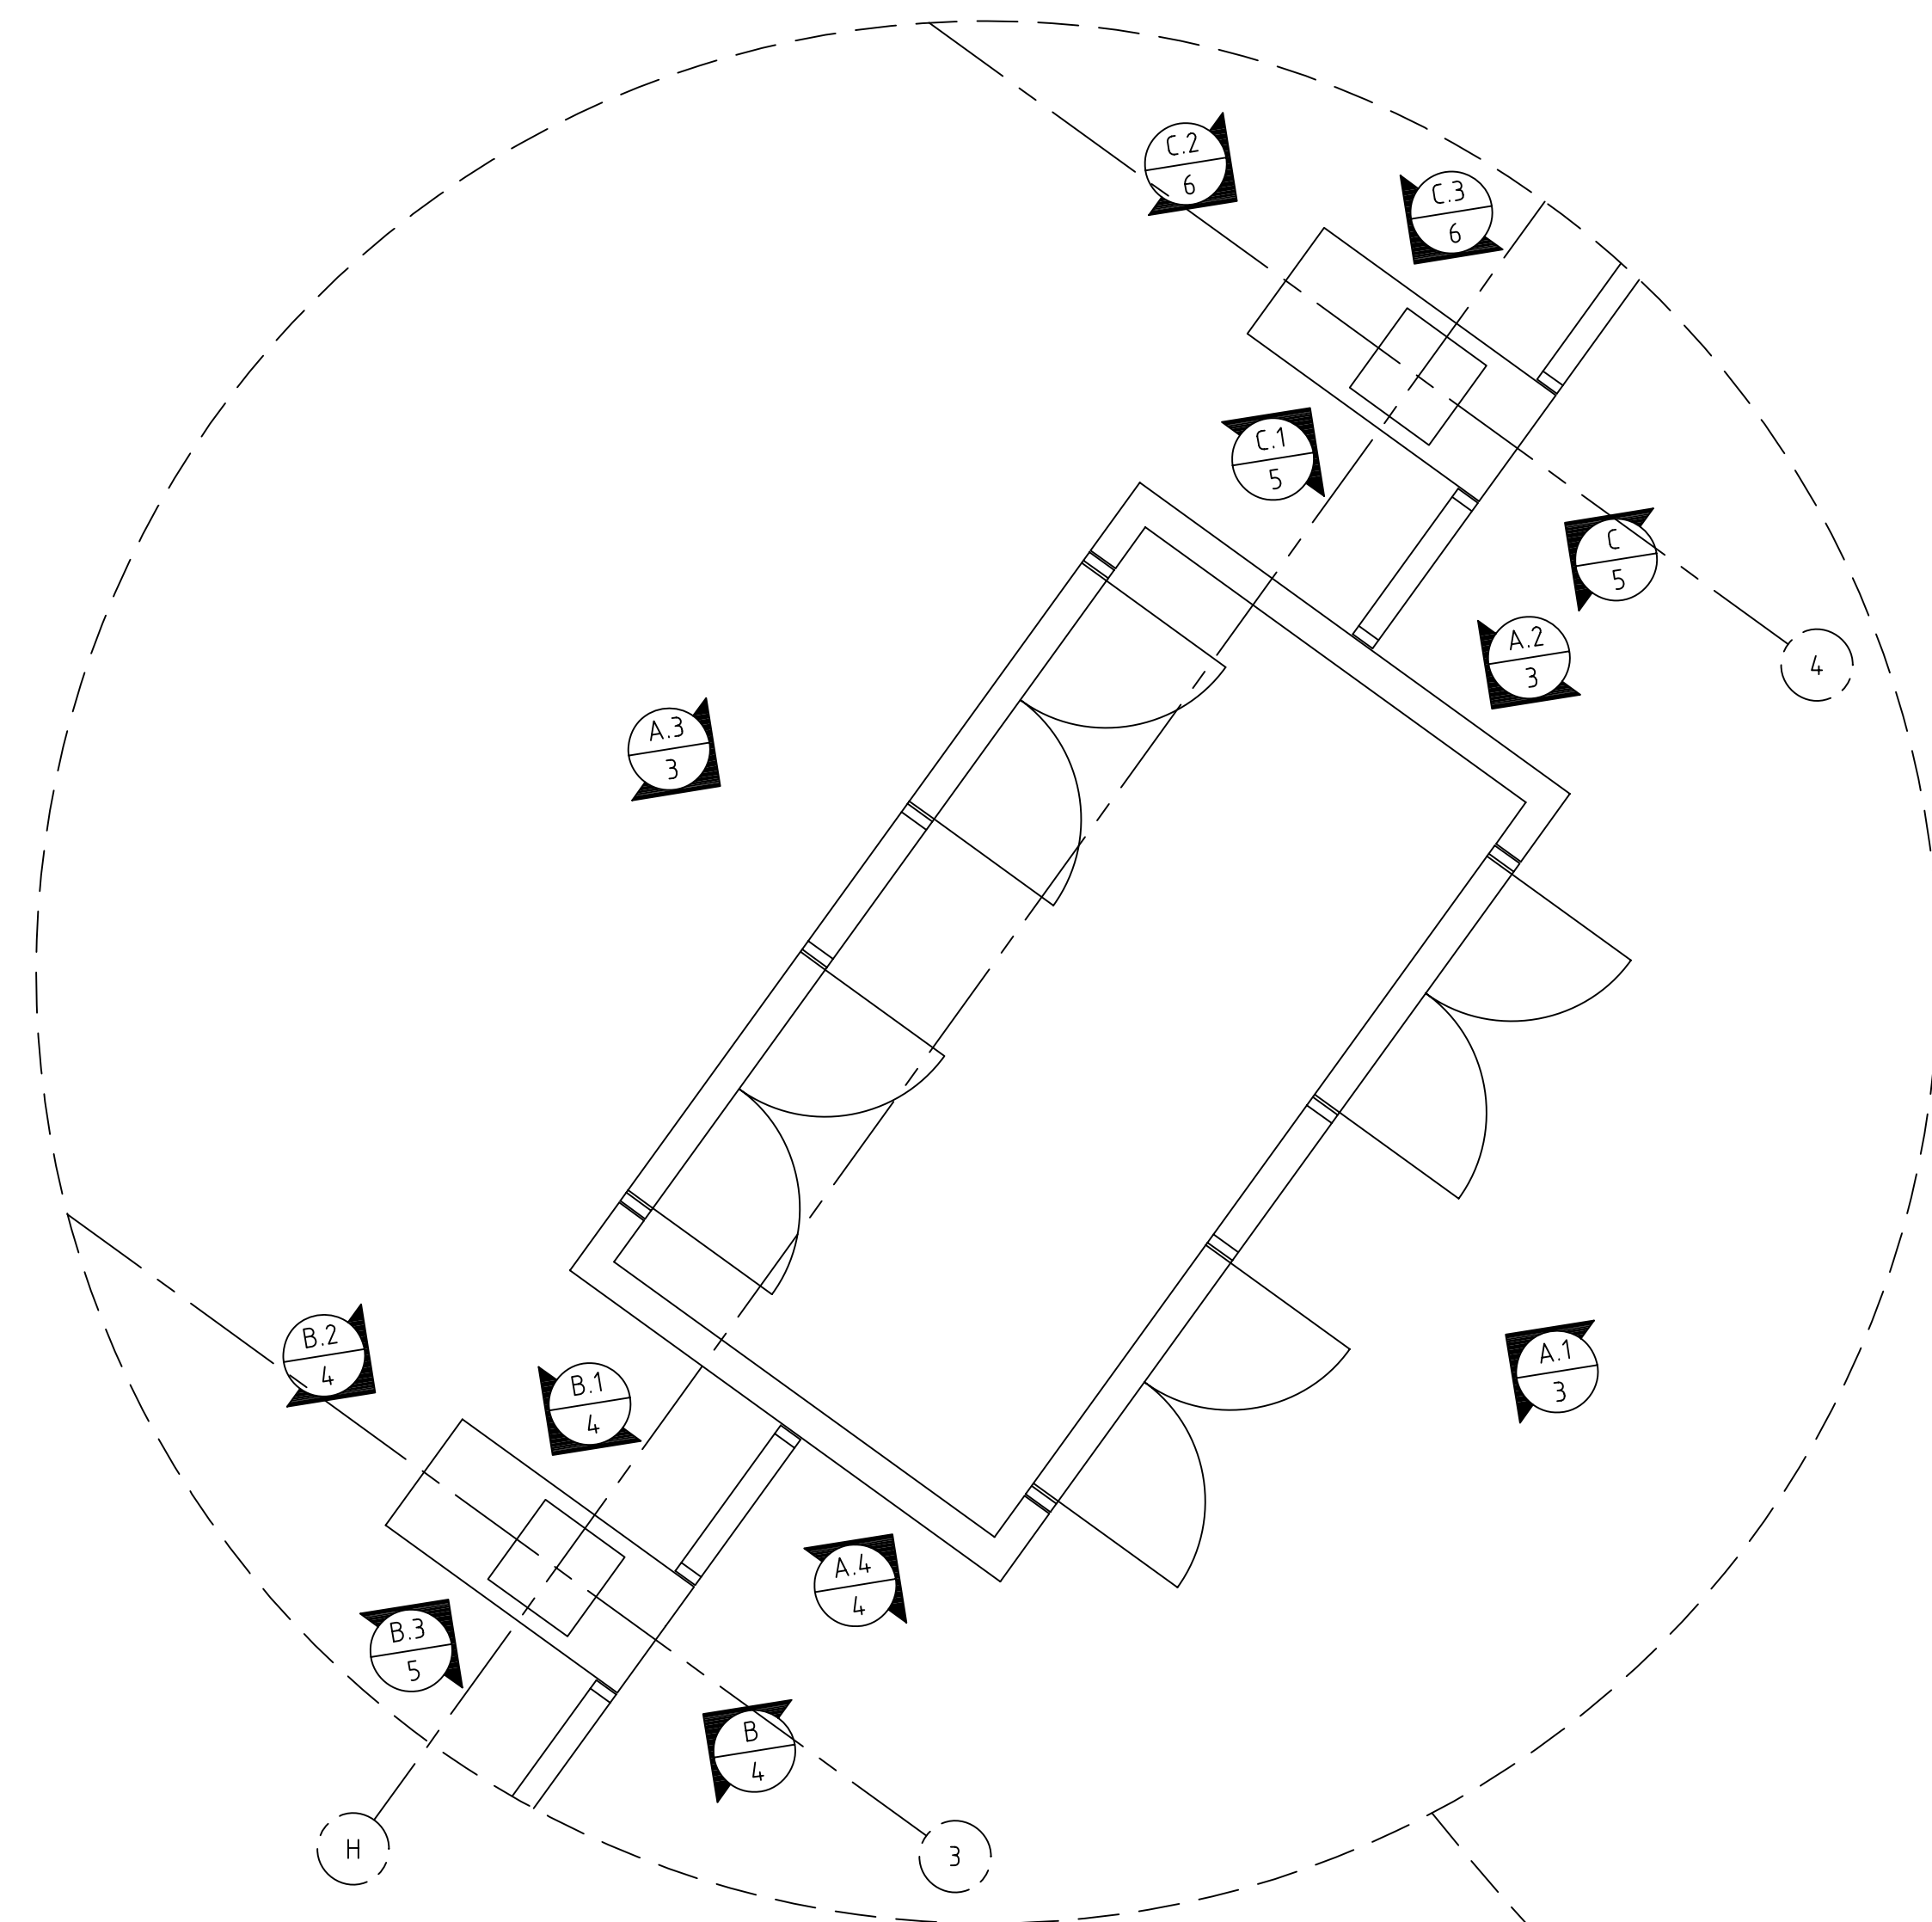

OPUS CENTER @ ROCKSPRING PARK
PARTIAL KEY PLAN
SECOND FLOOR
NOT TO SCALE

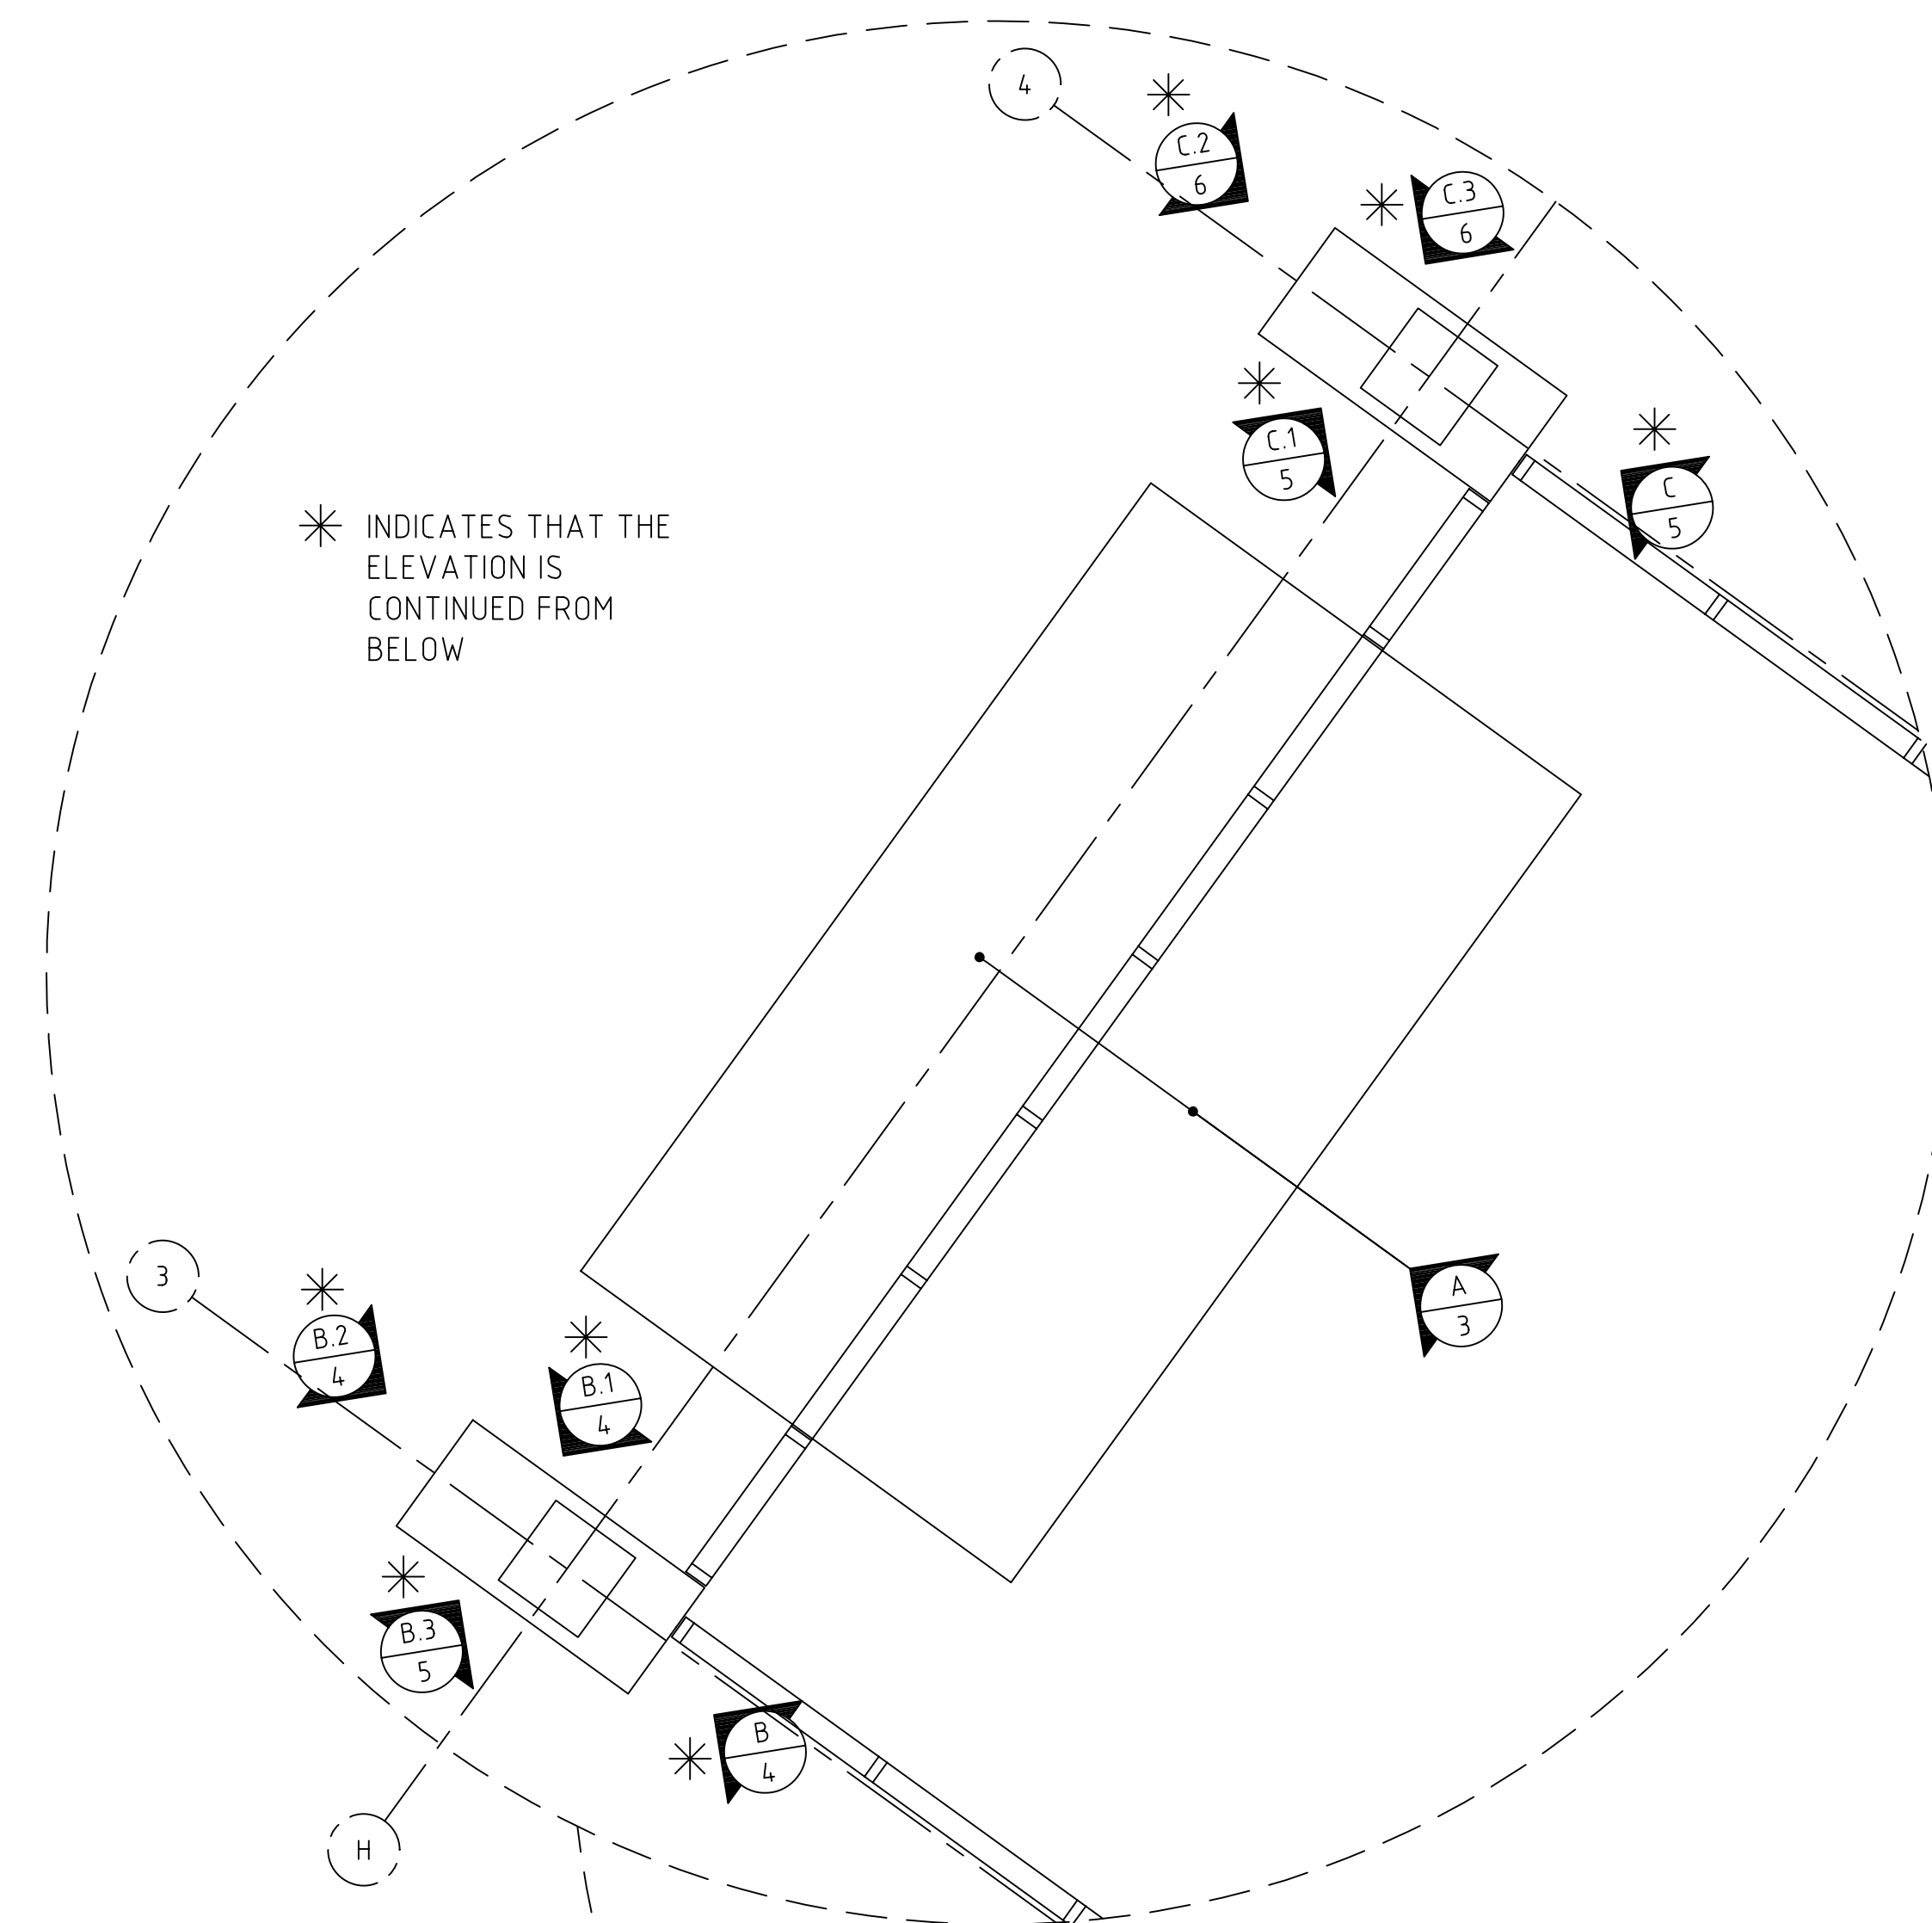


* INDICATES THAT THE
ELEVATION IS
CONTINUED FROM
BELOW

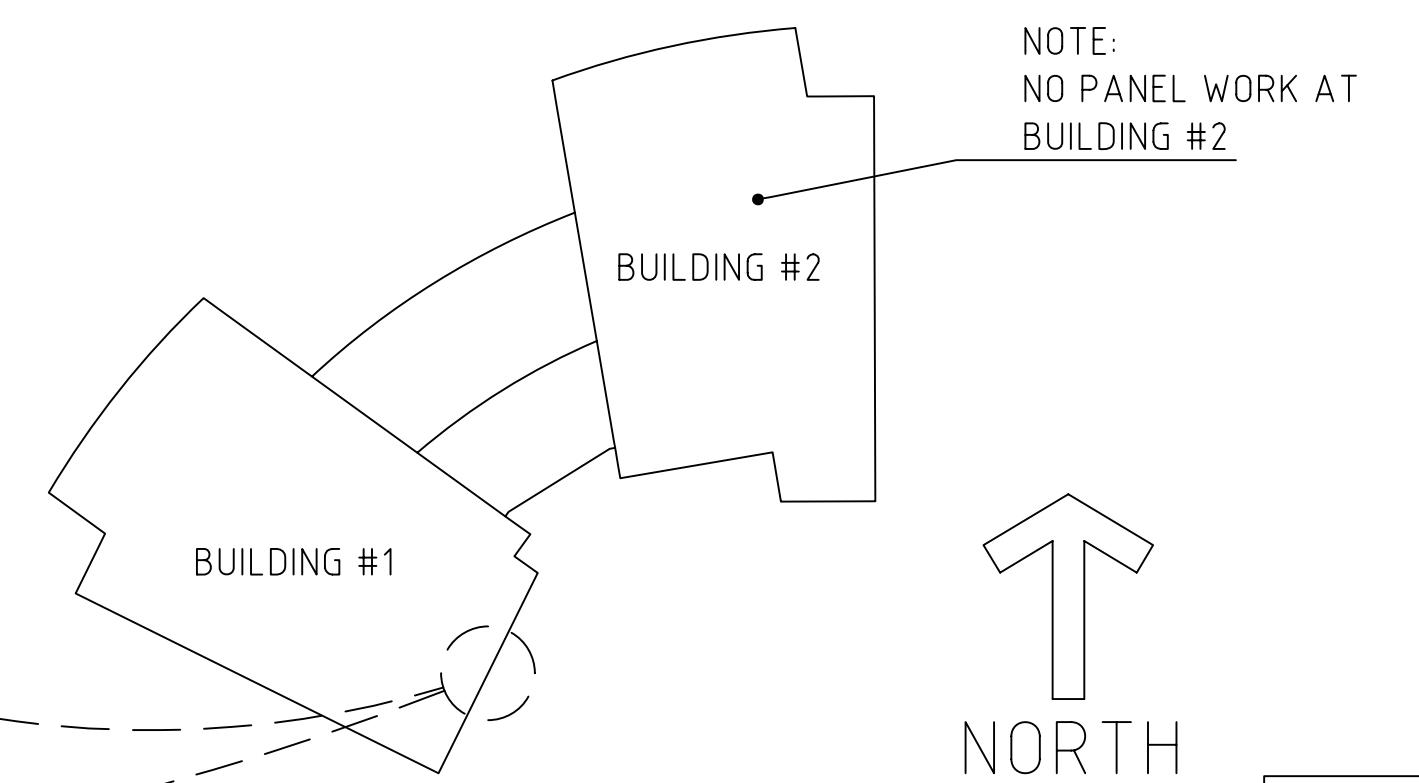

FABRICATION RELEASE:
THE PANEL DIMENSIONS HAVE BEEN REVIEWED AND
APPROVED AS NOTED ON THIS DRAWING. THE
PANELS ARE HEREBY RELEASED FOR FABRICATION.

OPUS CENTER @ ROCKSPRING
PARK
OVERALL BUILDING PLAN
NOT TO SCALE


OPUS CENTER @ ROCKSPRING PARK
PARTIAL KEY PLAN
GROUND, 2ND, 3RD, 4TH, 5TH, 6TH, 7TH
AND 8TH FLOORS
NOT TO SCALE

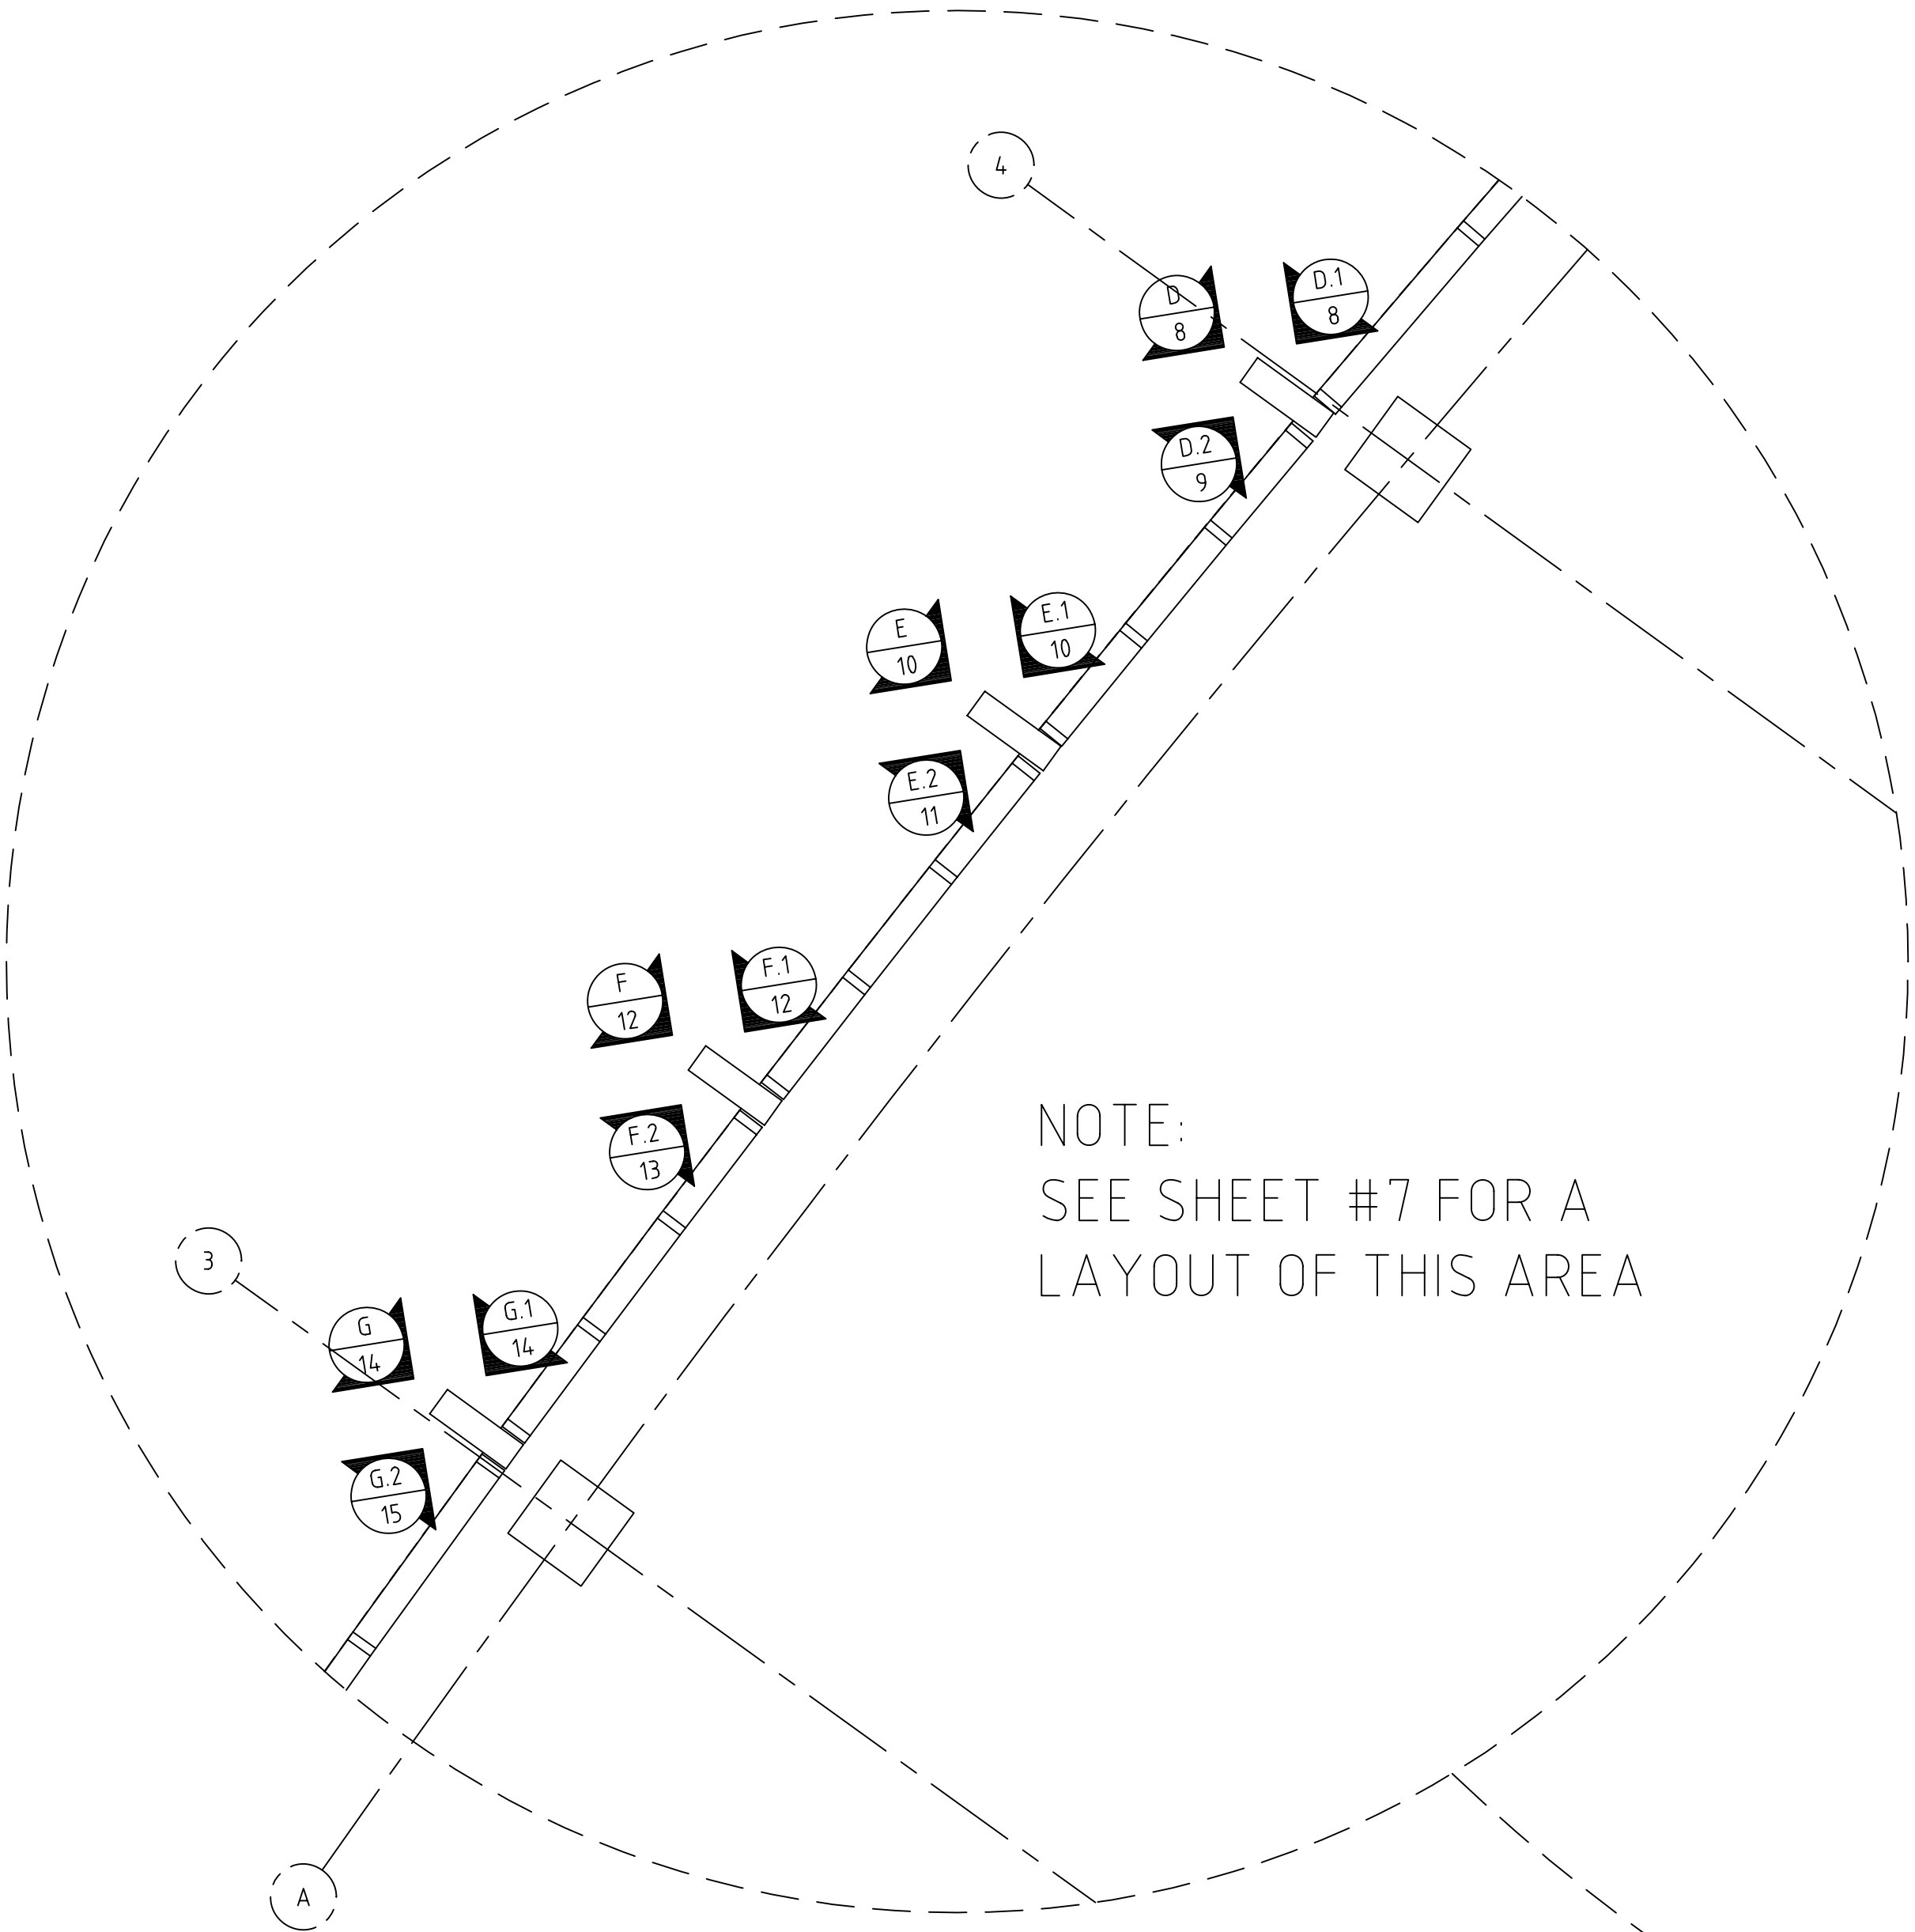

NOTE:
SEE SHEET #7 FOR A
LAYOUT OF THIS AREA


FABRICATION RELEASE:
THE PANEL DIMENSIONS HAVE BEEN REVIEWED AND
APPROVED AS NOTED ON THIS DRAWING. THE
PANELS ARE HEREBY RELEASED FOR FABRICATION.

* INDICATES THAT THE
ELEVATION IS
CONTINUED FROM
BELOW

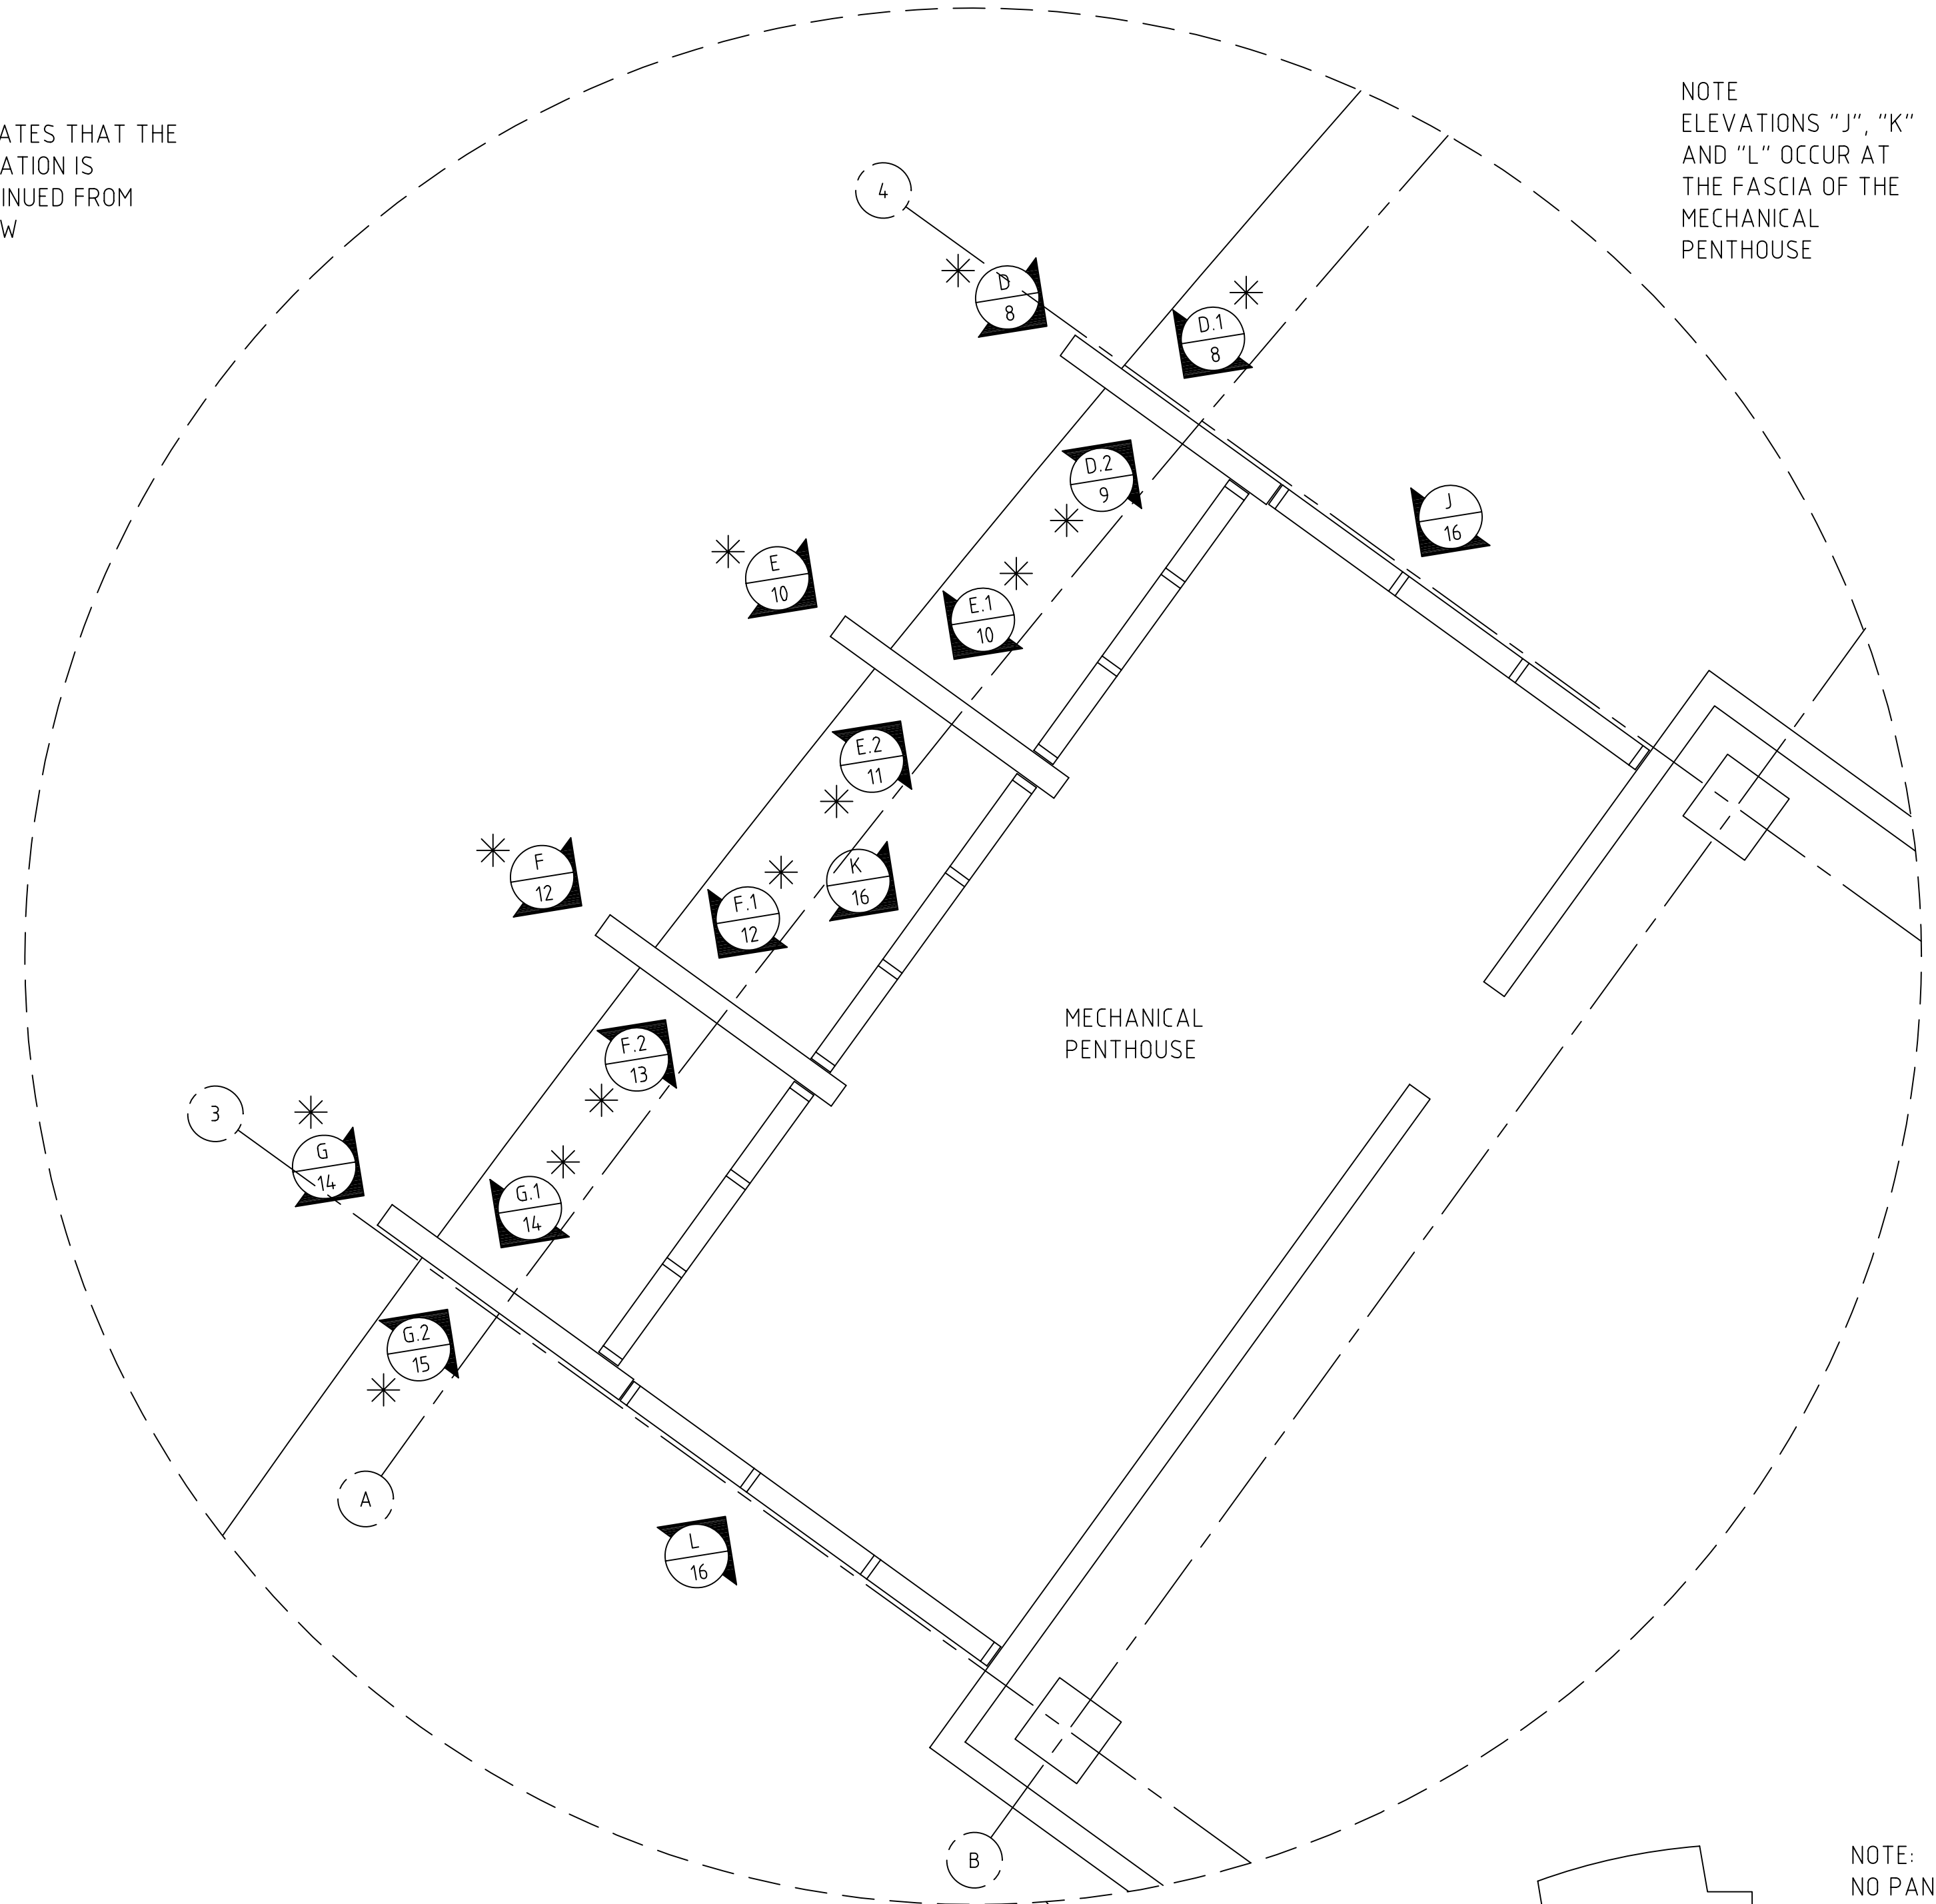





NOTE
ELEVATIONS "J", "K"
AND "L" OCCUR AT
THE FASCIA OF THE
MECHANICAL
PENTHOUSE

OPUS CENTER @ ROCKSPRING PARK
PARTIAL KEY PLAN
ROOF LEVEL
NOT TO SCALE

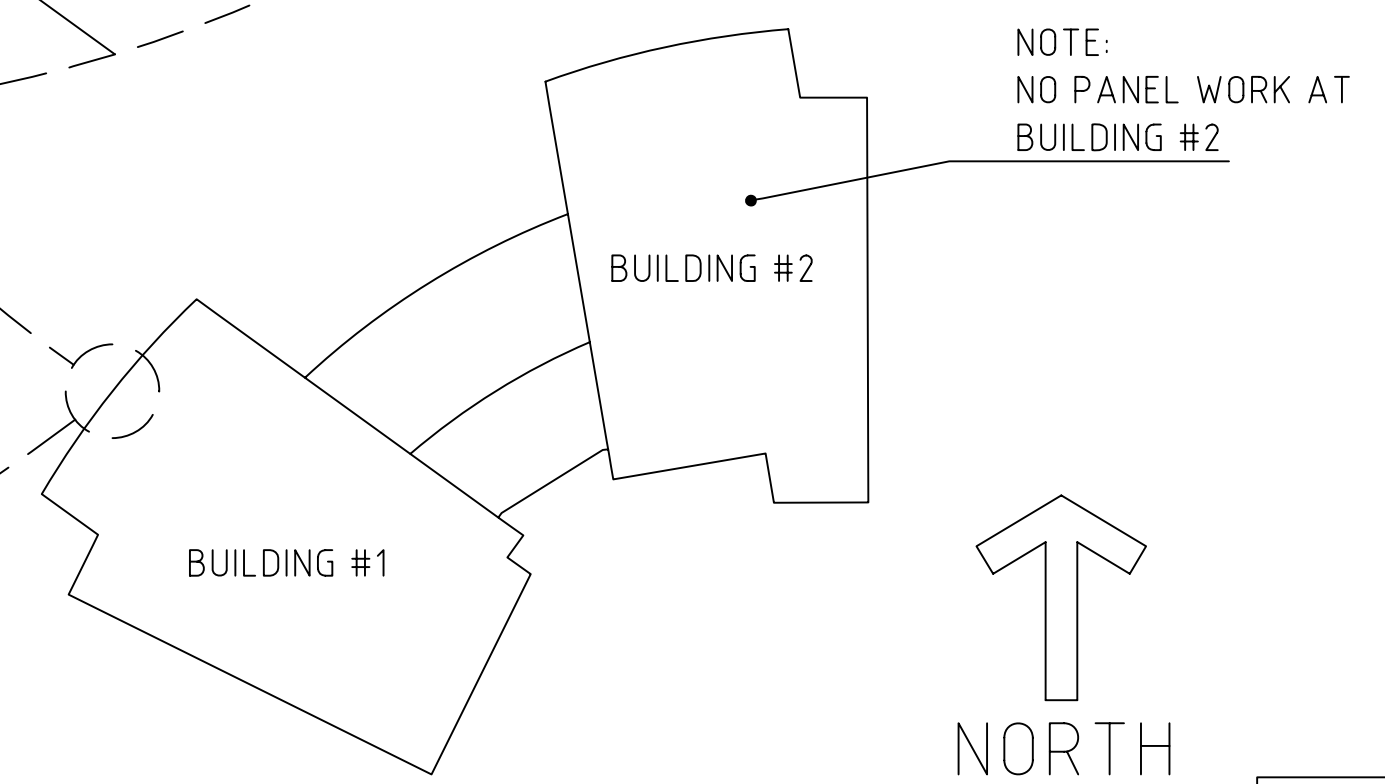




NOTE:
NO PANEL WORK AT
BUILDING #2

OPUS CENTER @ ROCKSPRING
PARK
OVERALL BUILDING PLAN
NOT TO SCALE

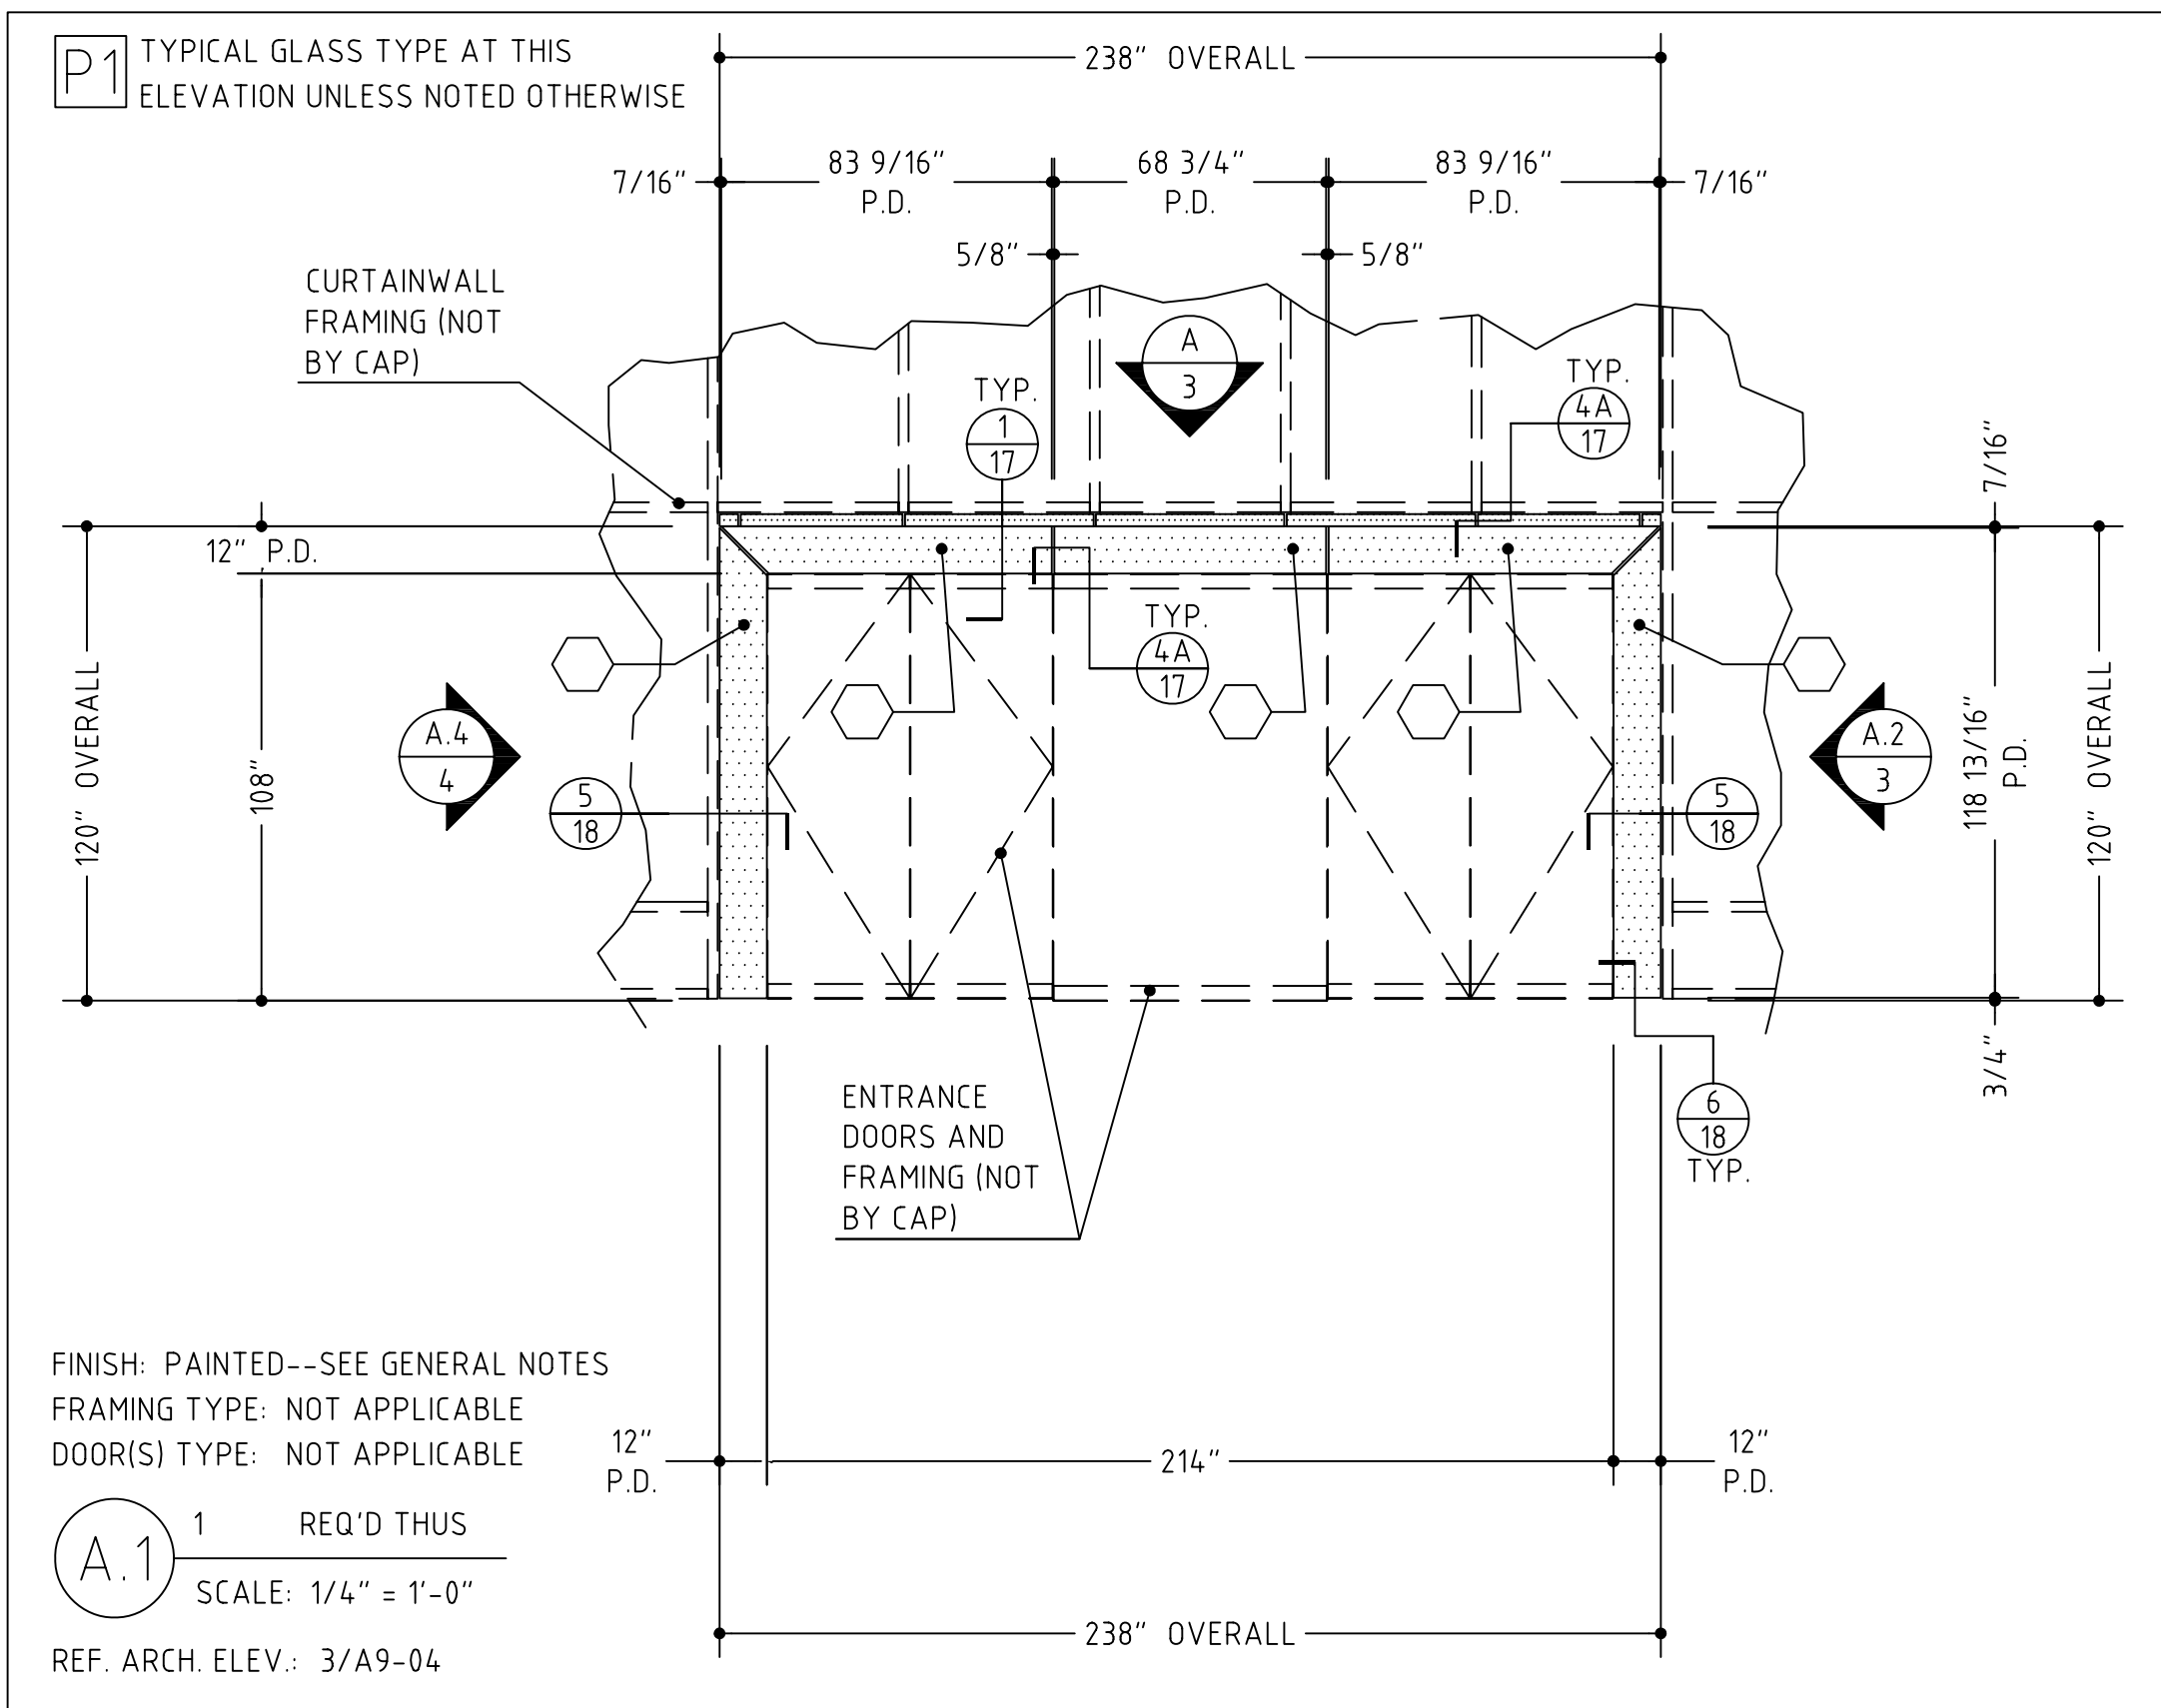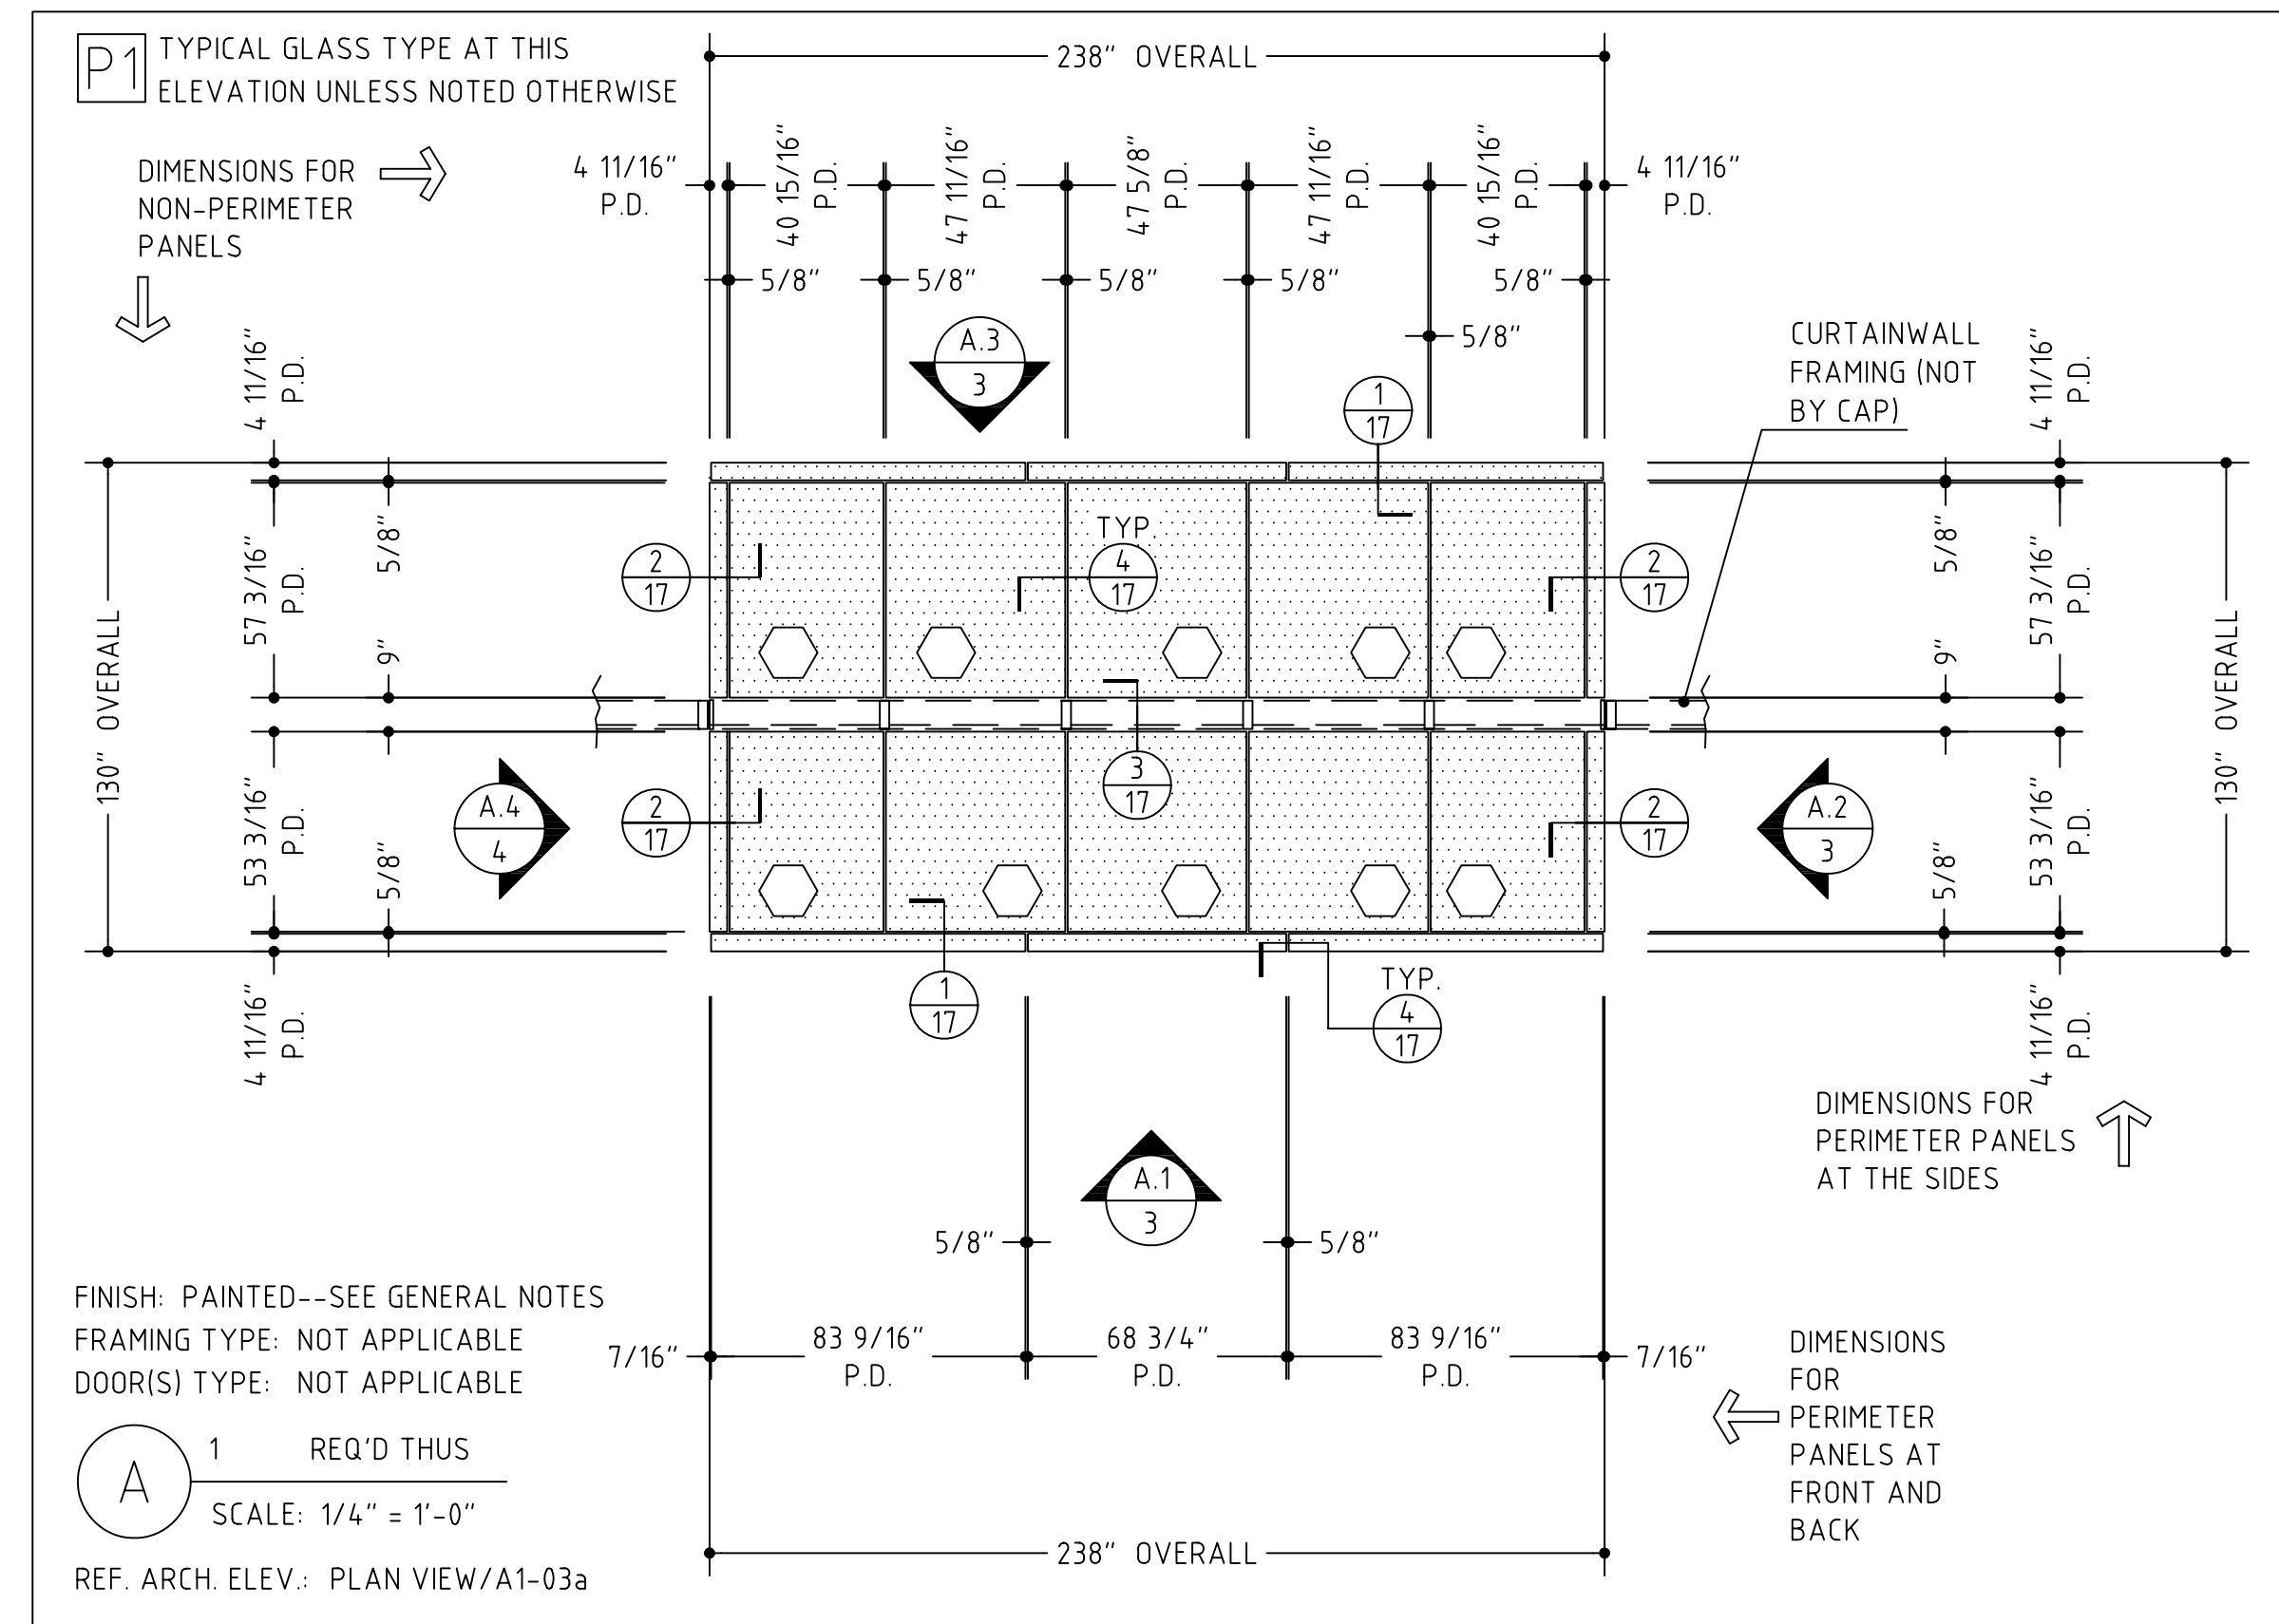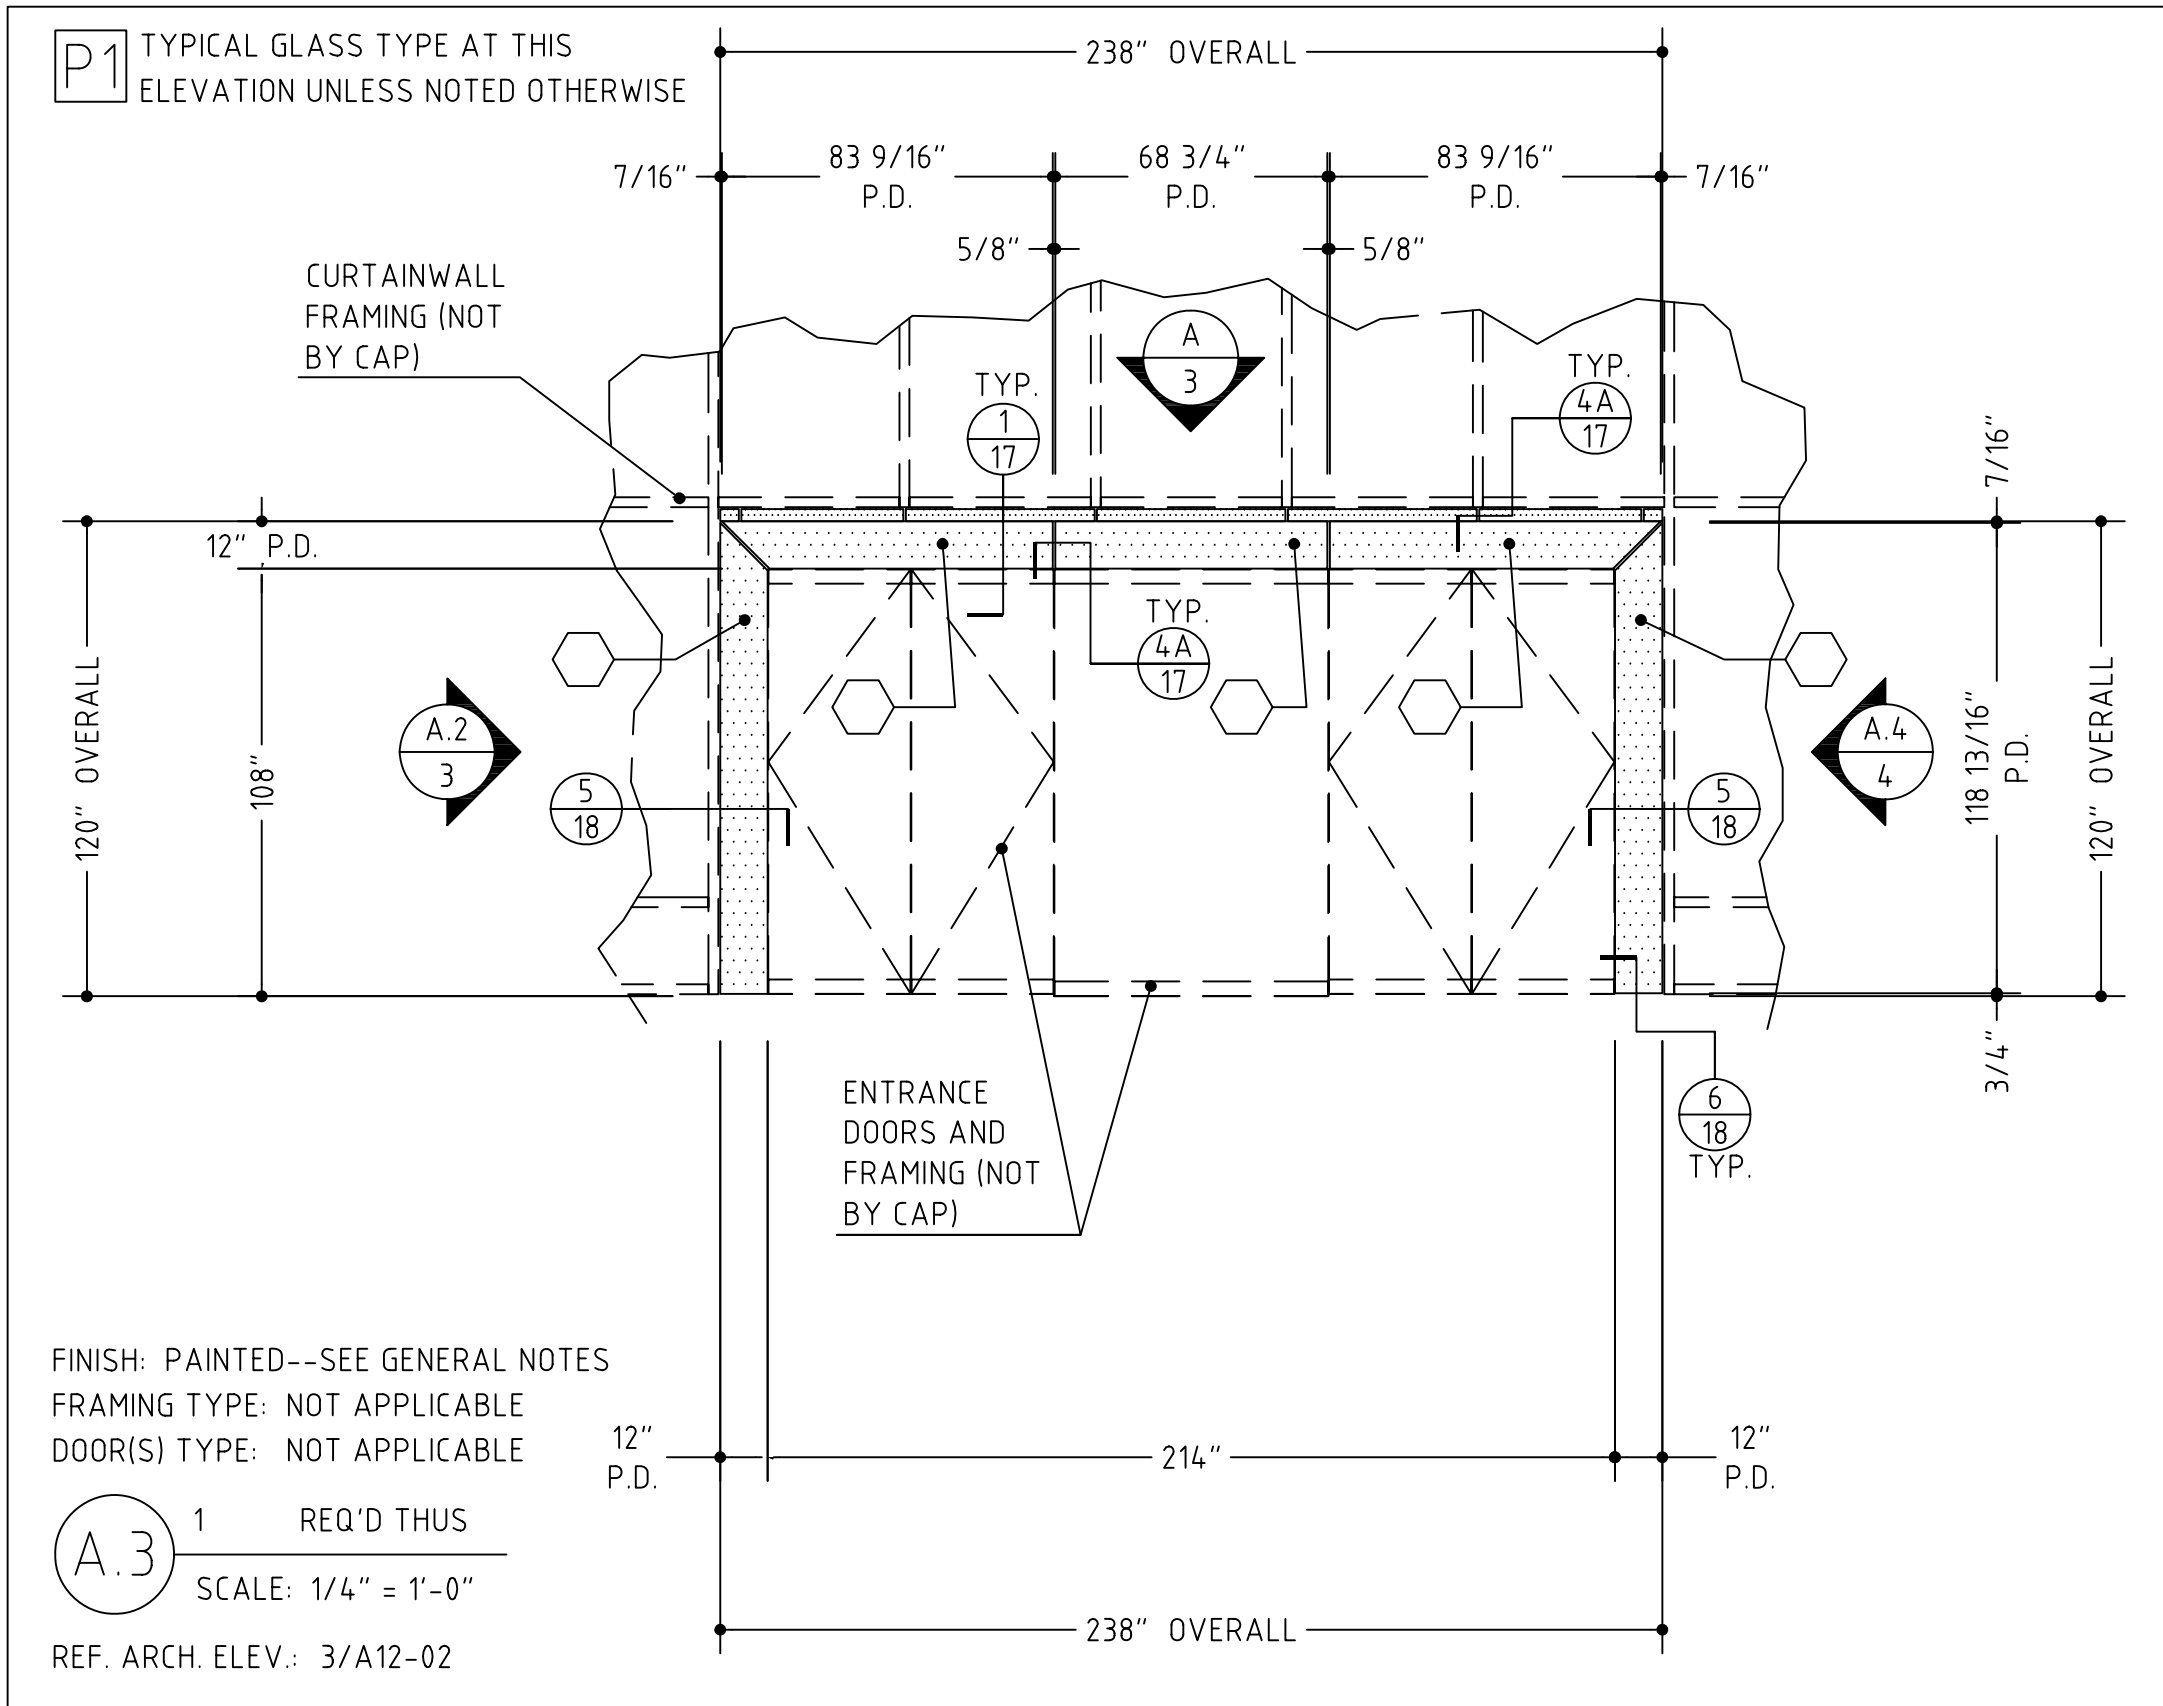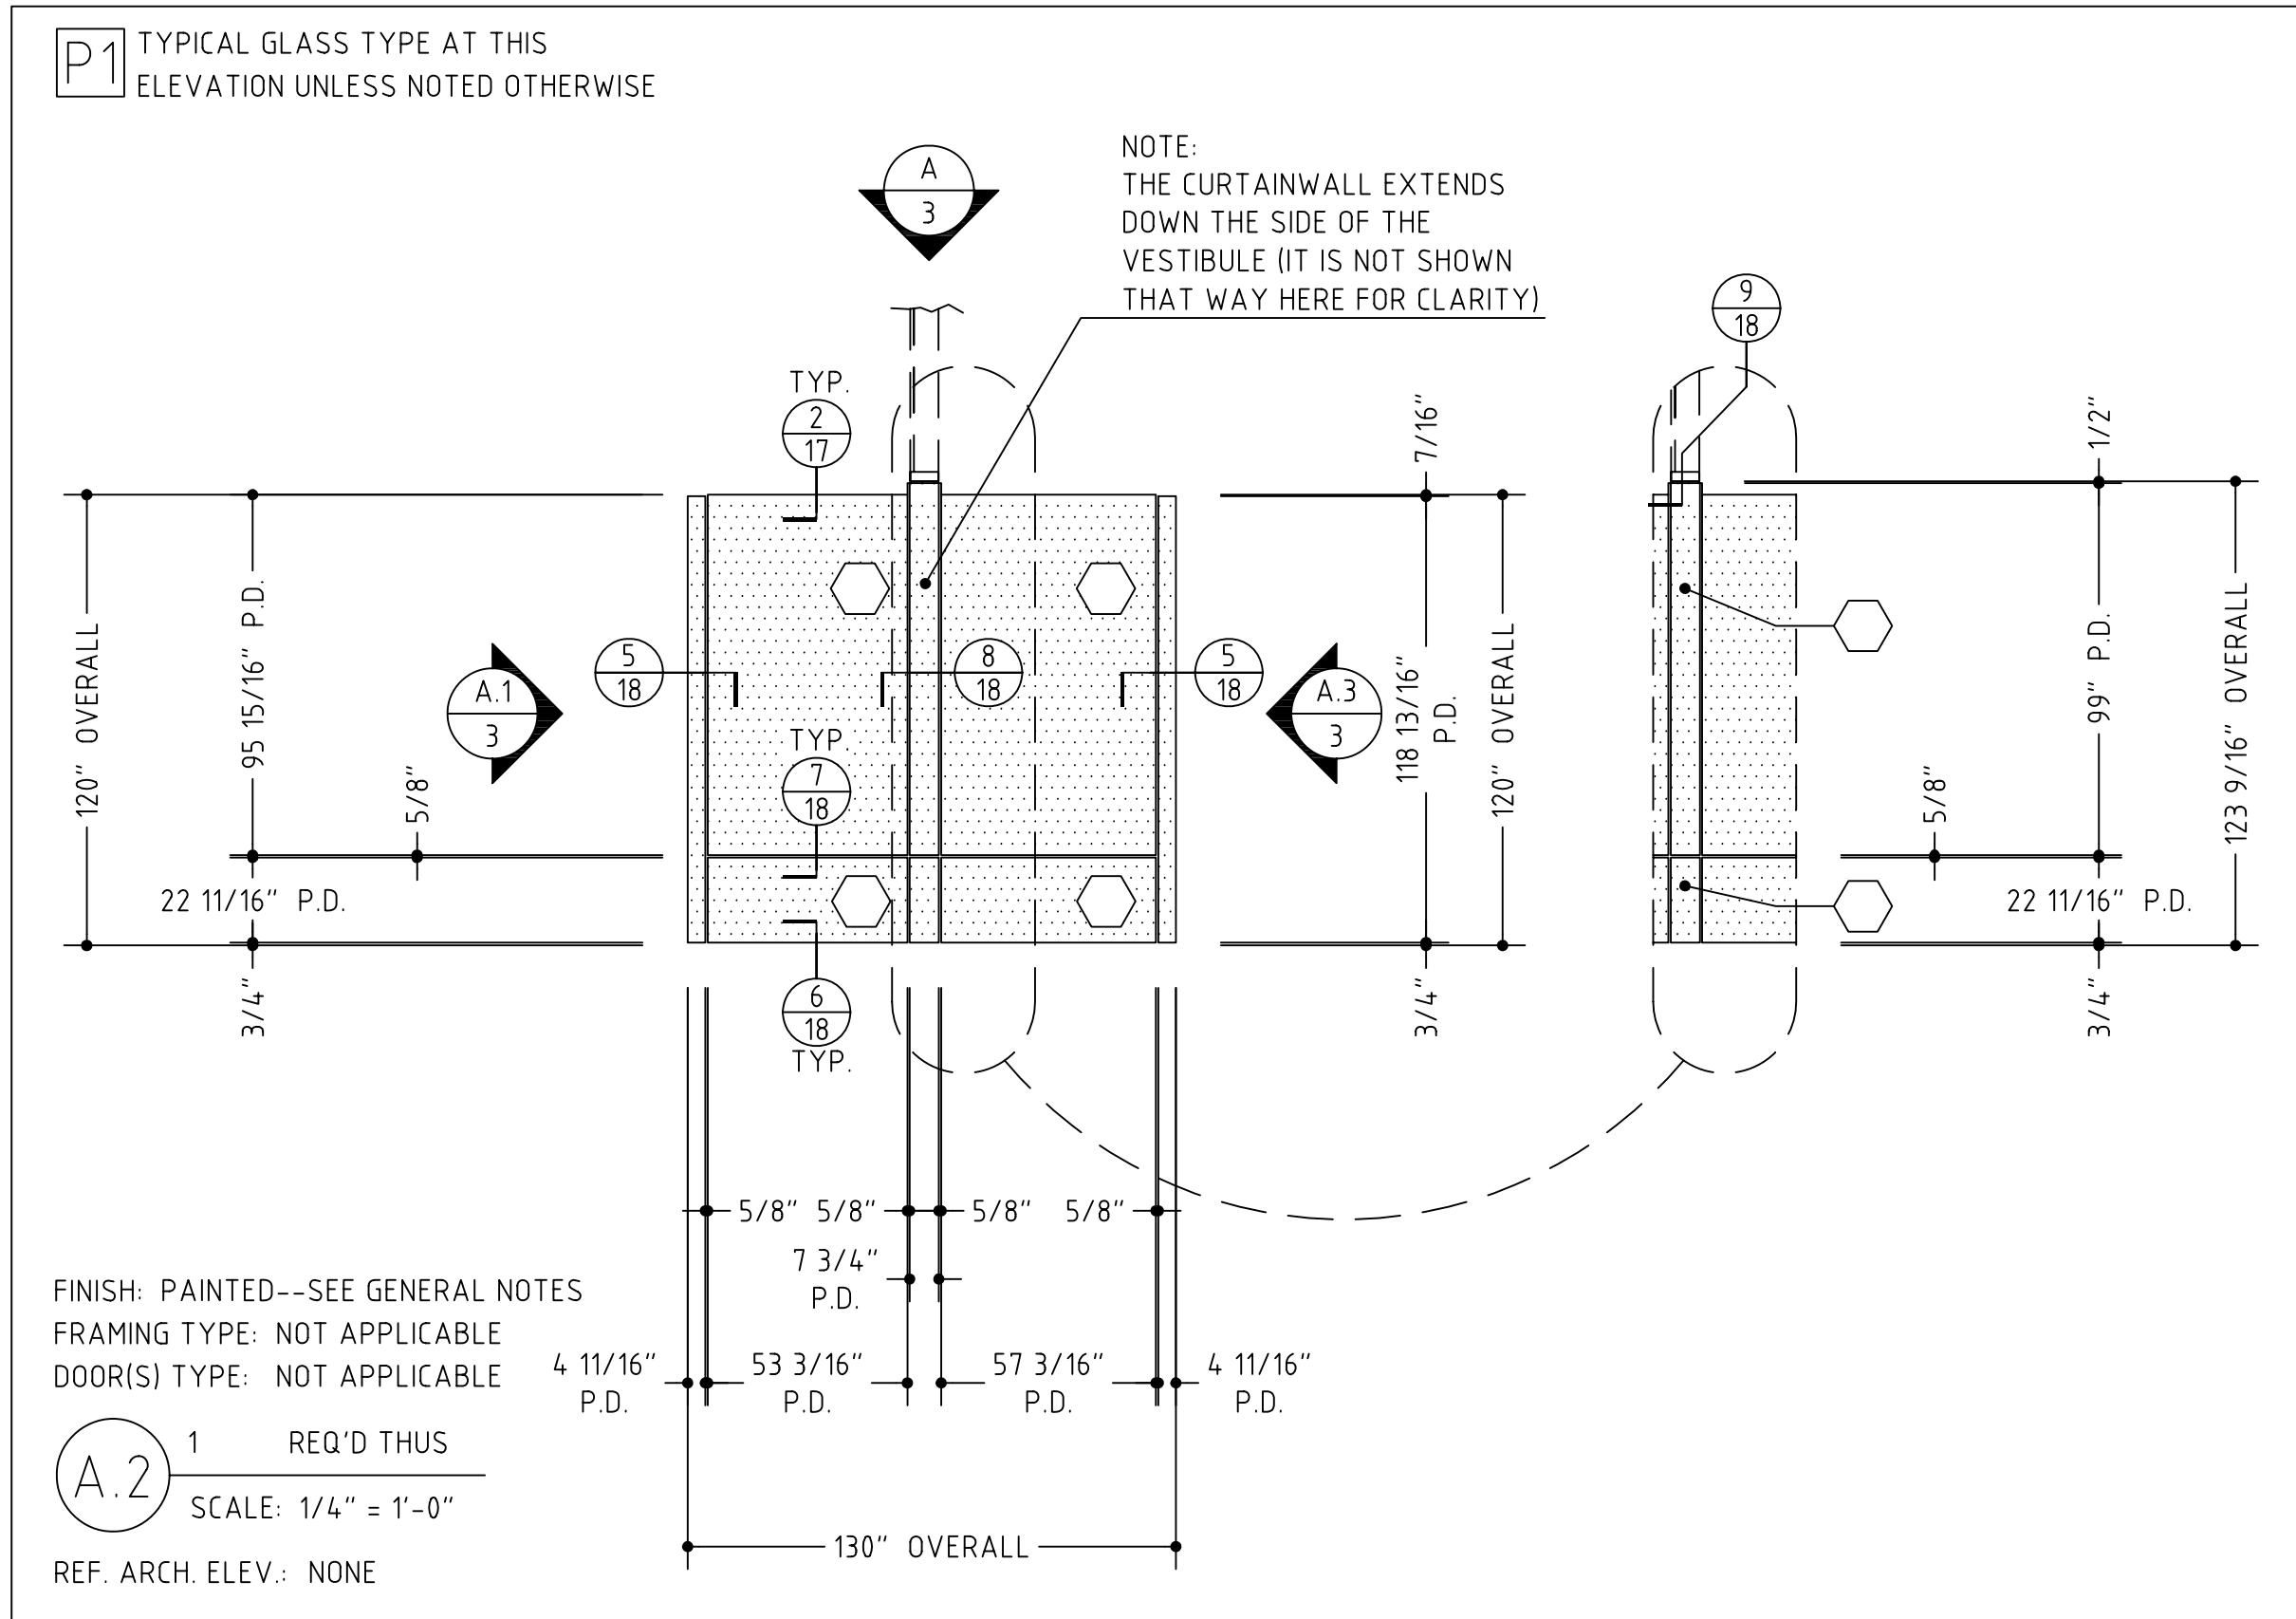

FABRICATION RELEASE:




THE PANEL DIMENSIONS HAVE BEEN REVIEWED AND APPROVED AS NOTED ON THIS DRAWING. THE PANELS ARE HEREBY RELEASED FOR FABRICATION.

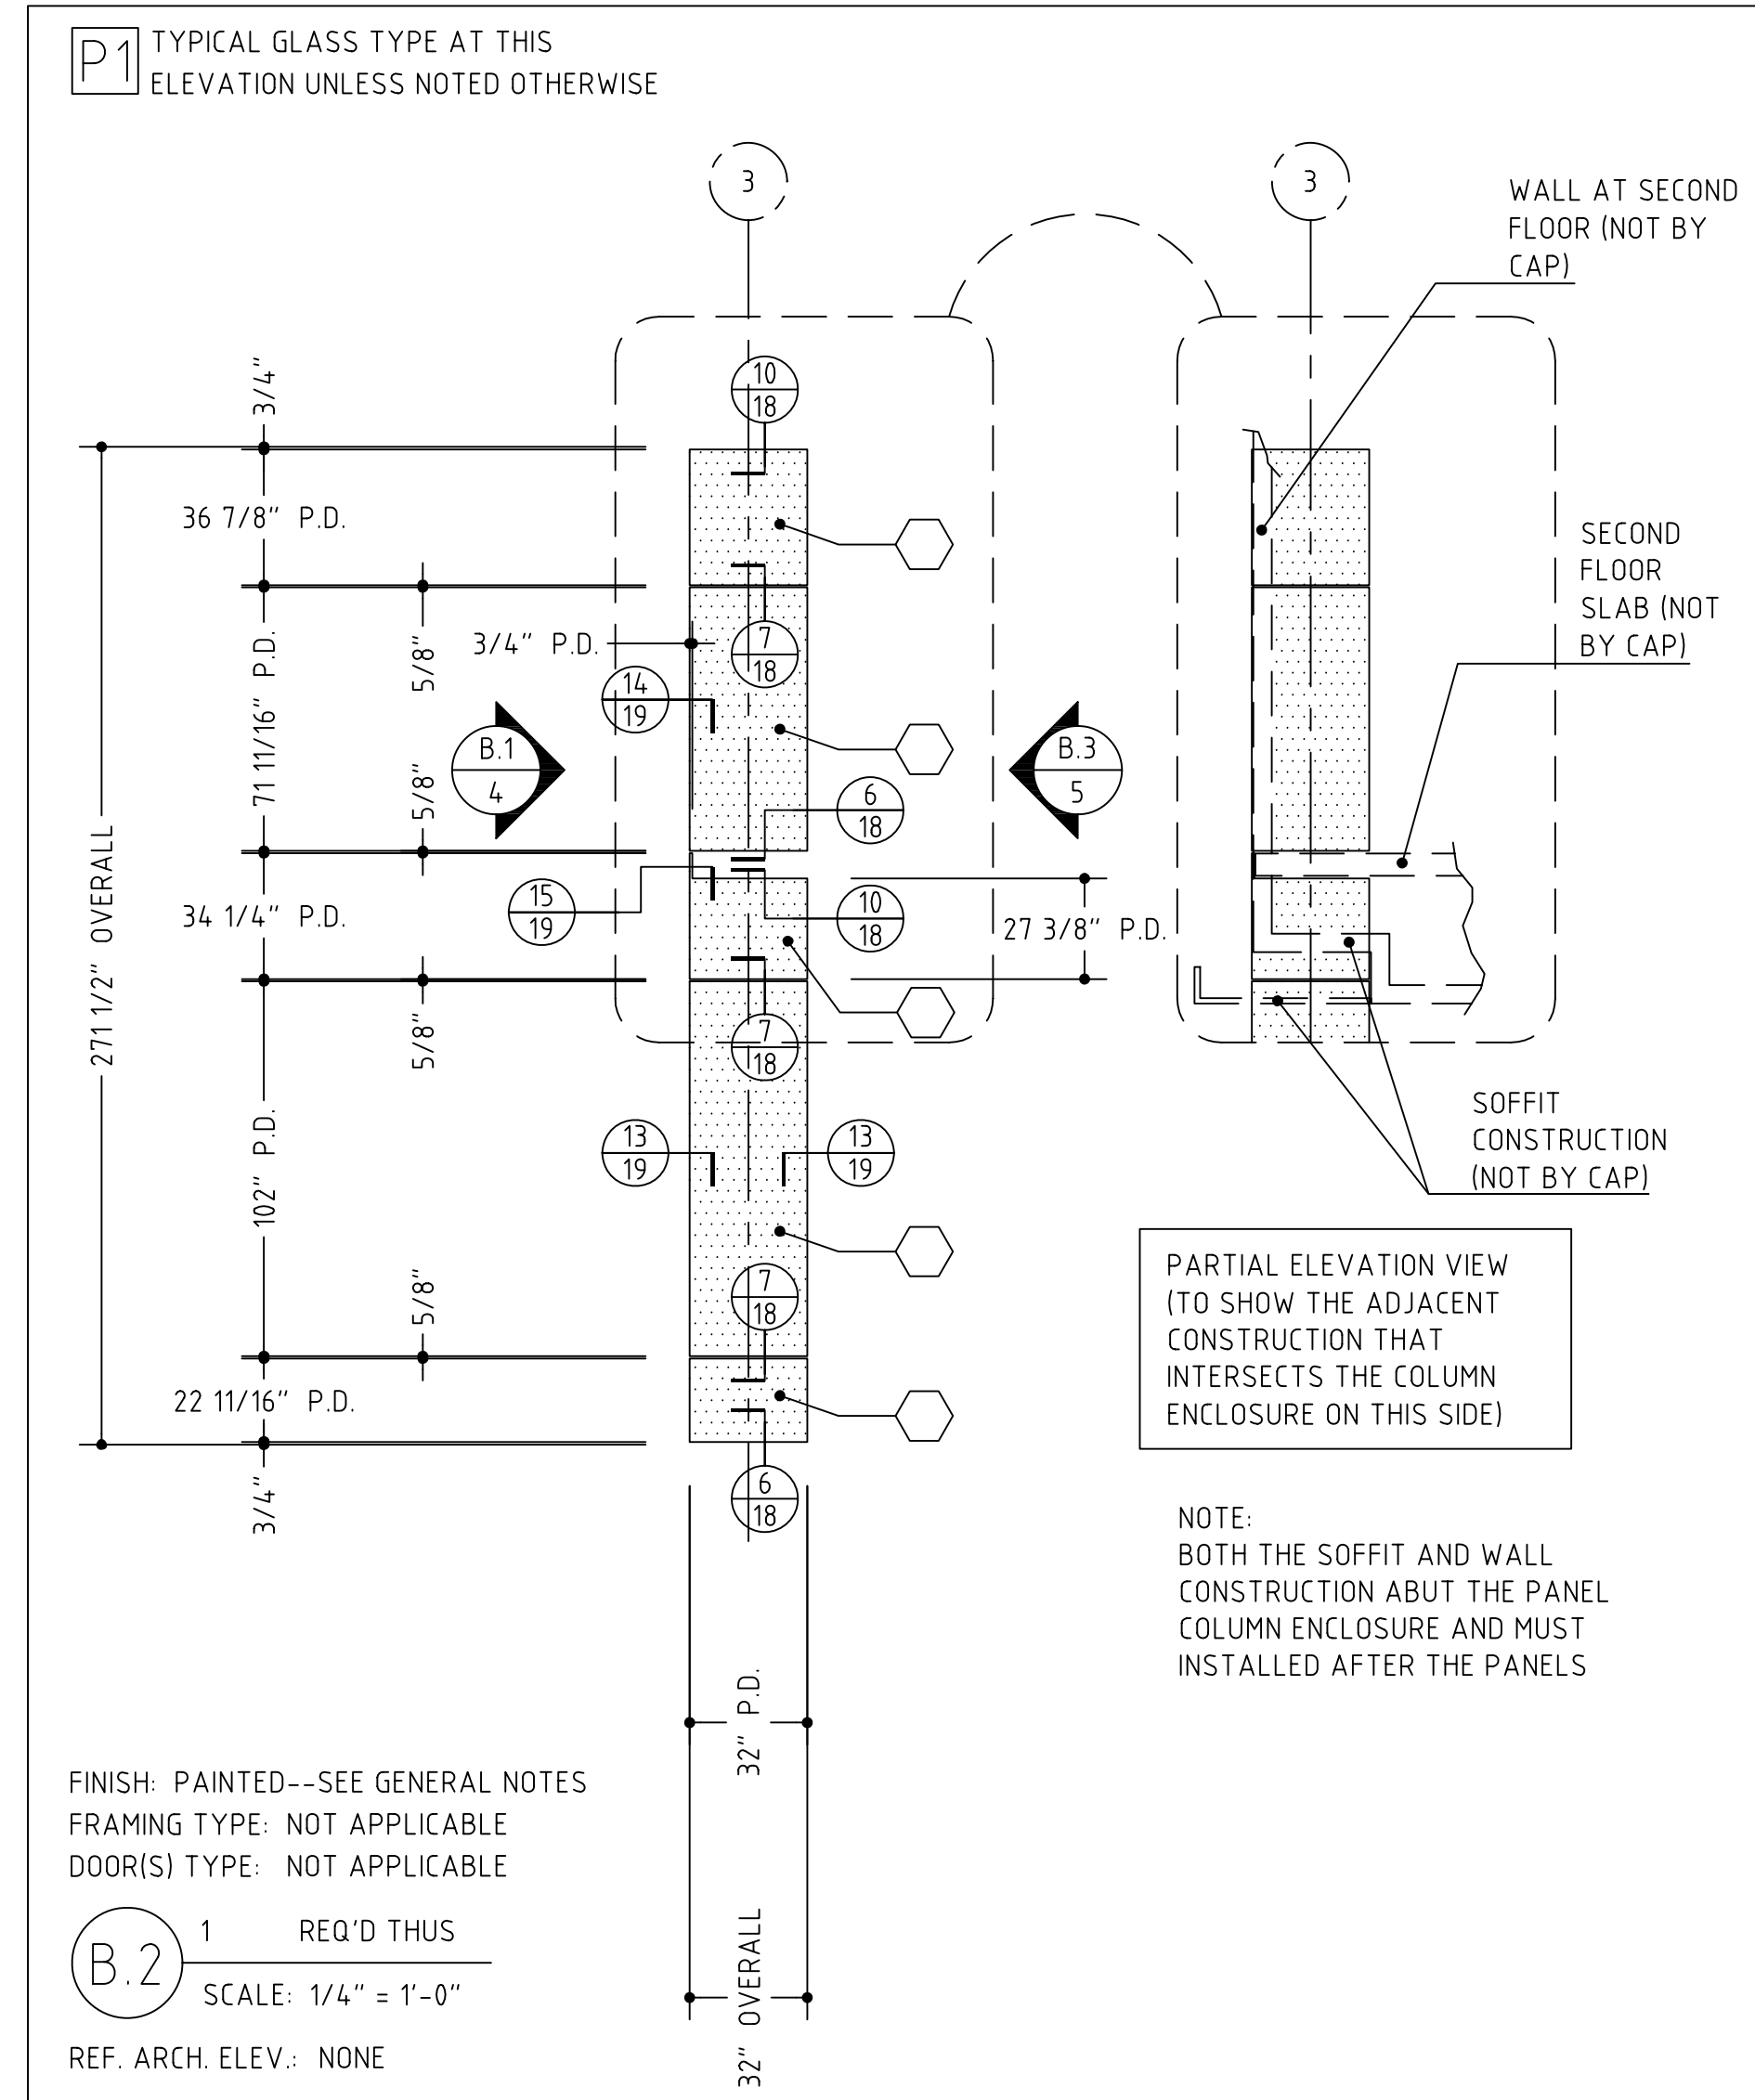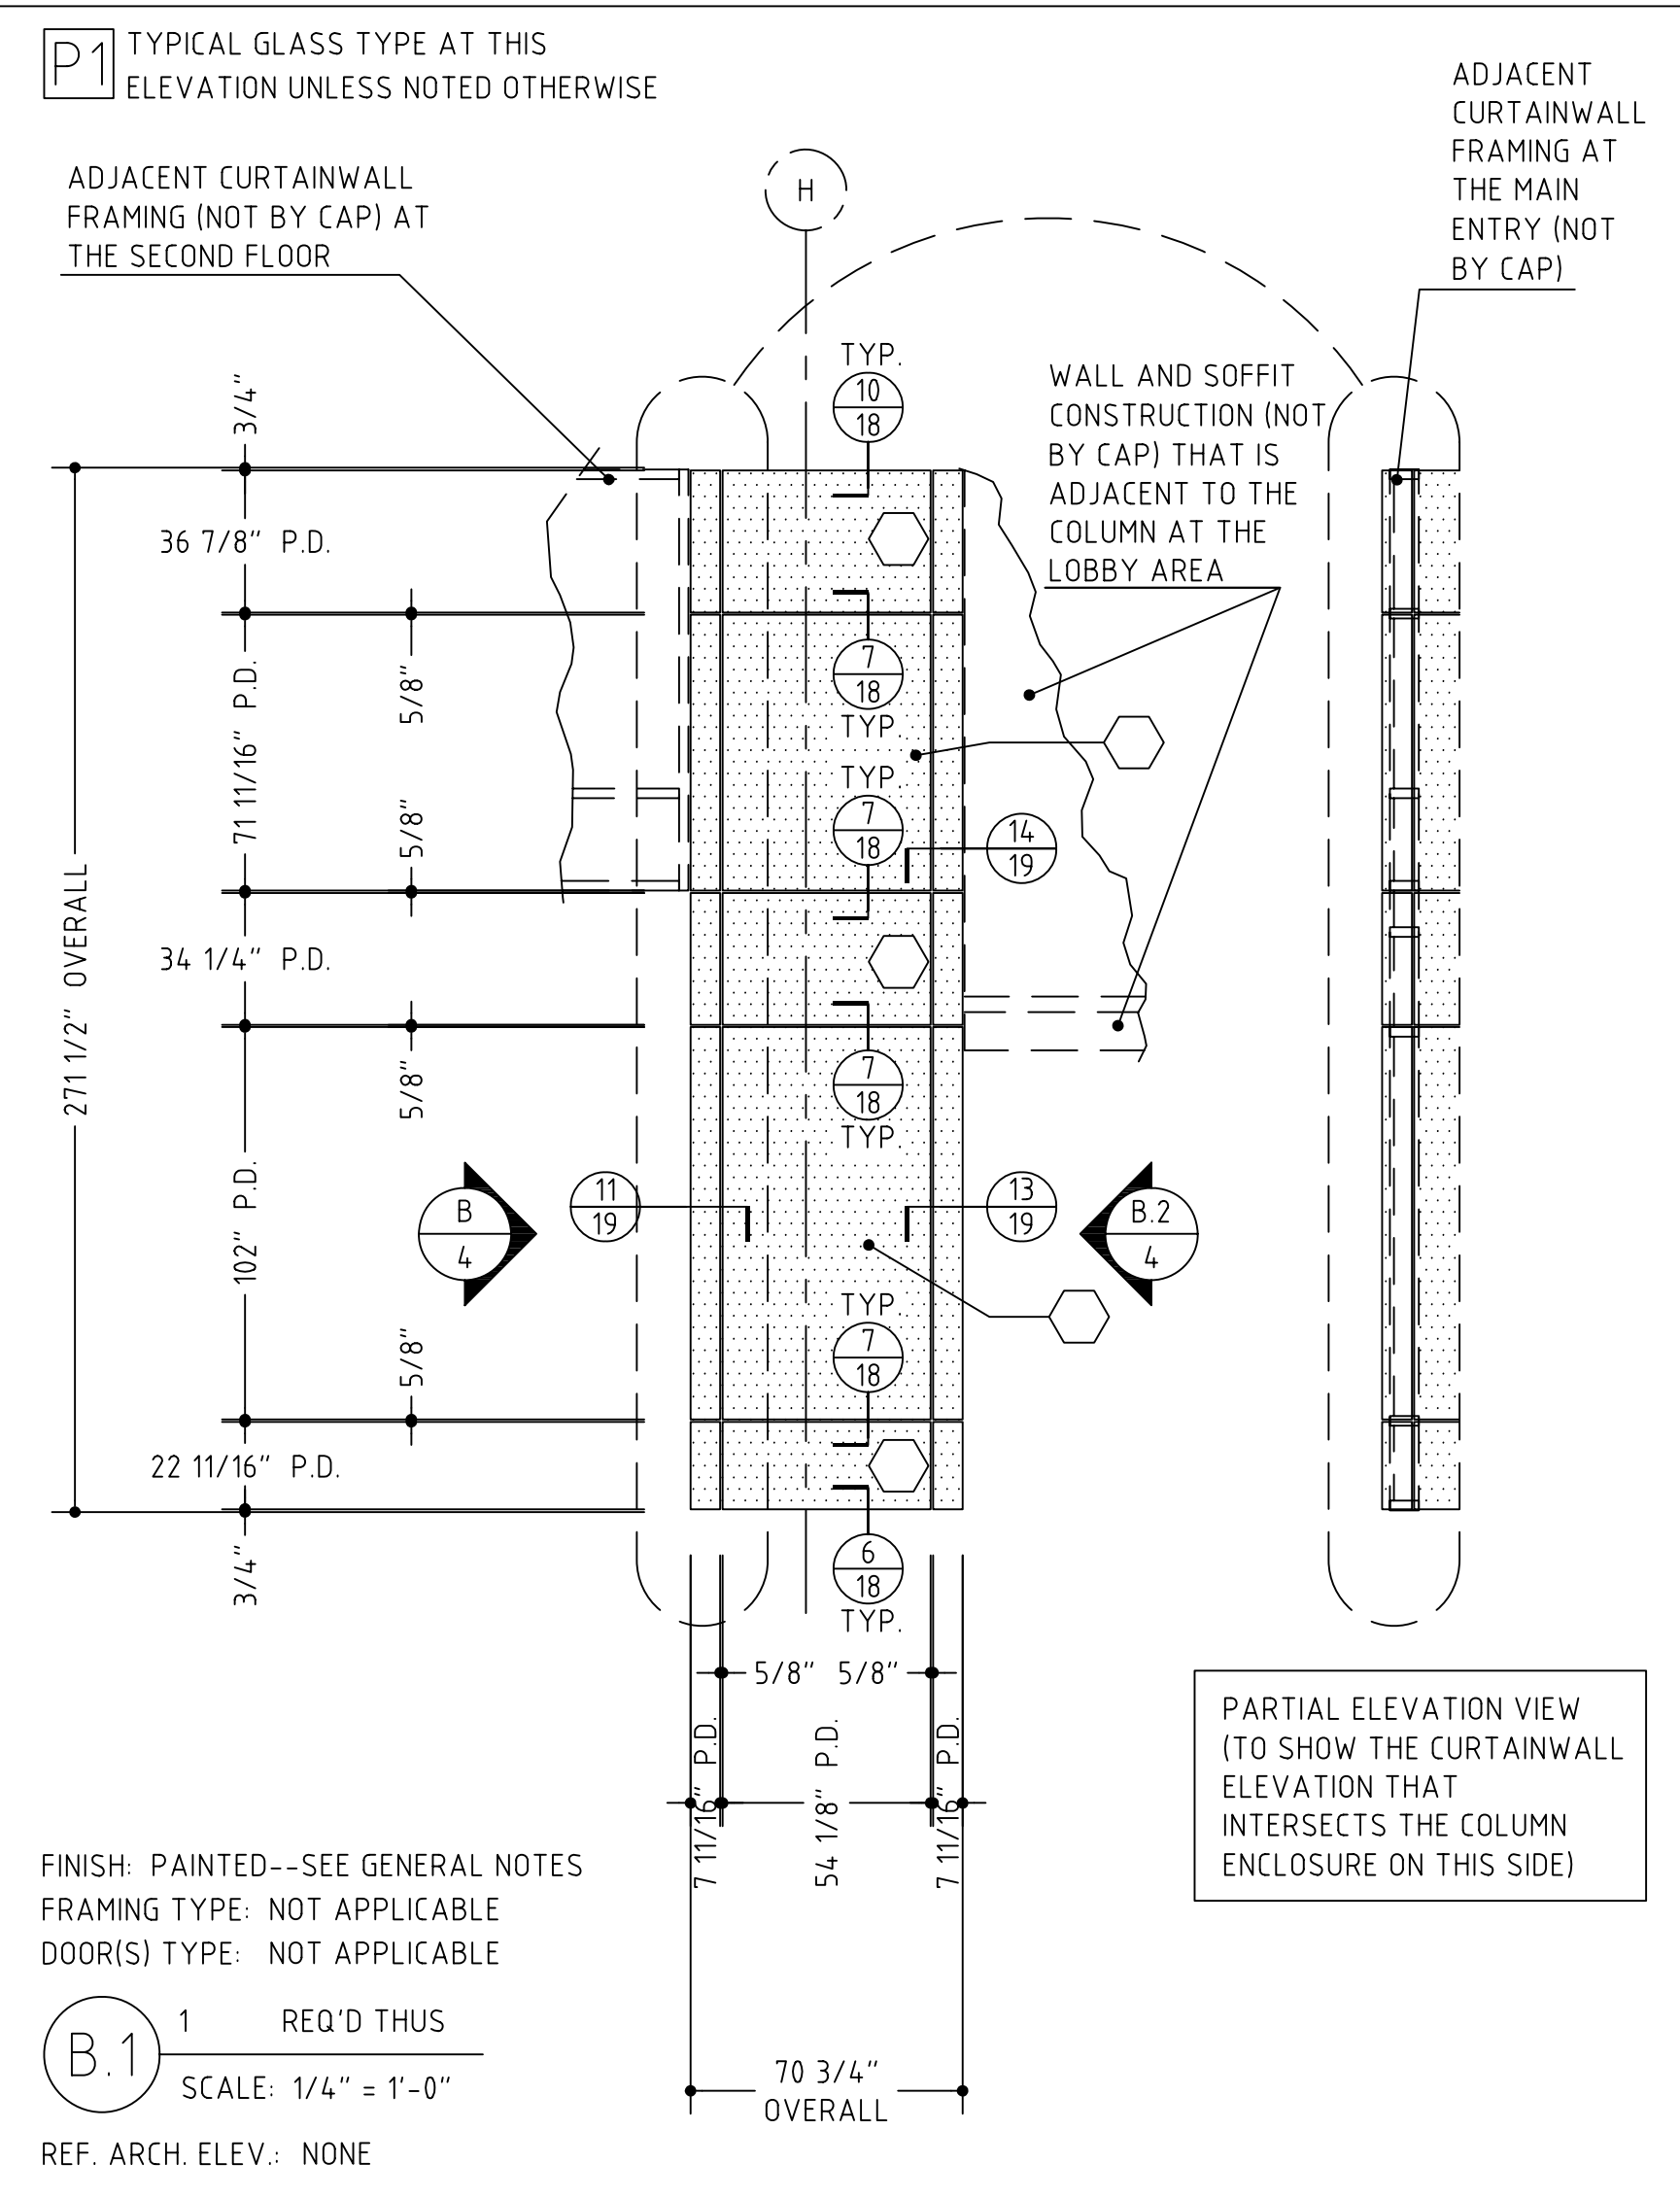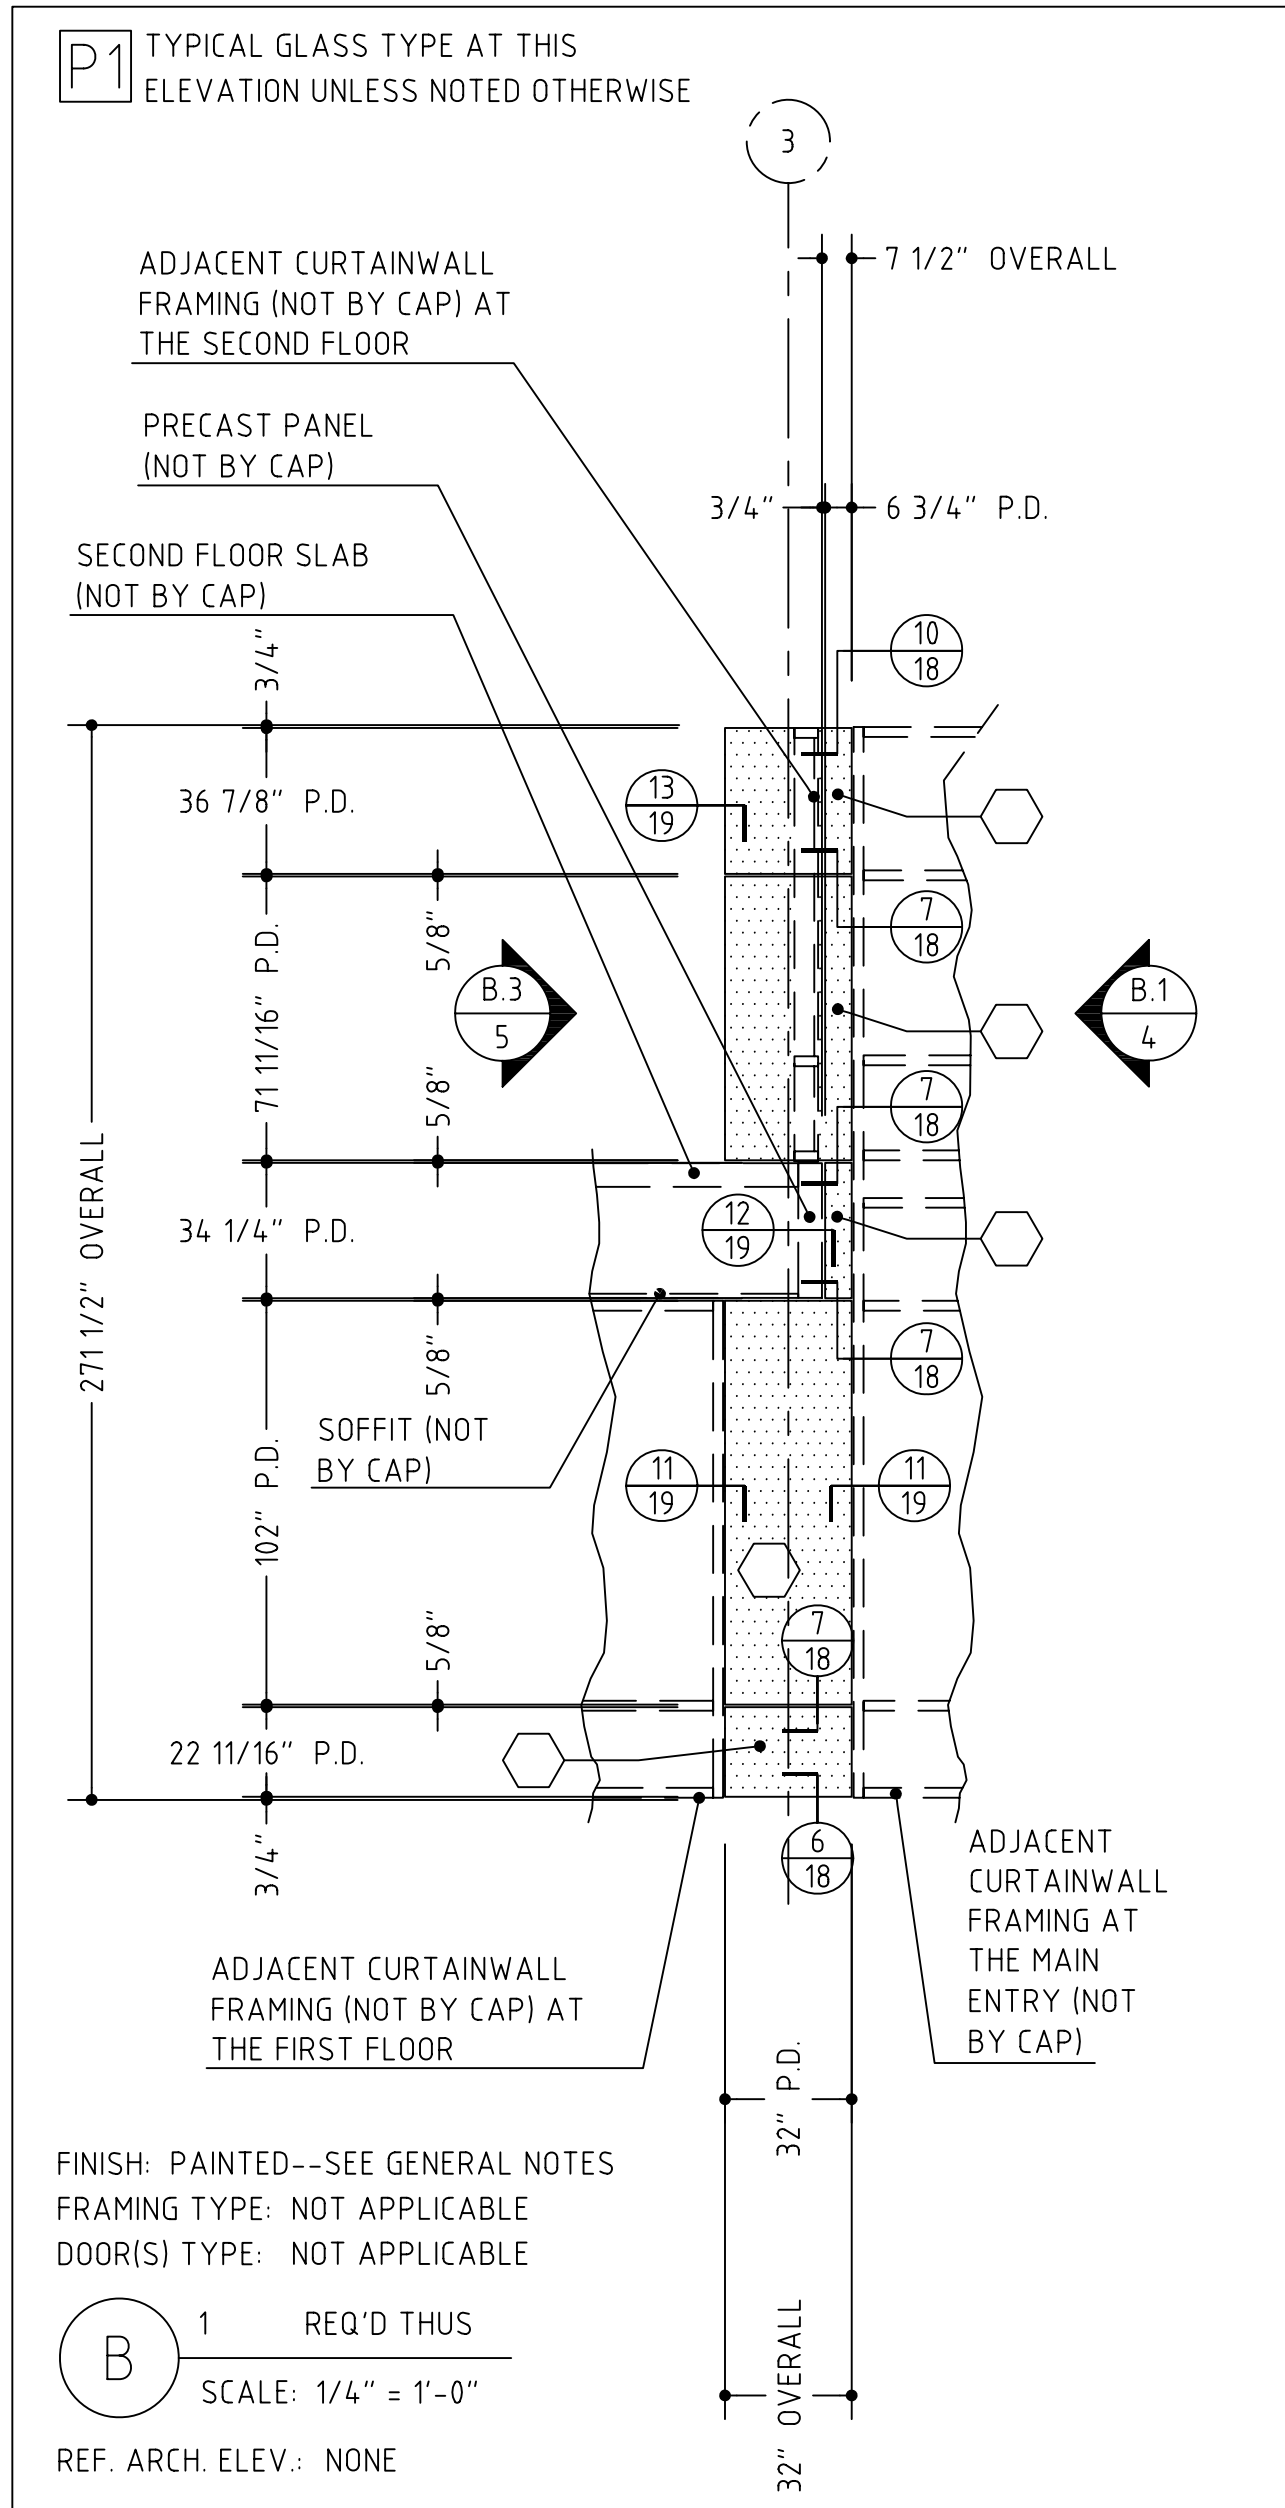






FABRICATION RELEASE:

THE PANEL DIMENSIONS HAVE BEEN REVIEWED AND APPROVED AS NOTED ON THIS DRAWING. THE PANELS ARE HEREBY RELEASED FOR FABRICATION.

VERIFY ALL DIMENSIONS

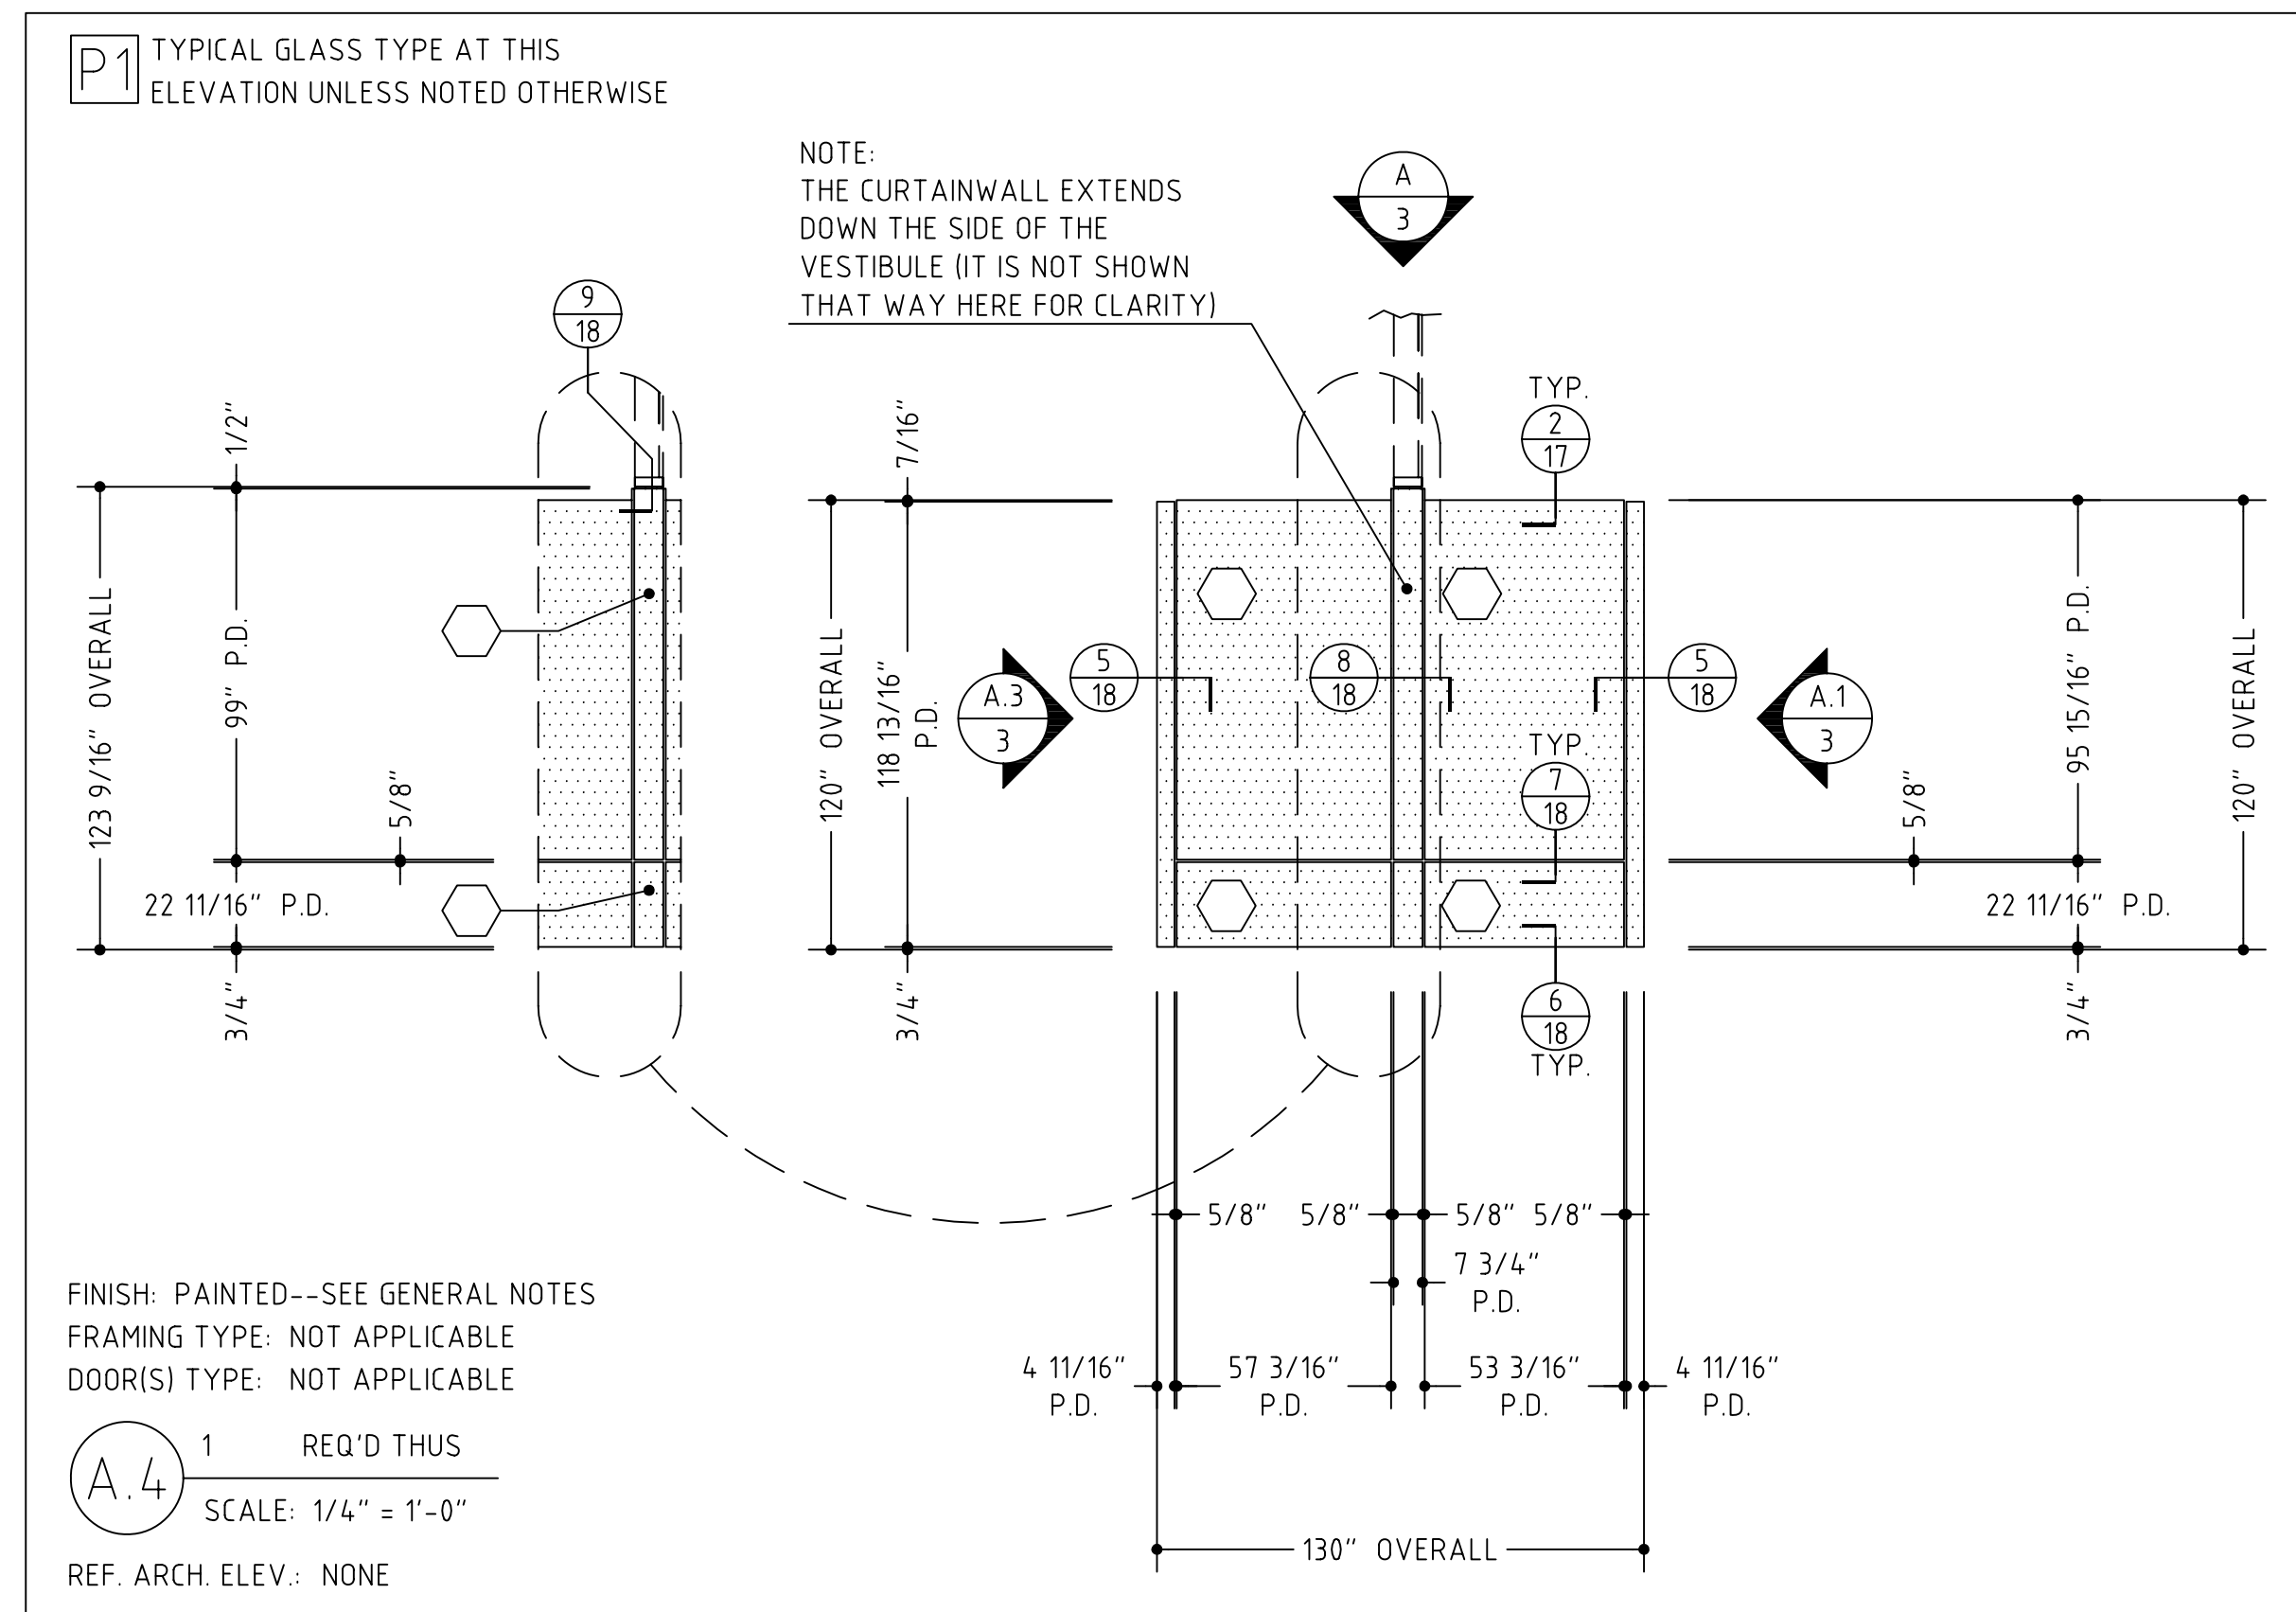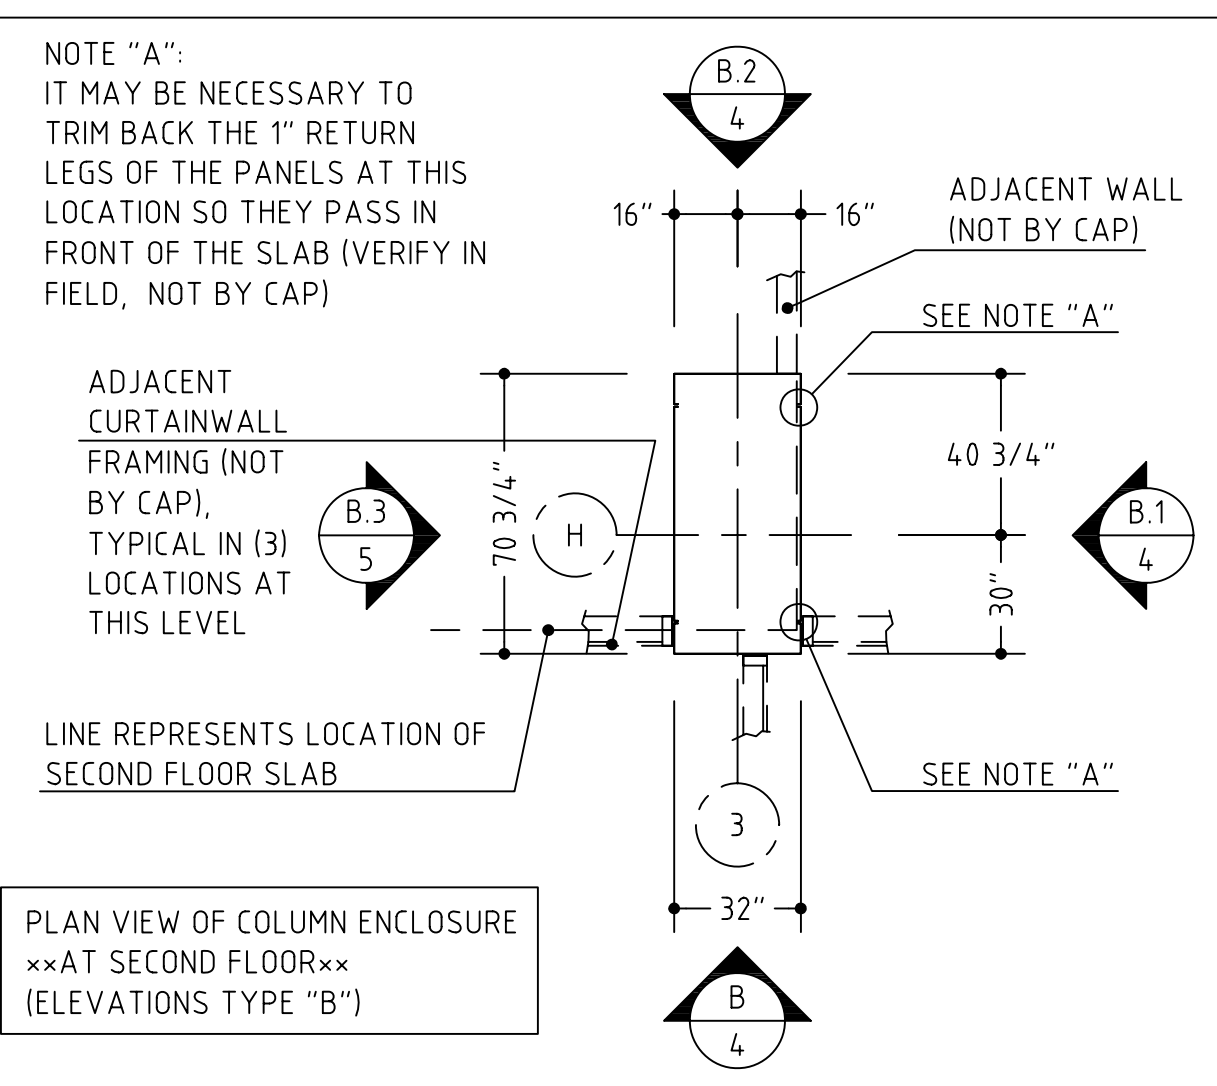
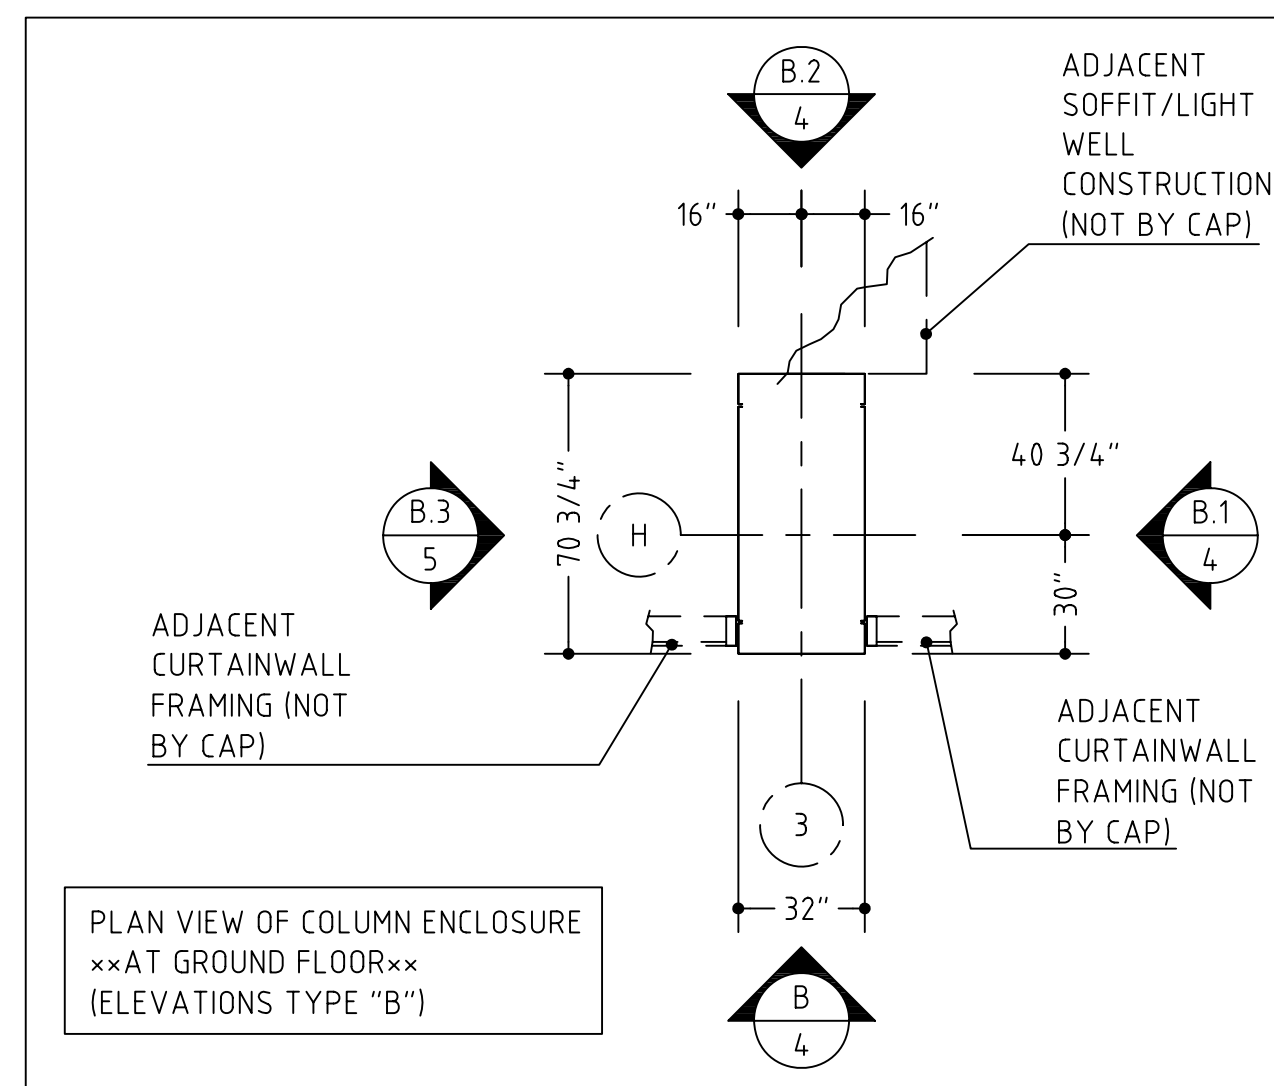


VERIFY ALL DIMENSIONS

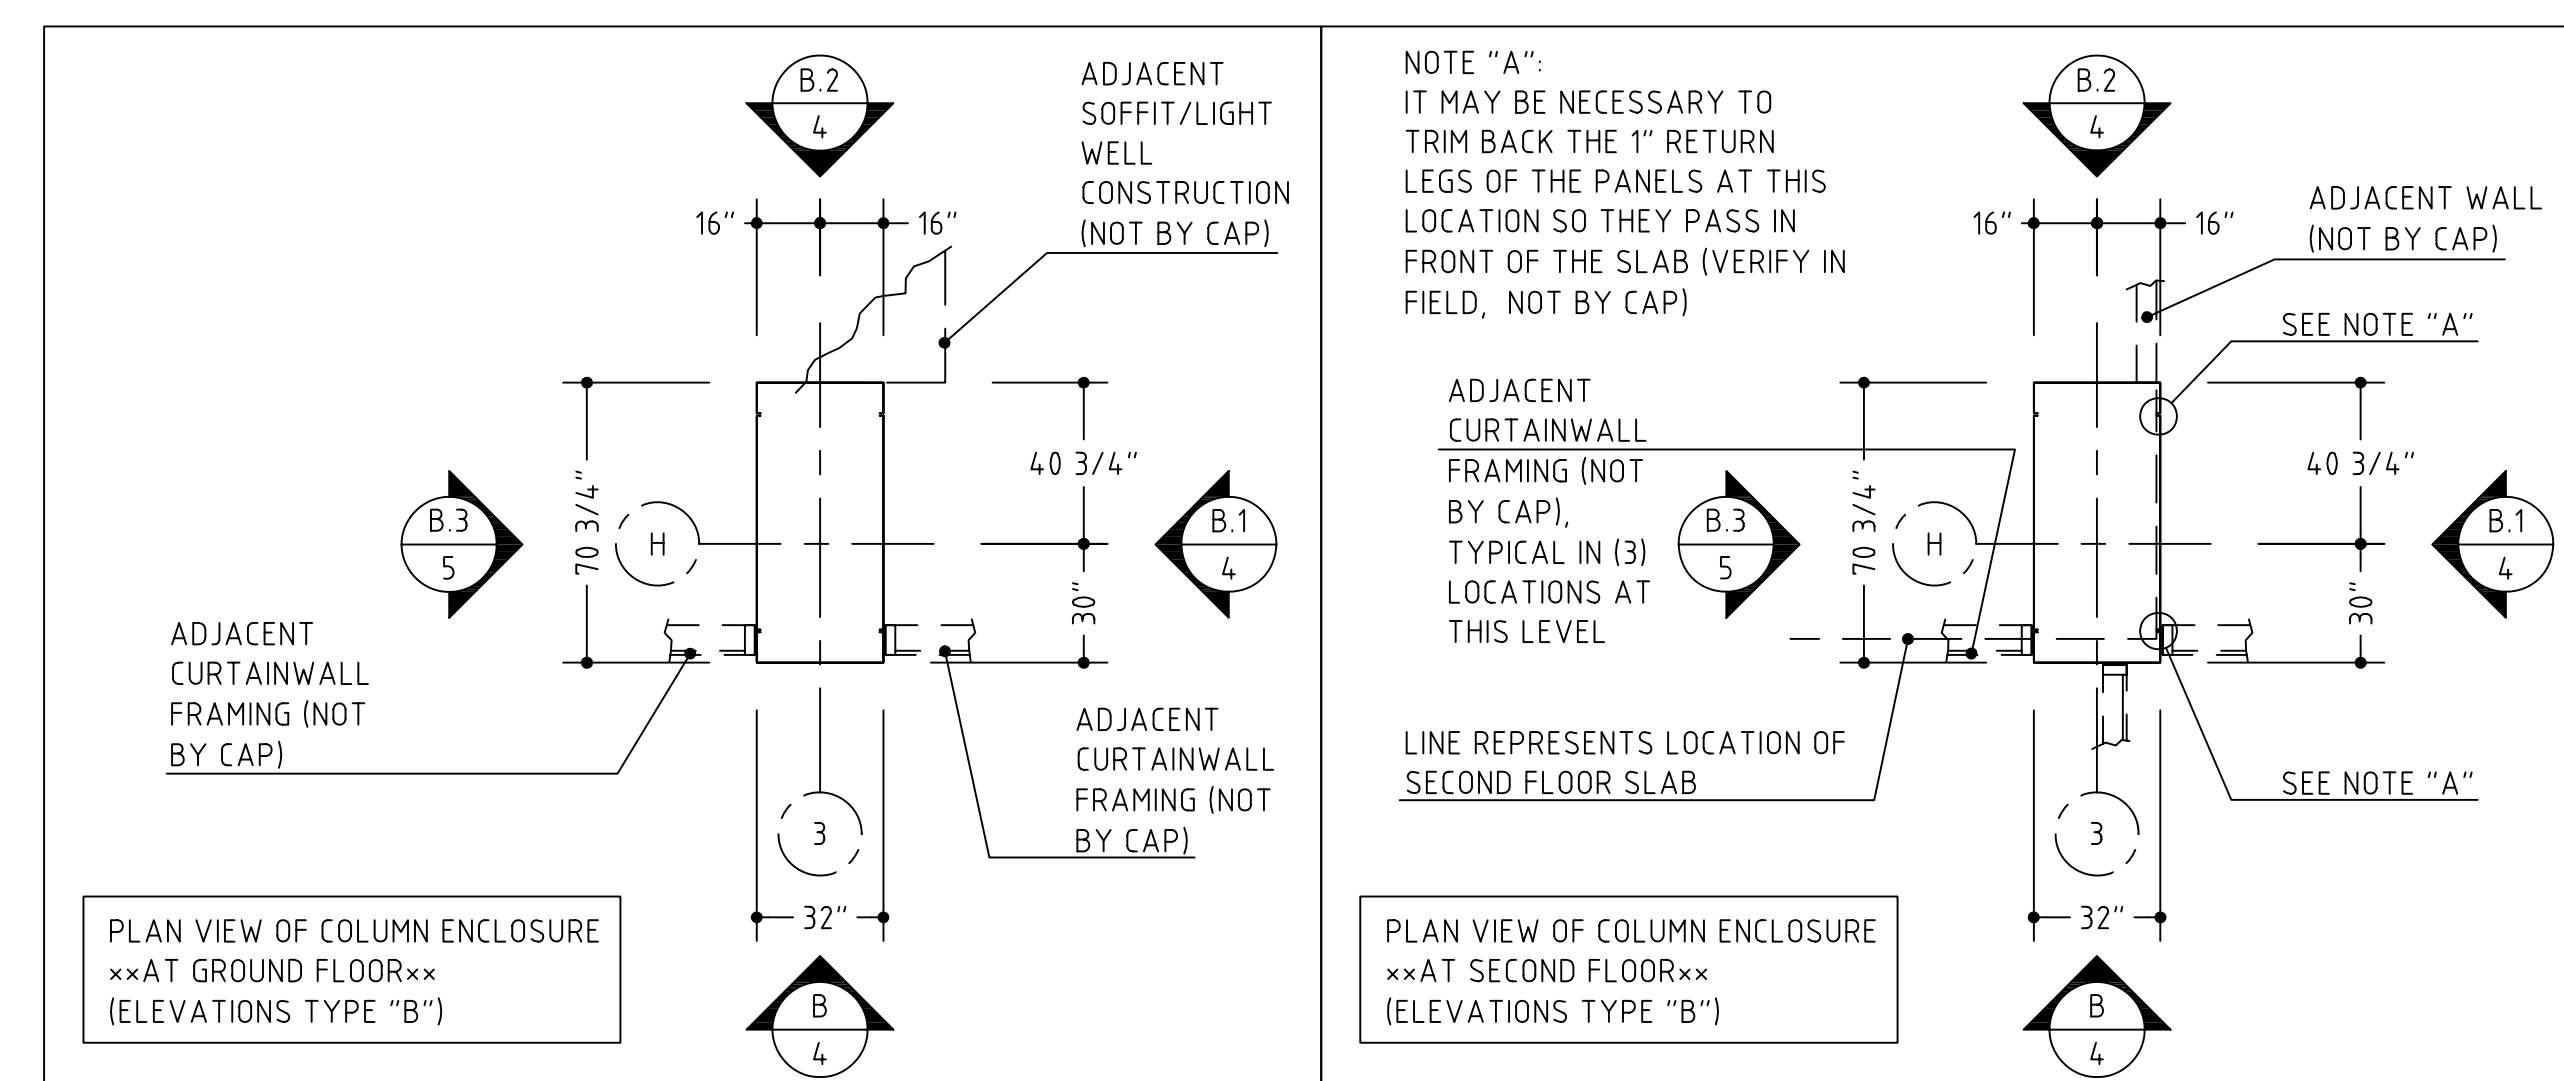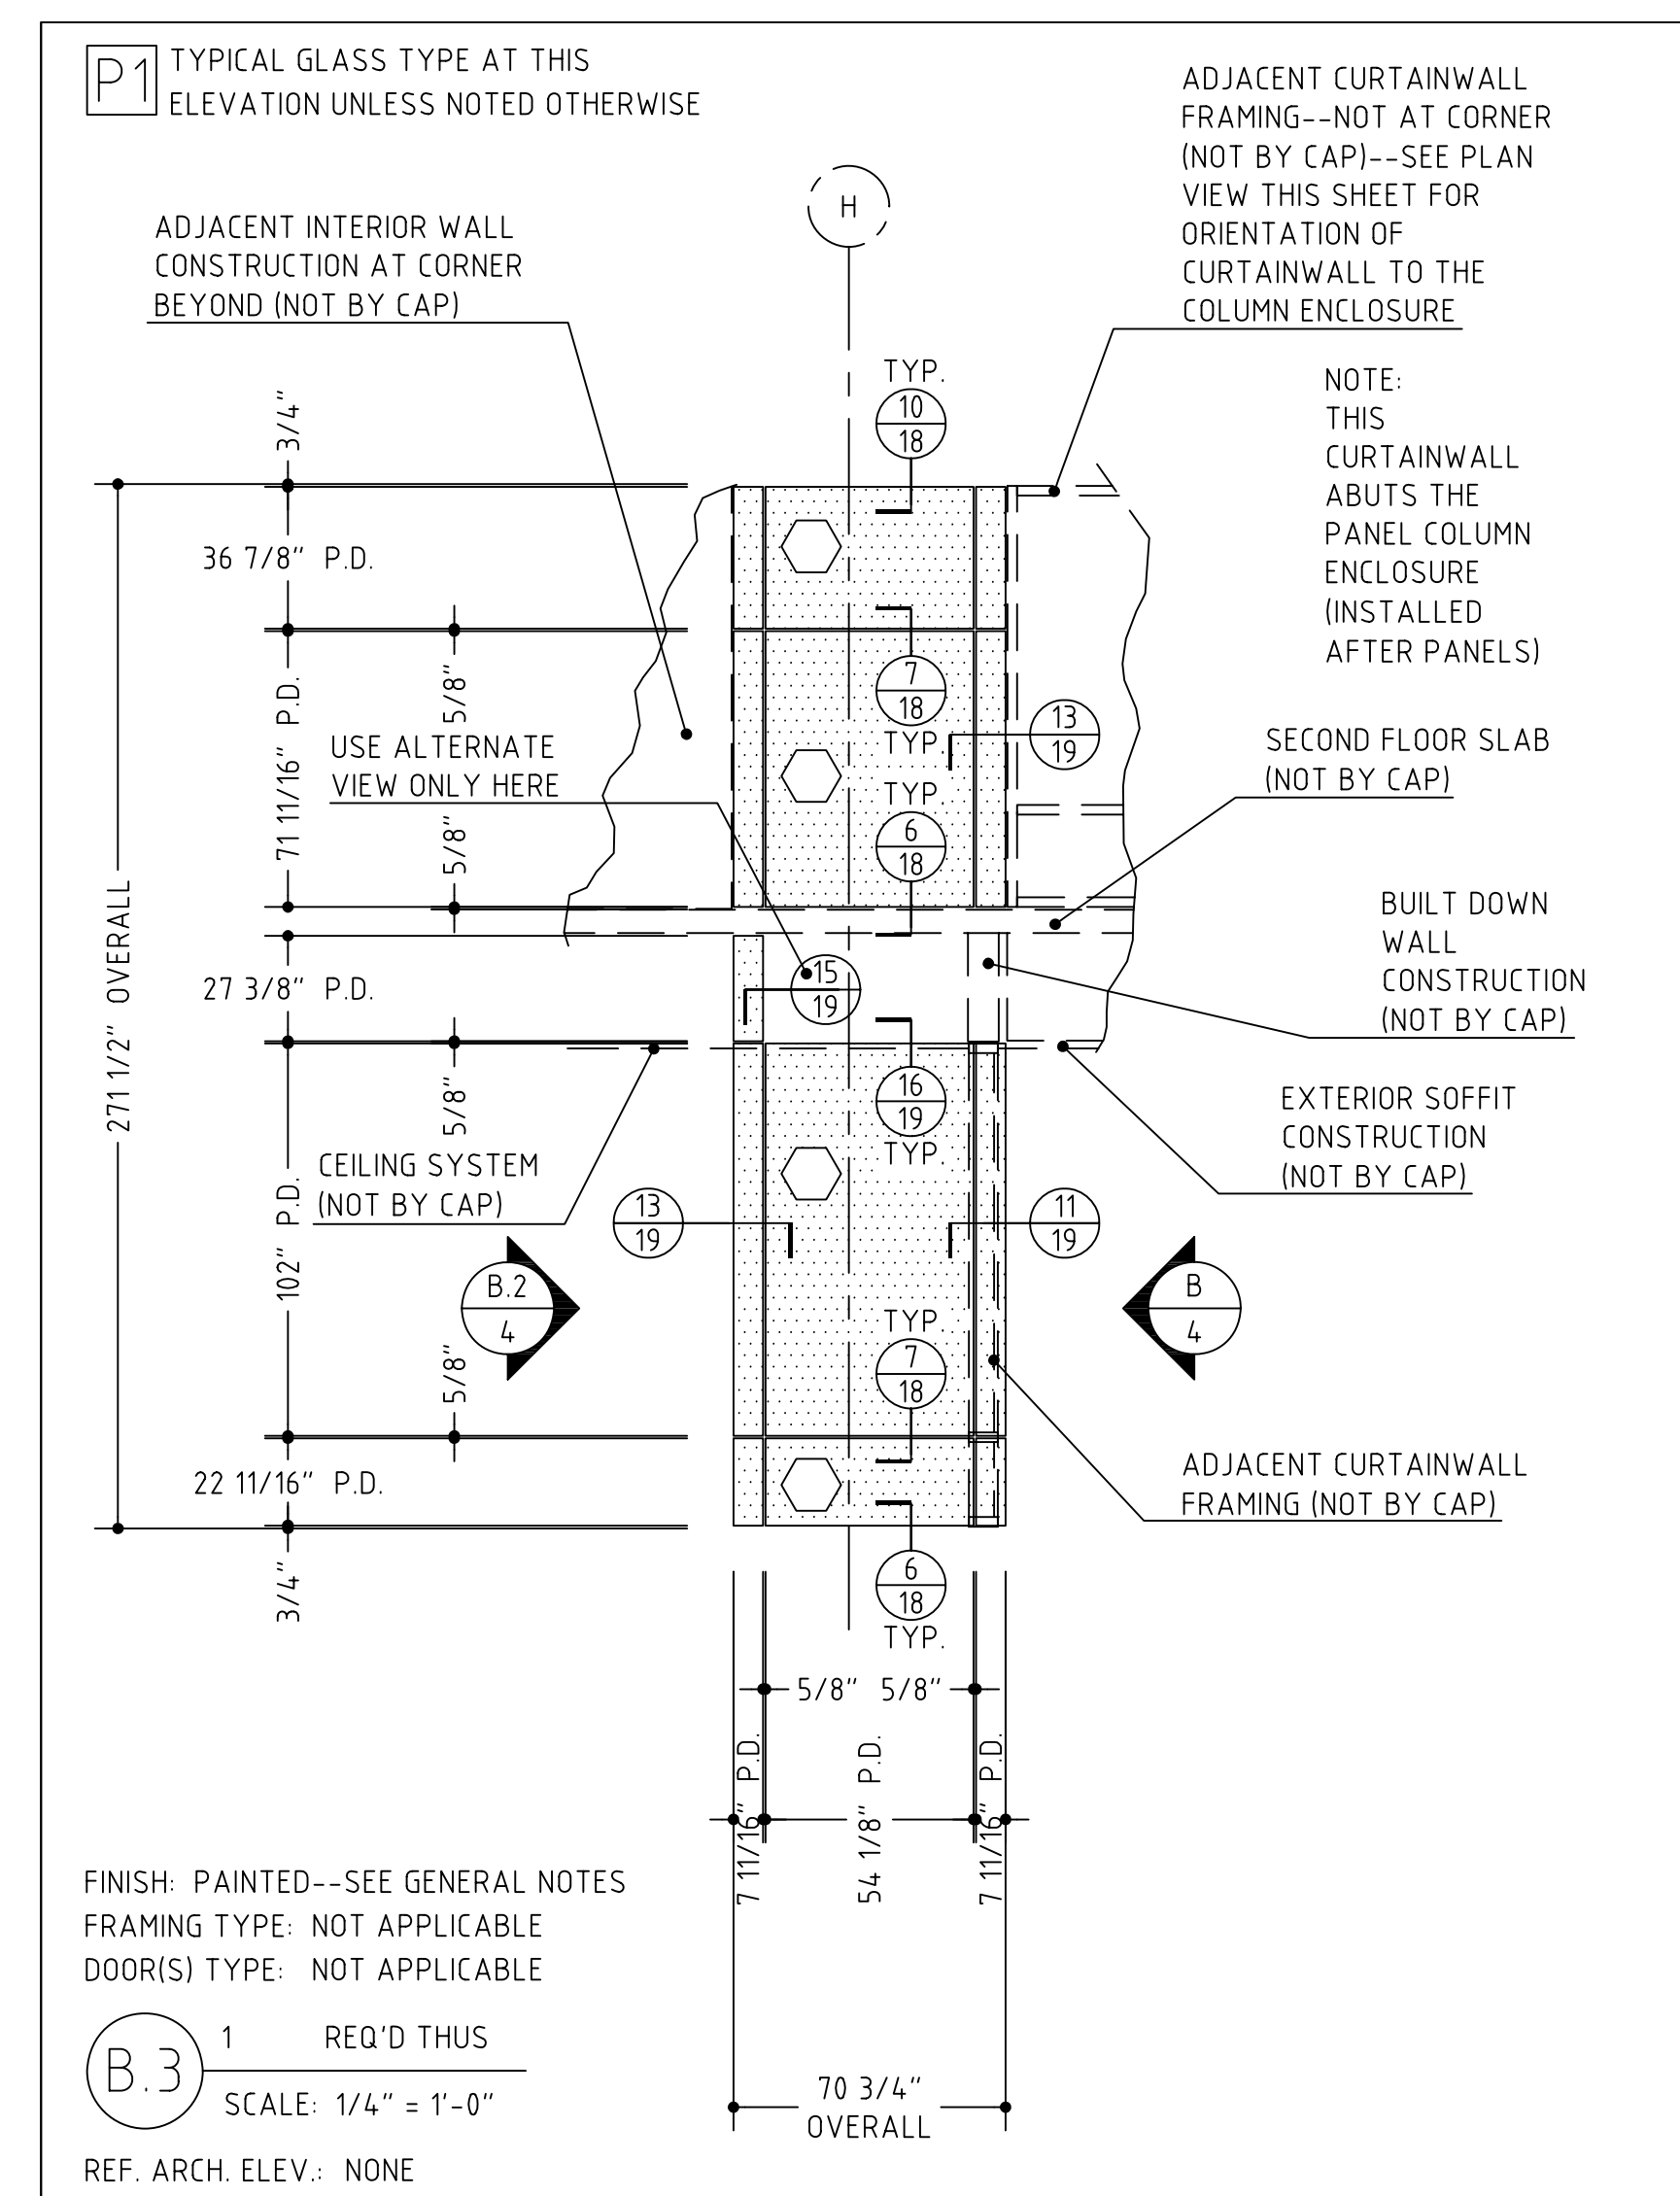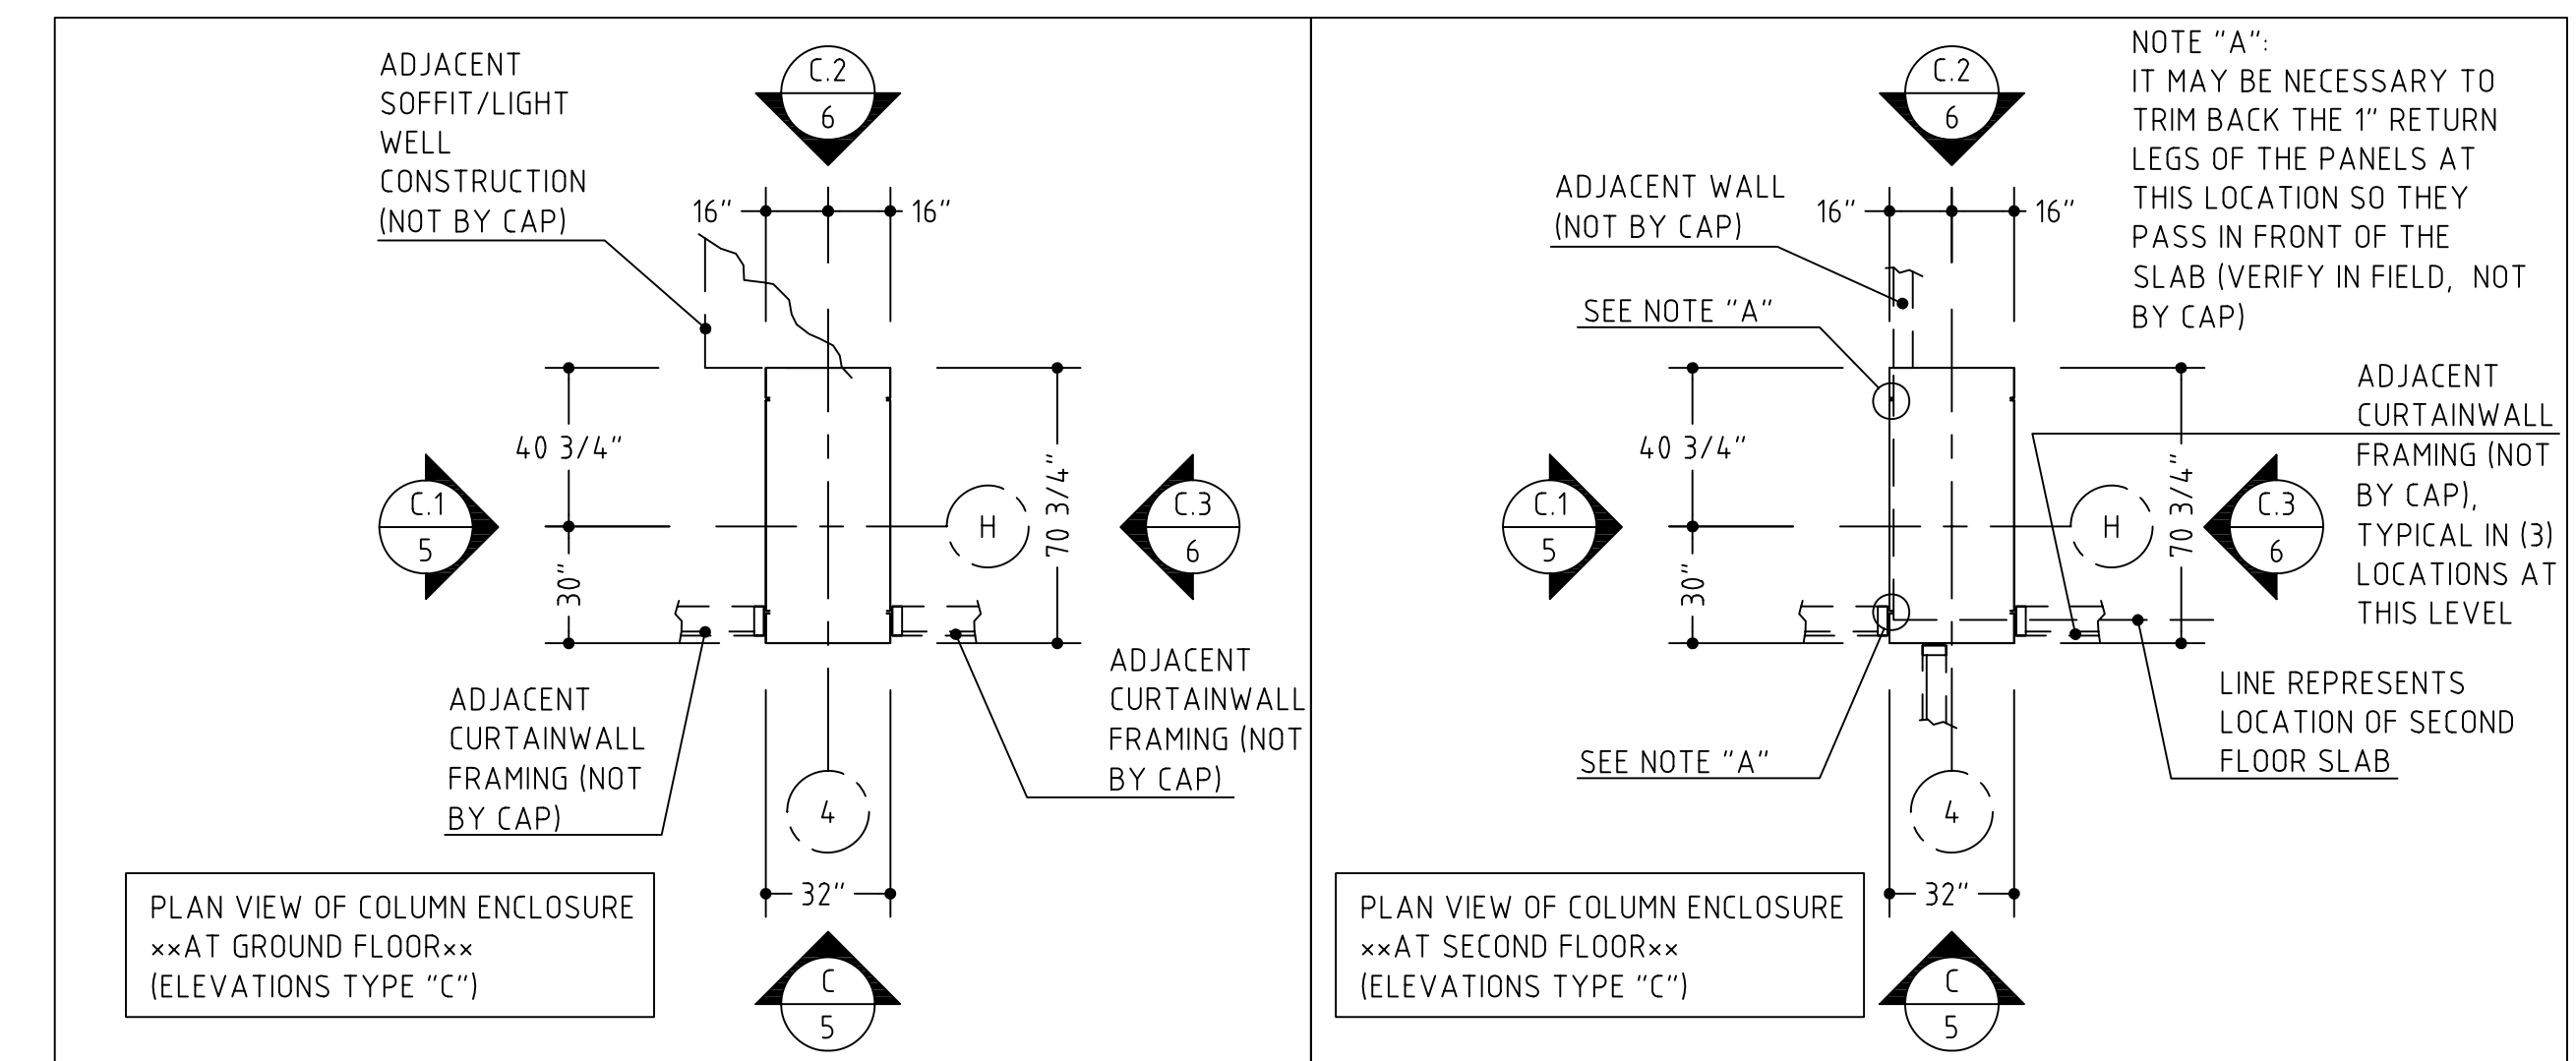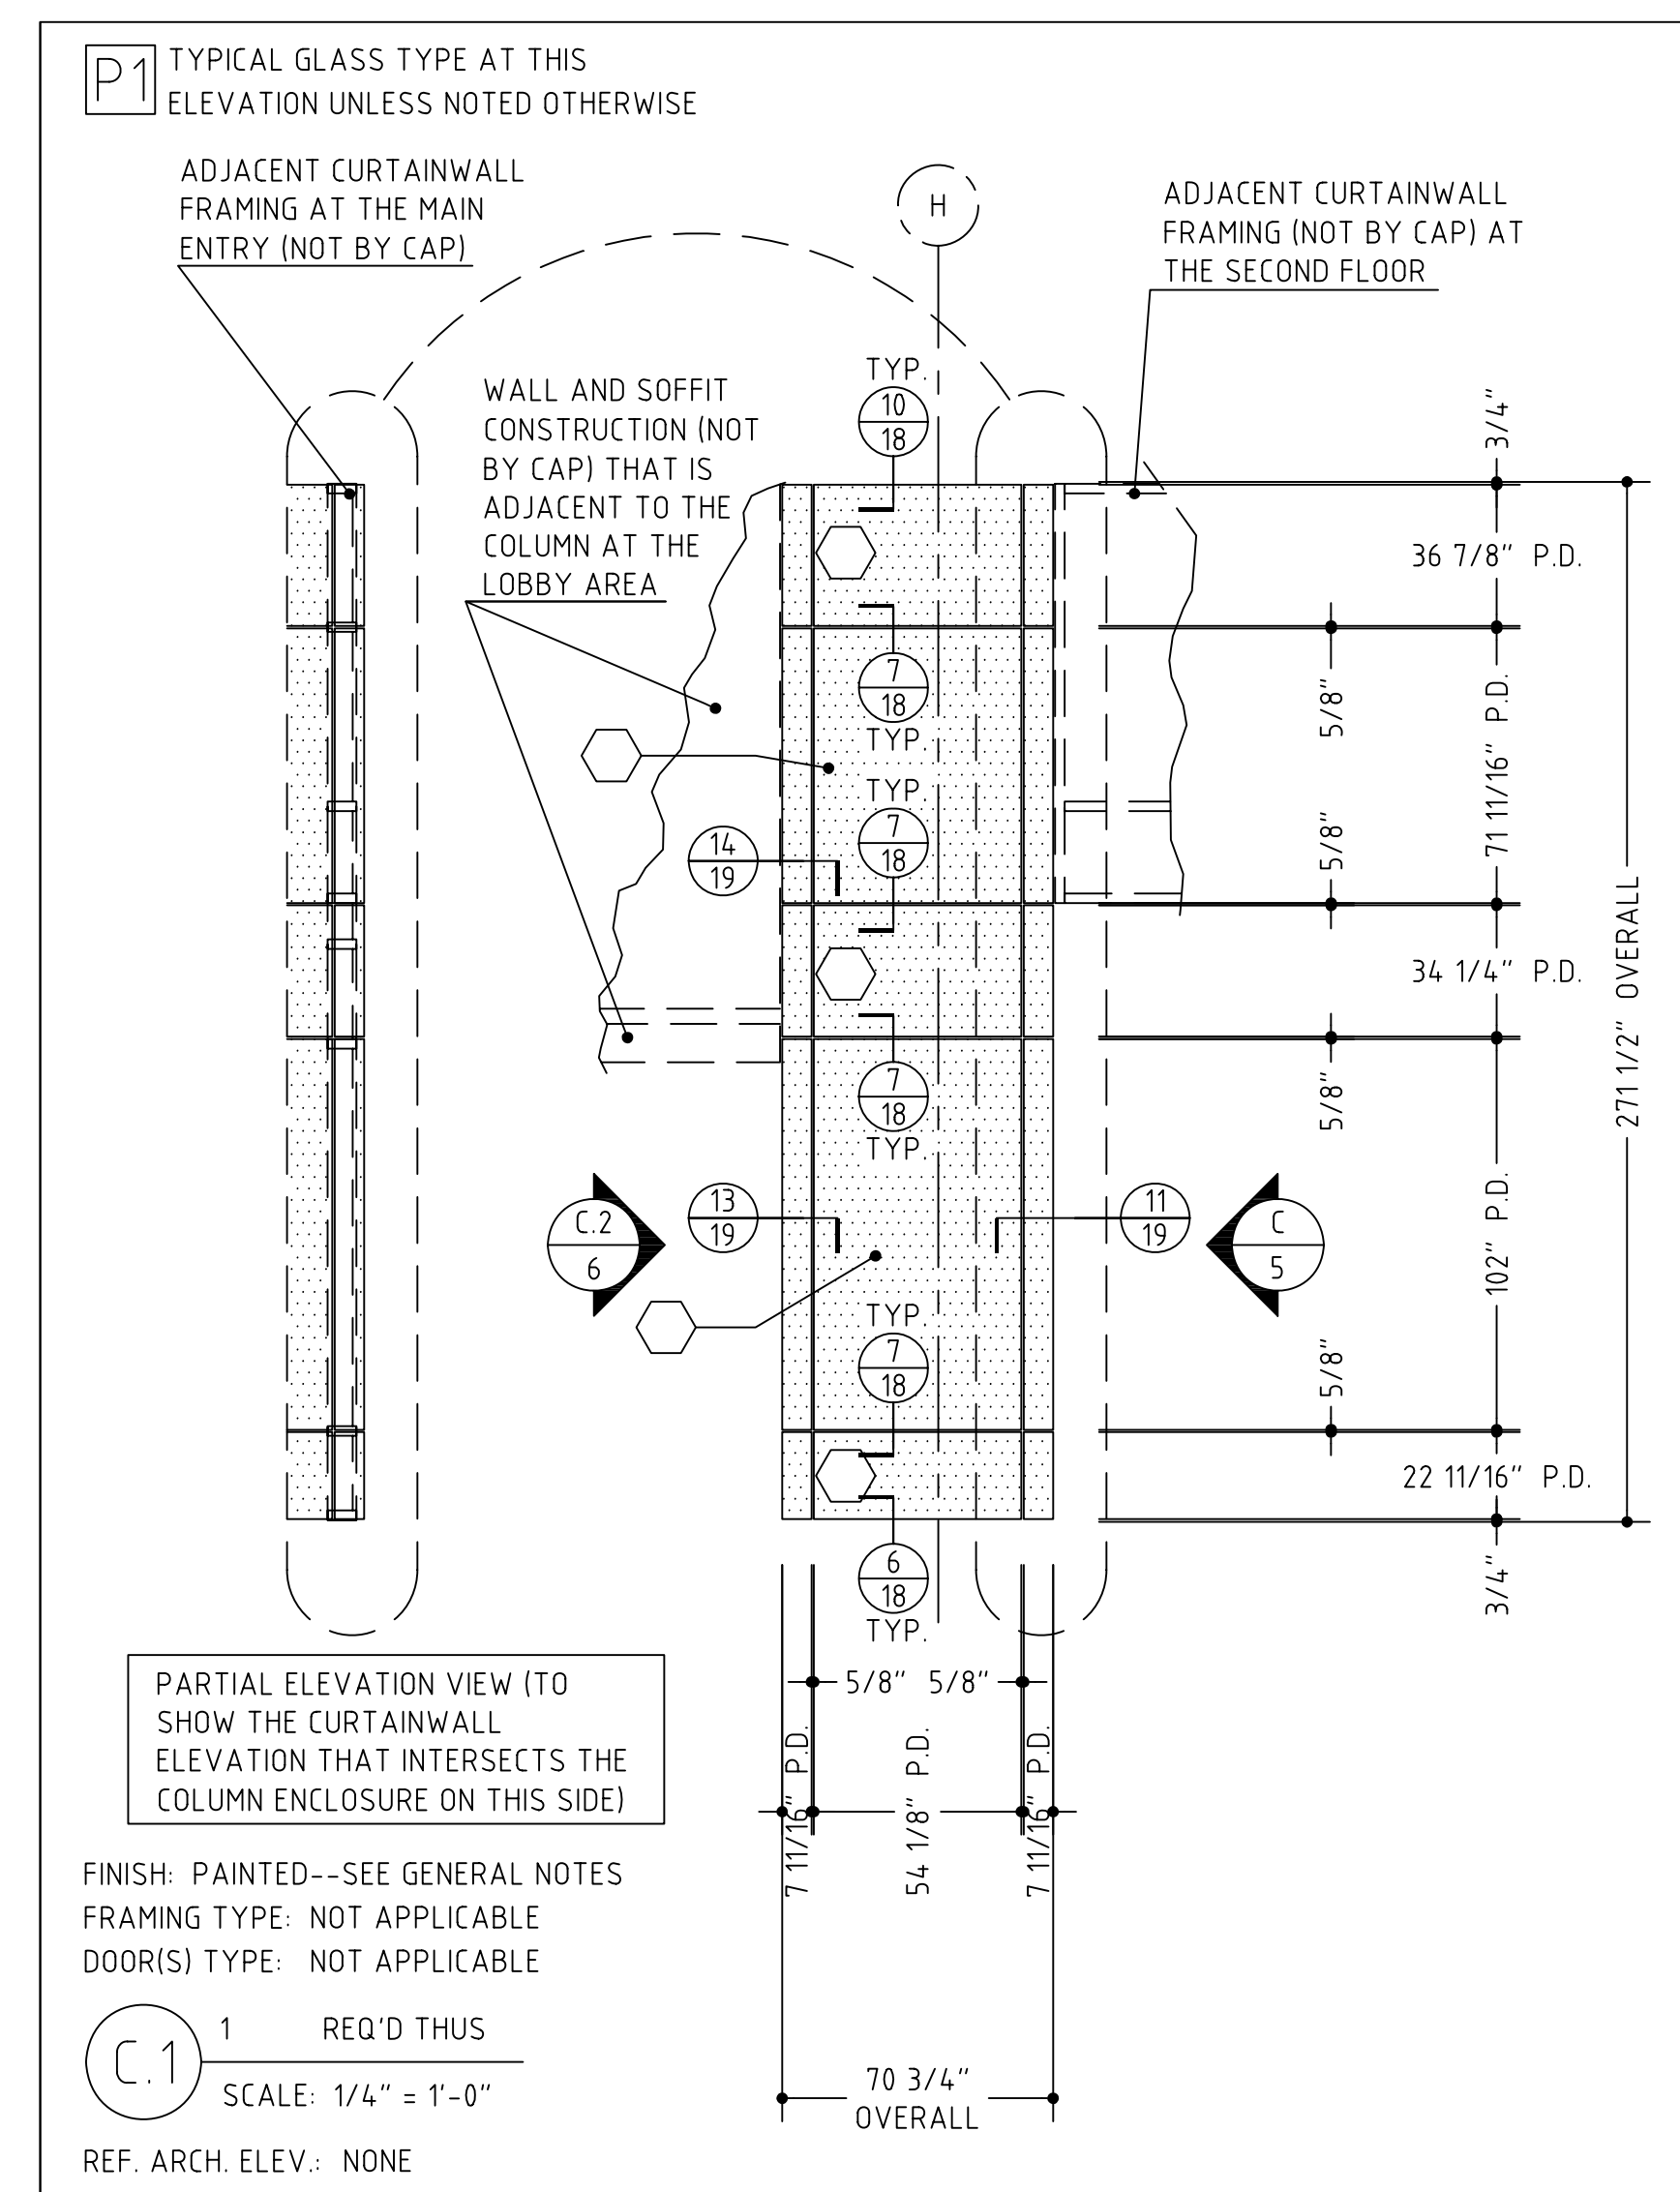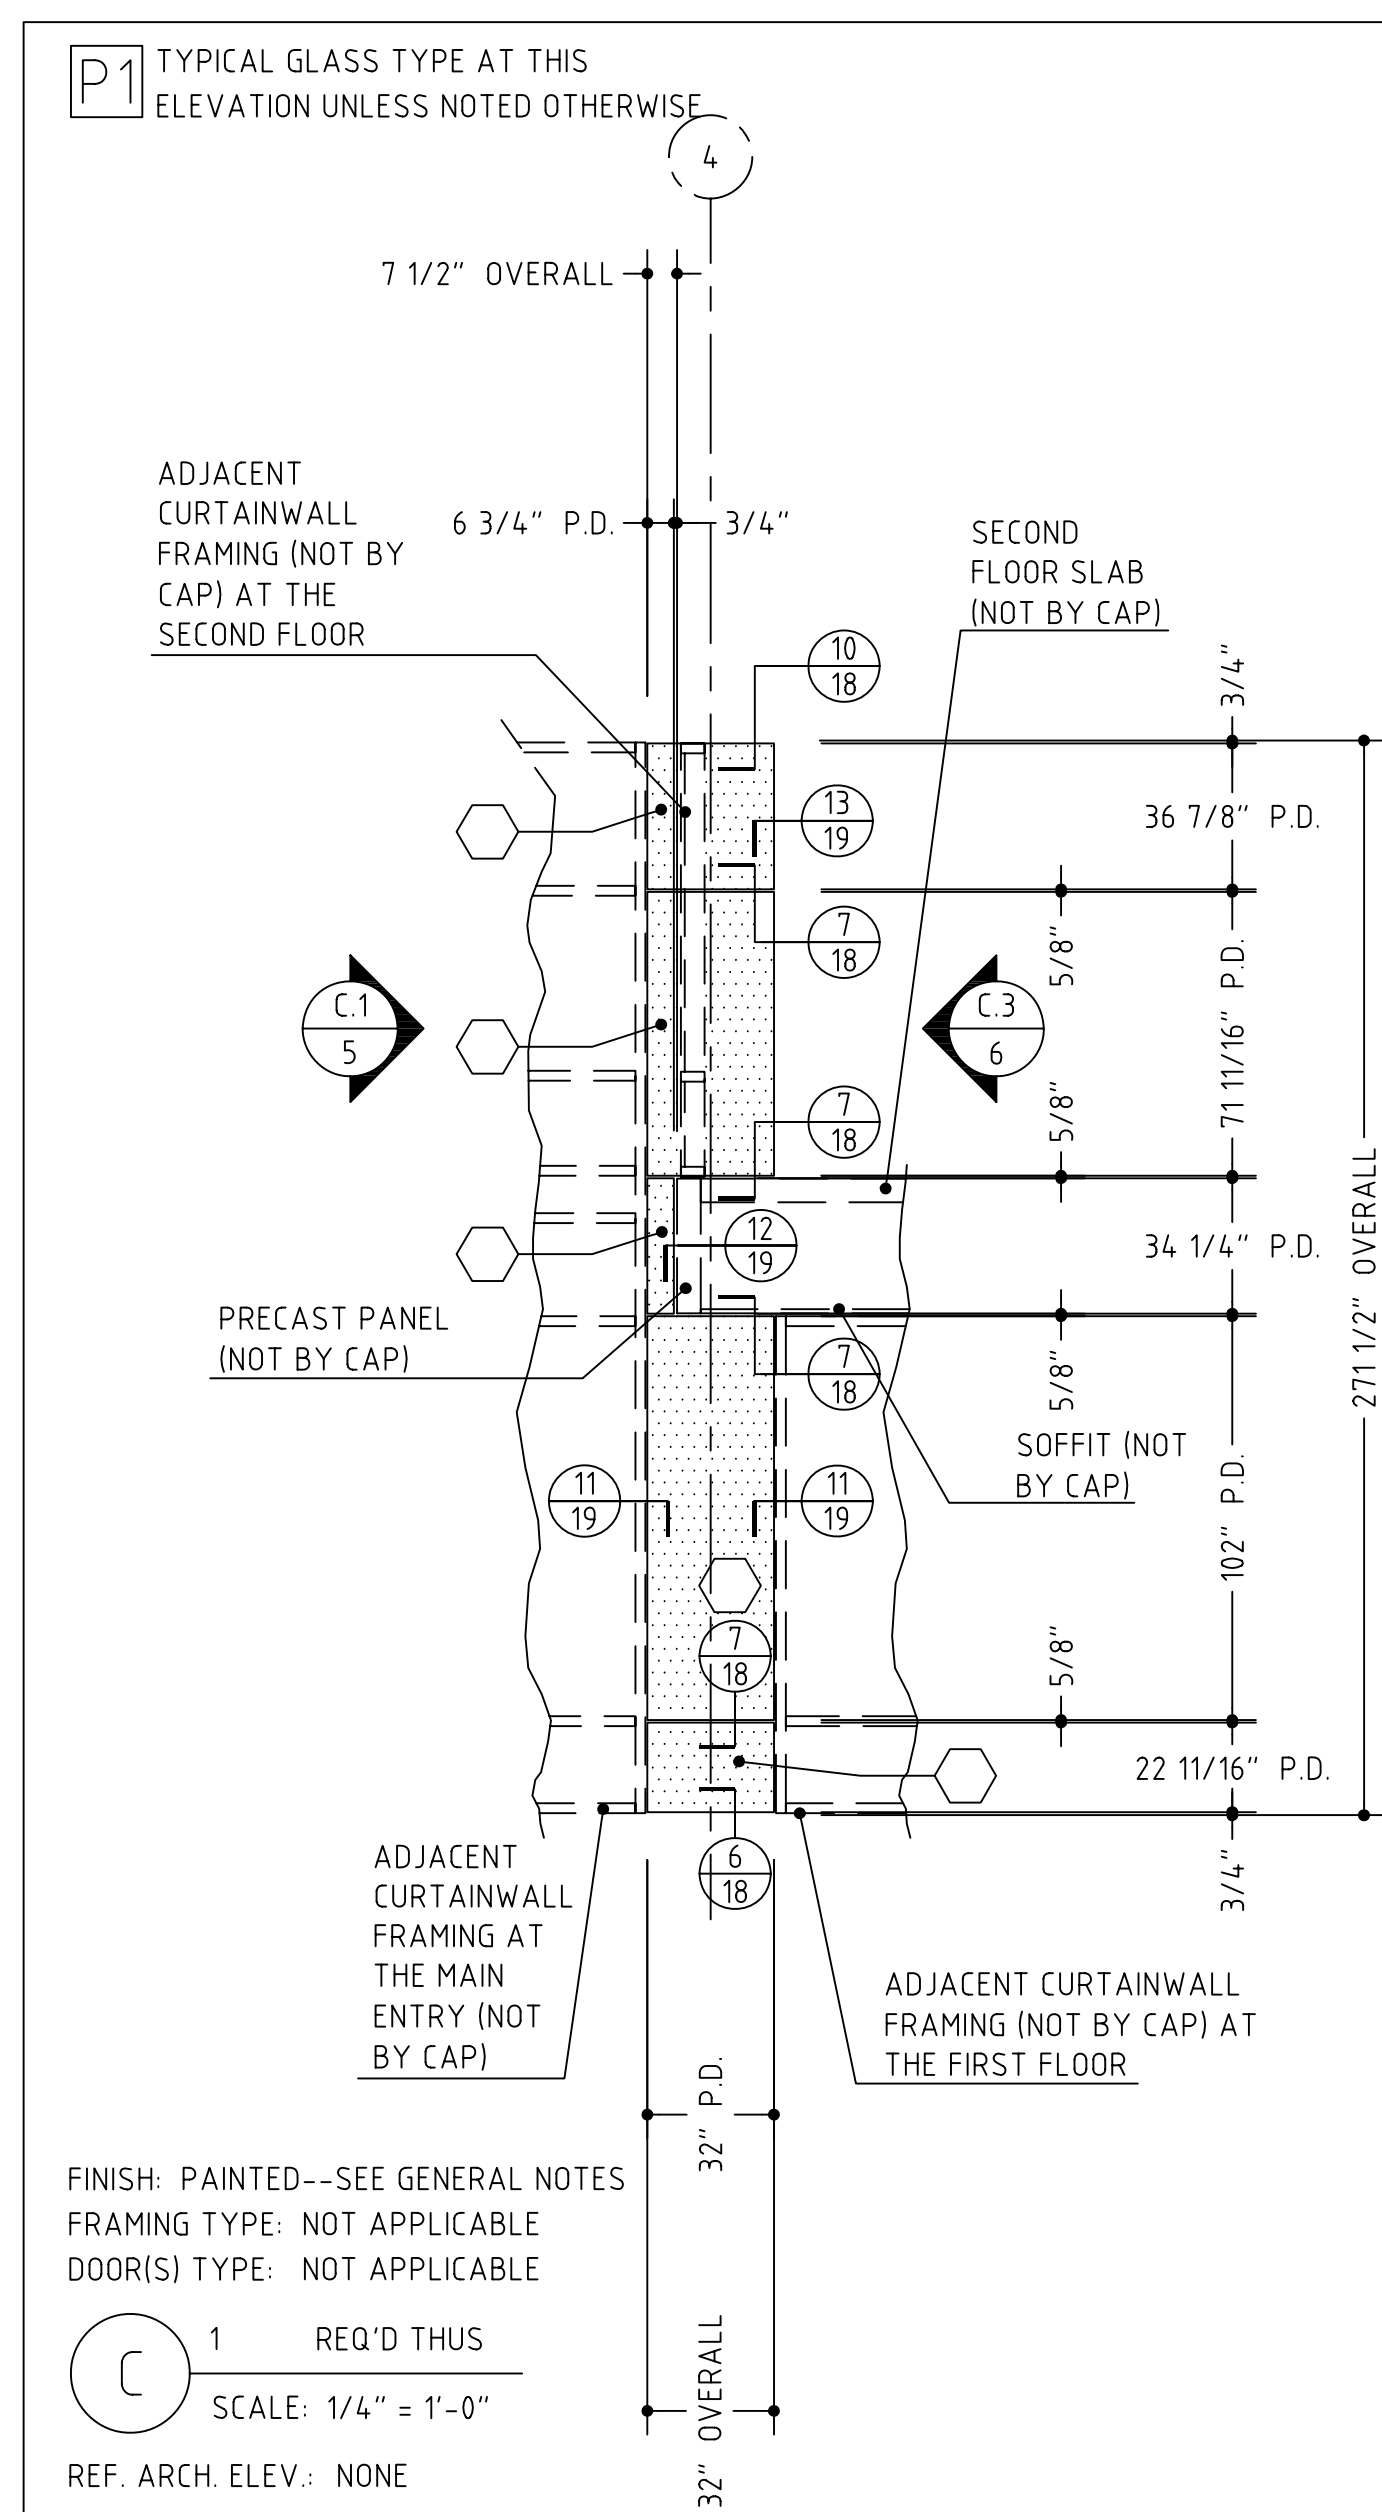

FABRICATION RELEASE:
THE PANEL DIMENSIONS HAVE BEEN REVIEWED AND
APPROVED AS NOTED ON THIS DRAWING. THE
PANELS ARE HEREBY RELEASED FOR FABRICATION.


OPUS CENTER @
ROCKSPRING
PARK, BETHESDA,
MARYLAND

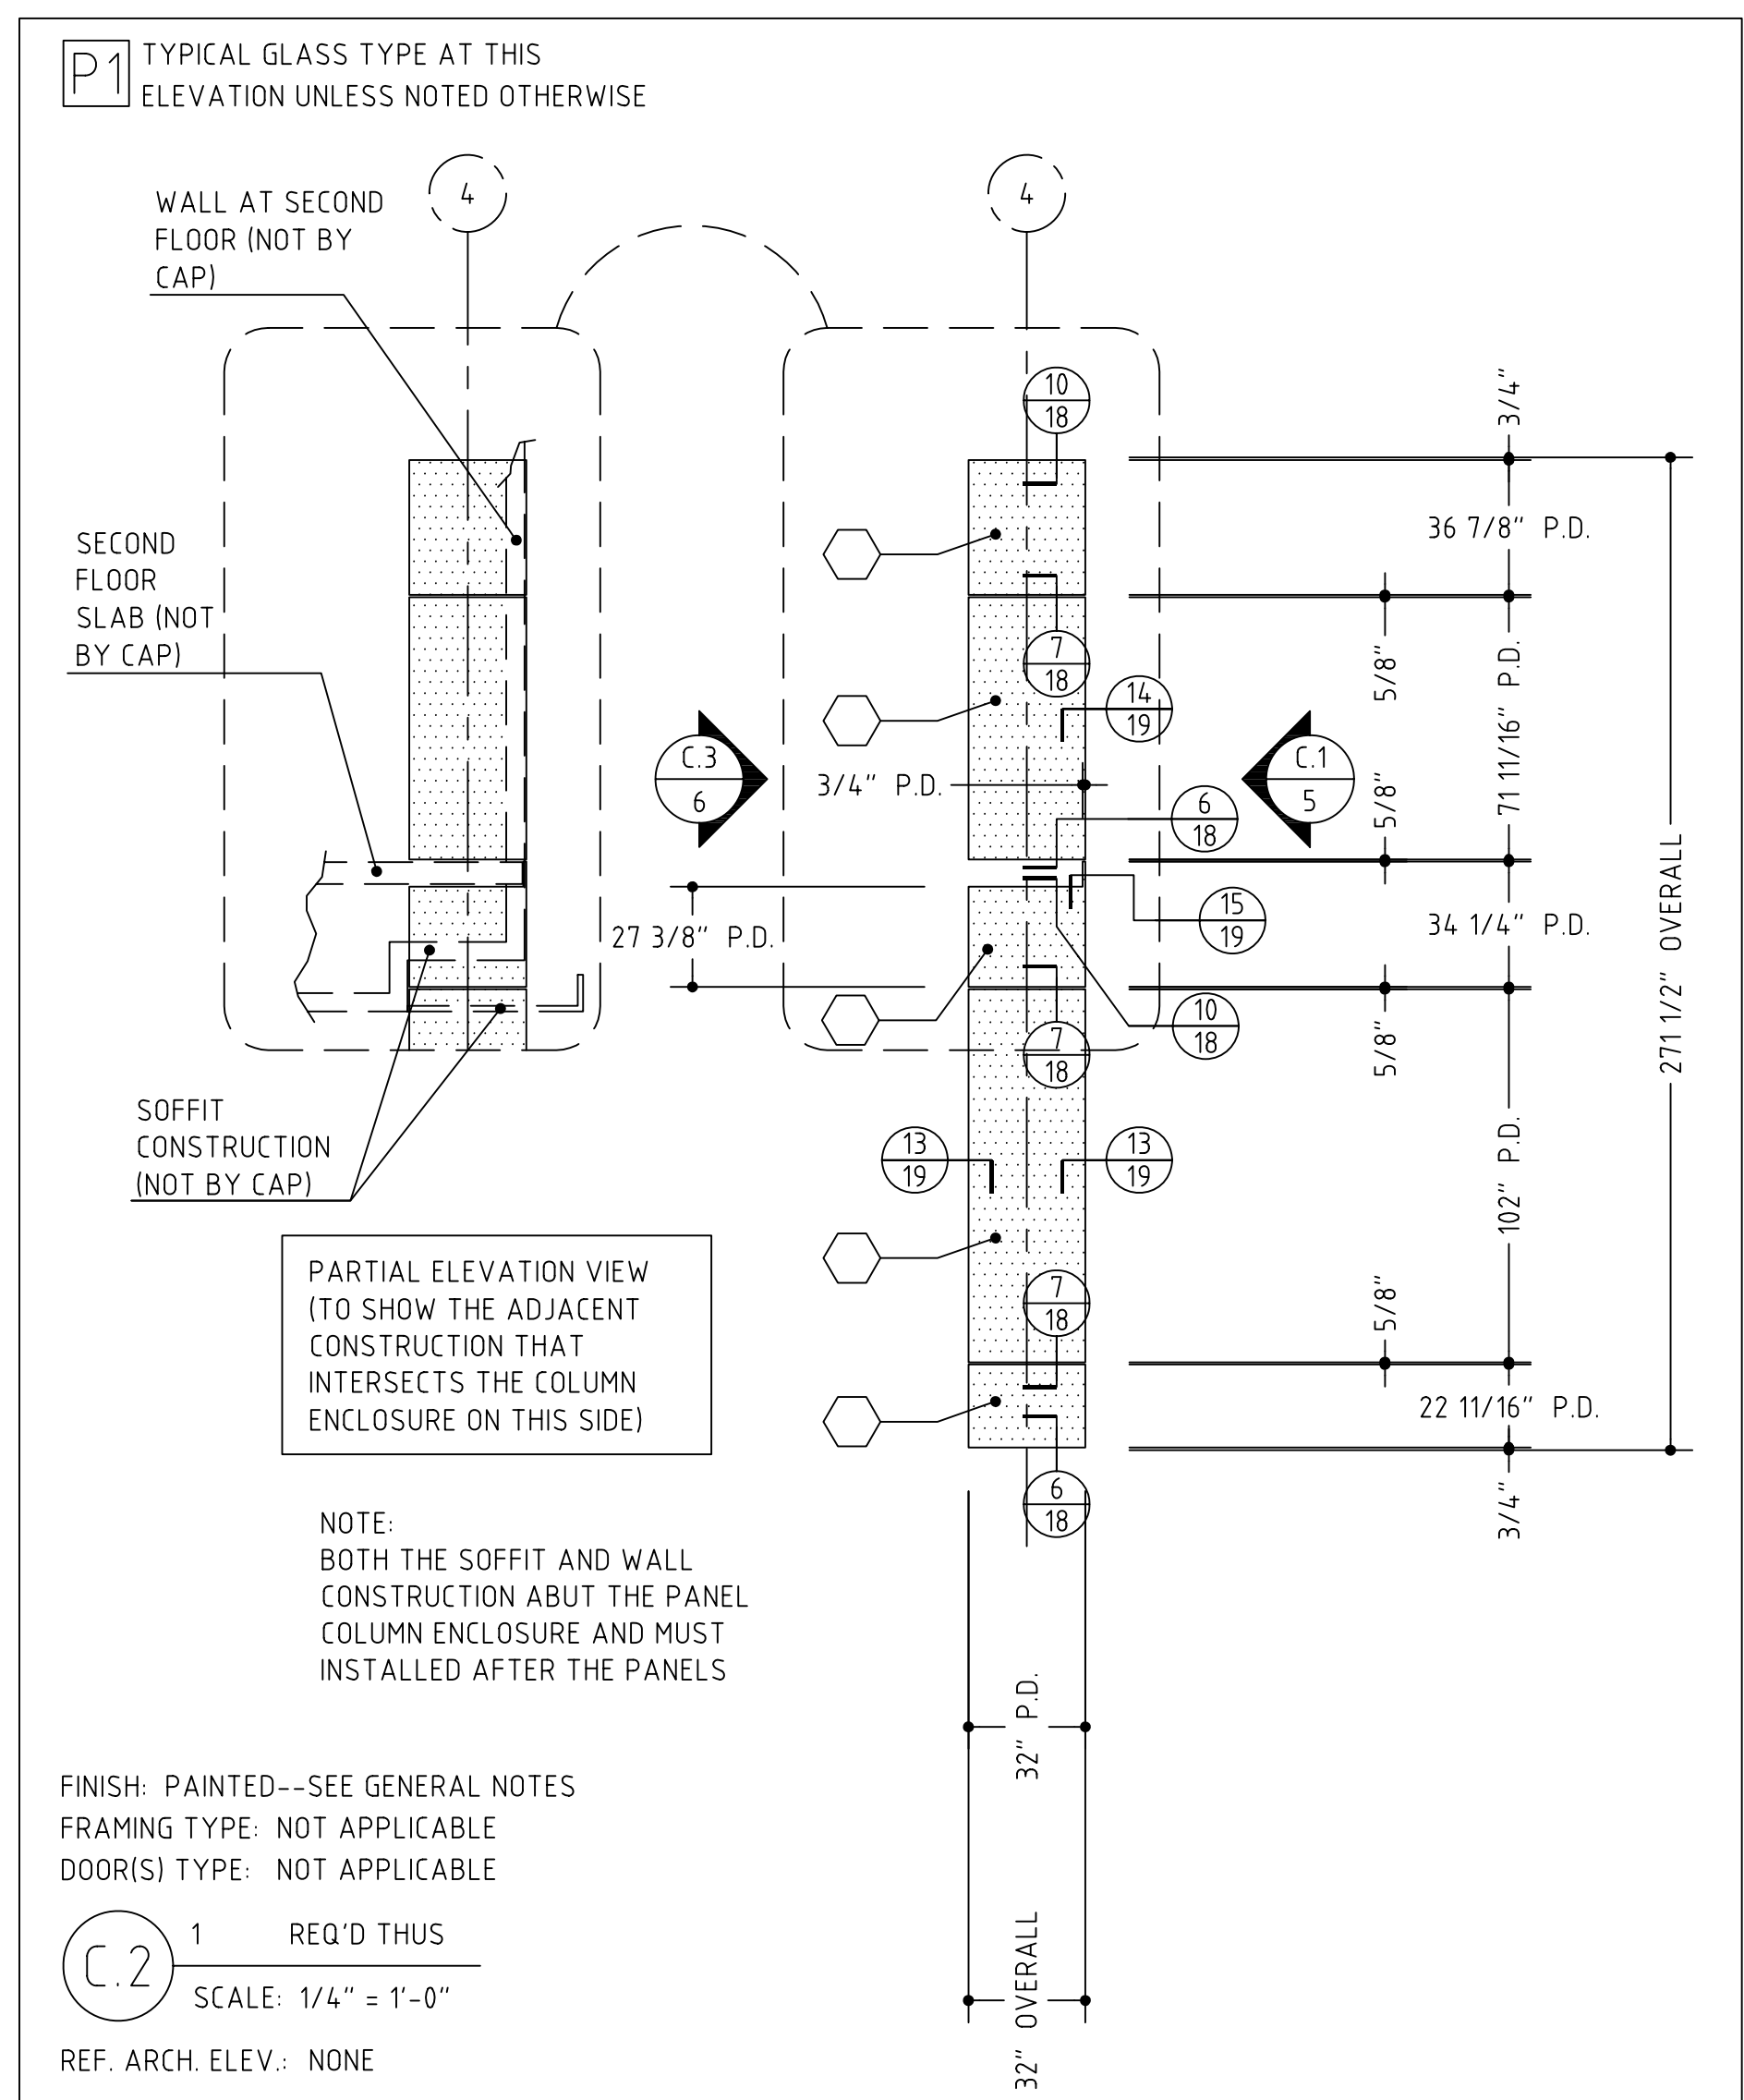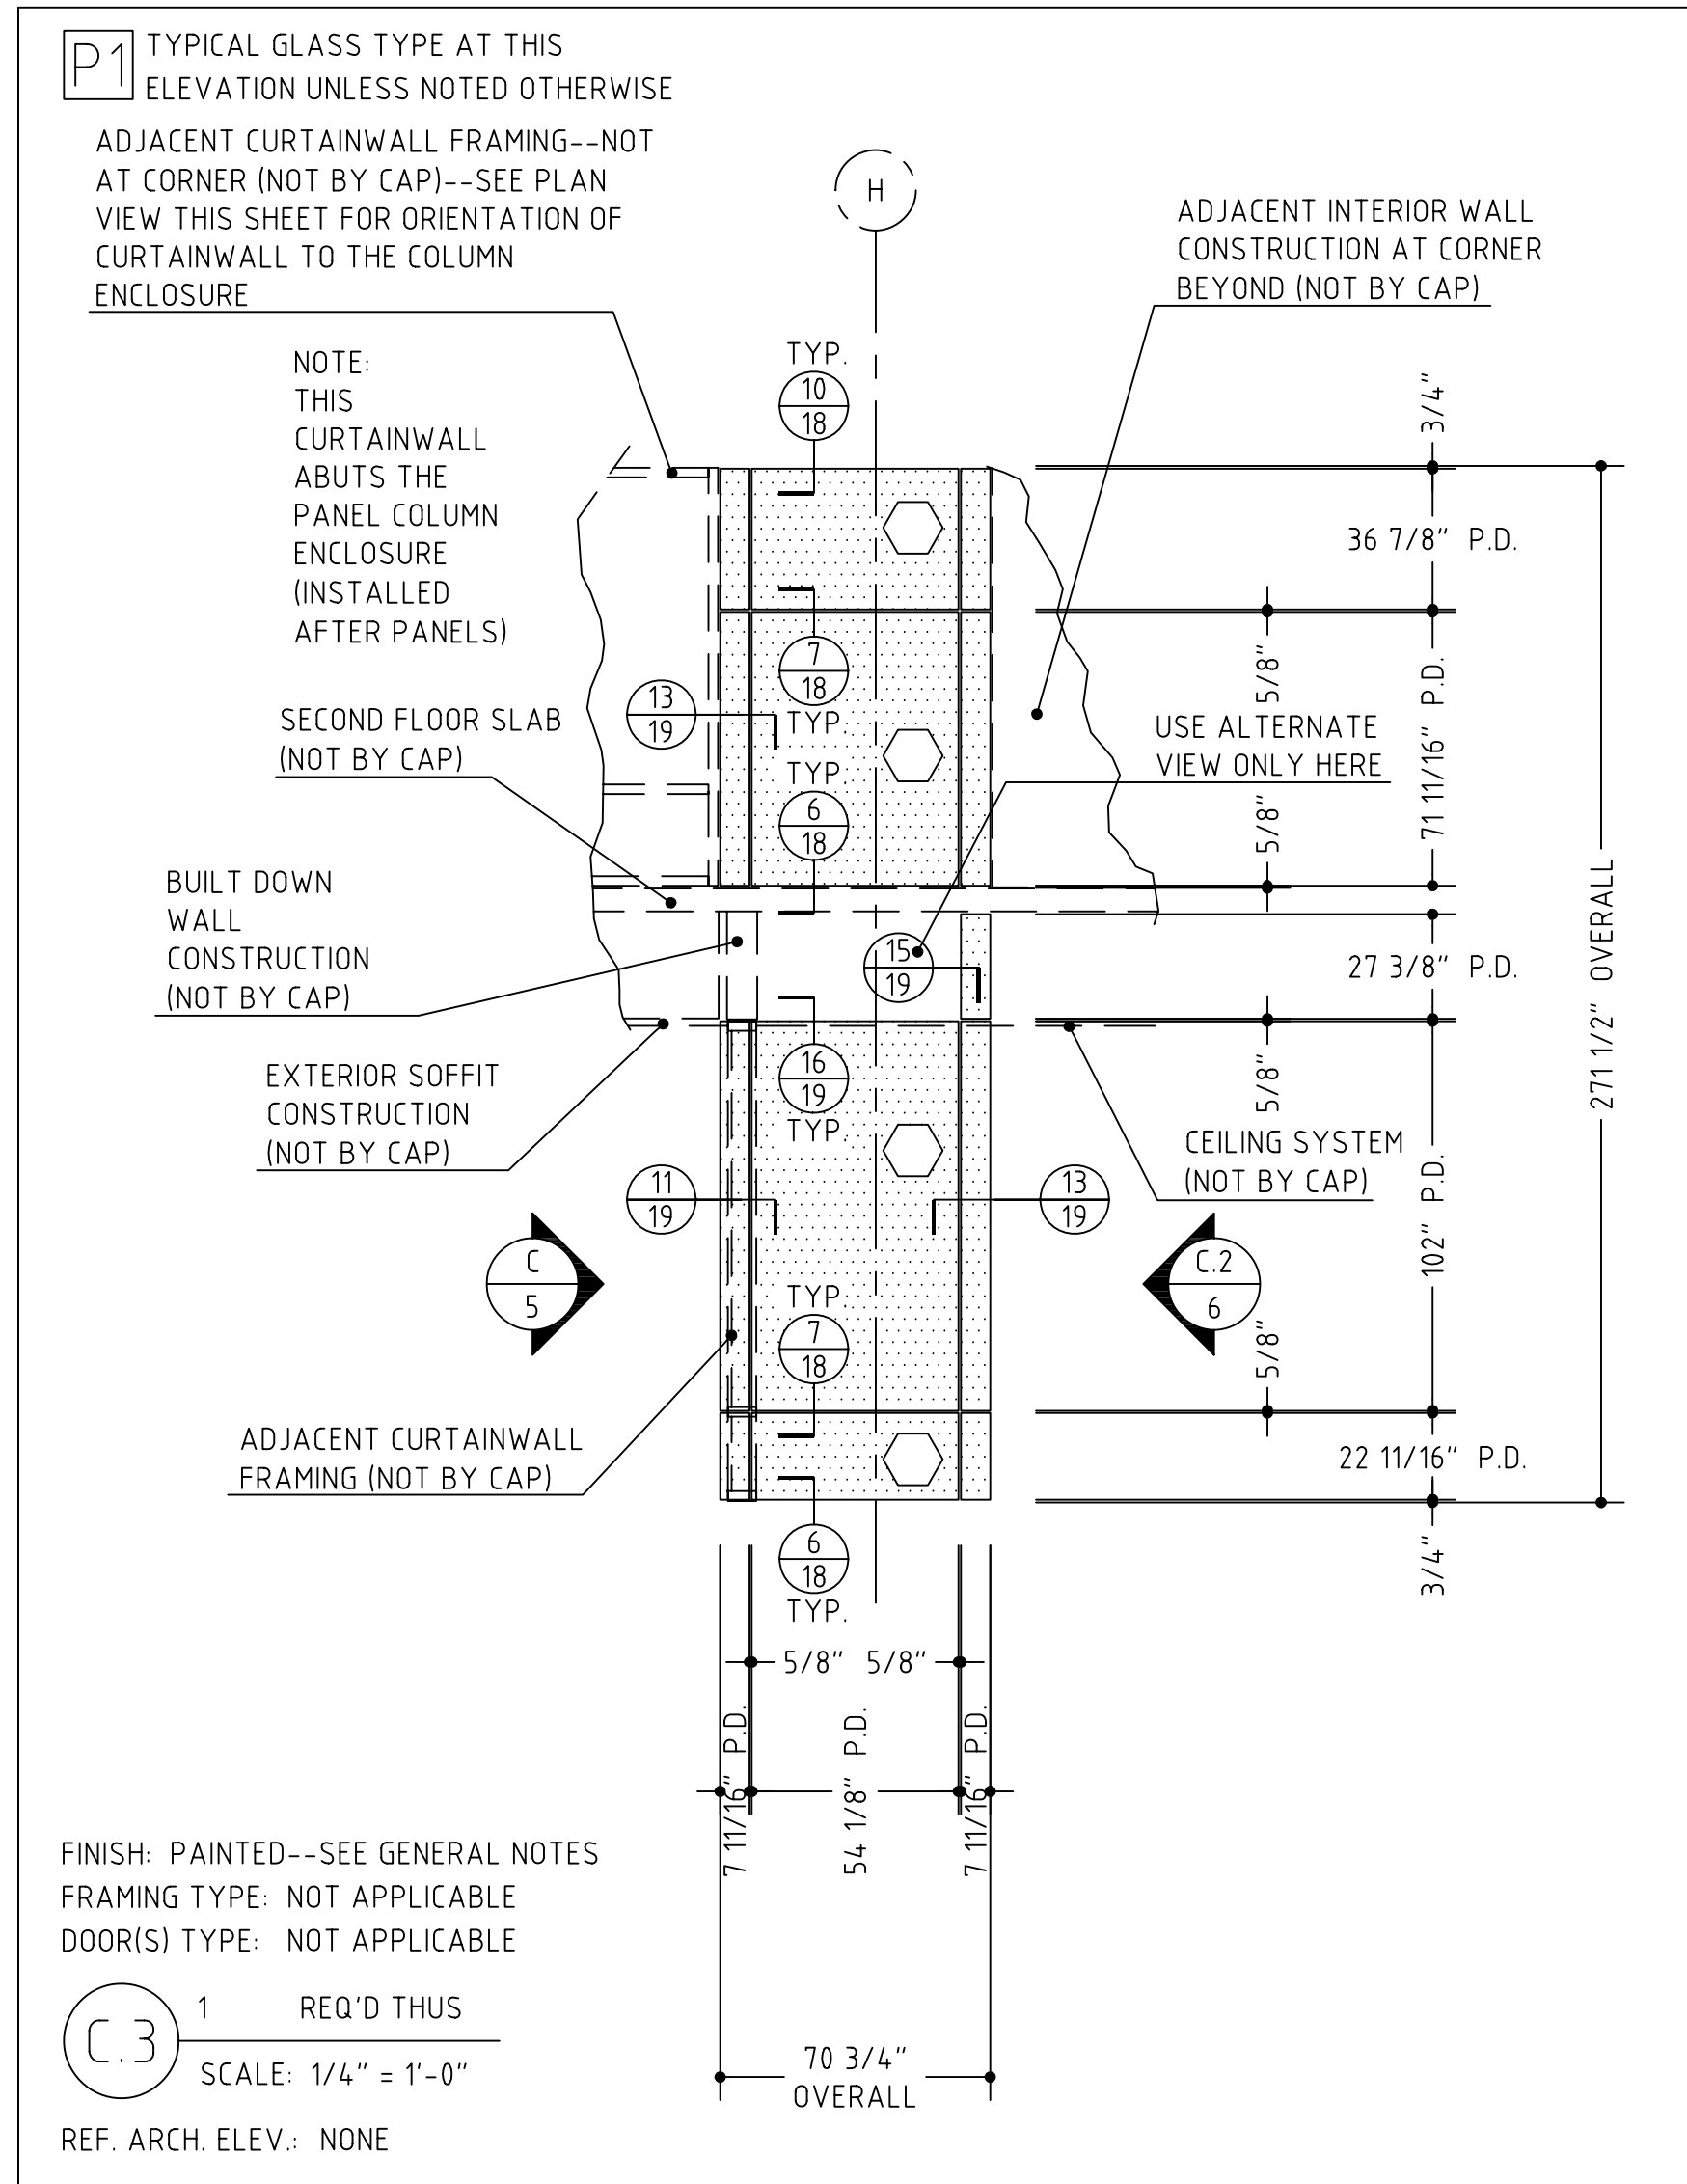

FABRICATION RELEASE:

THE PANEL DIMENSIONS HAVE BEEN REVIEWED AND APPROVED AS NOTED ON THIS DRAWING. THE PANELS ARE HEREBY RELEASED FOR FABRICATION.

VERIFY ALL DIMENSIONS

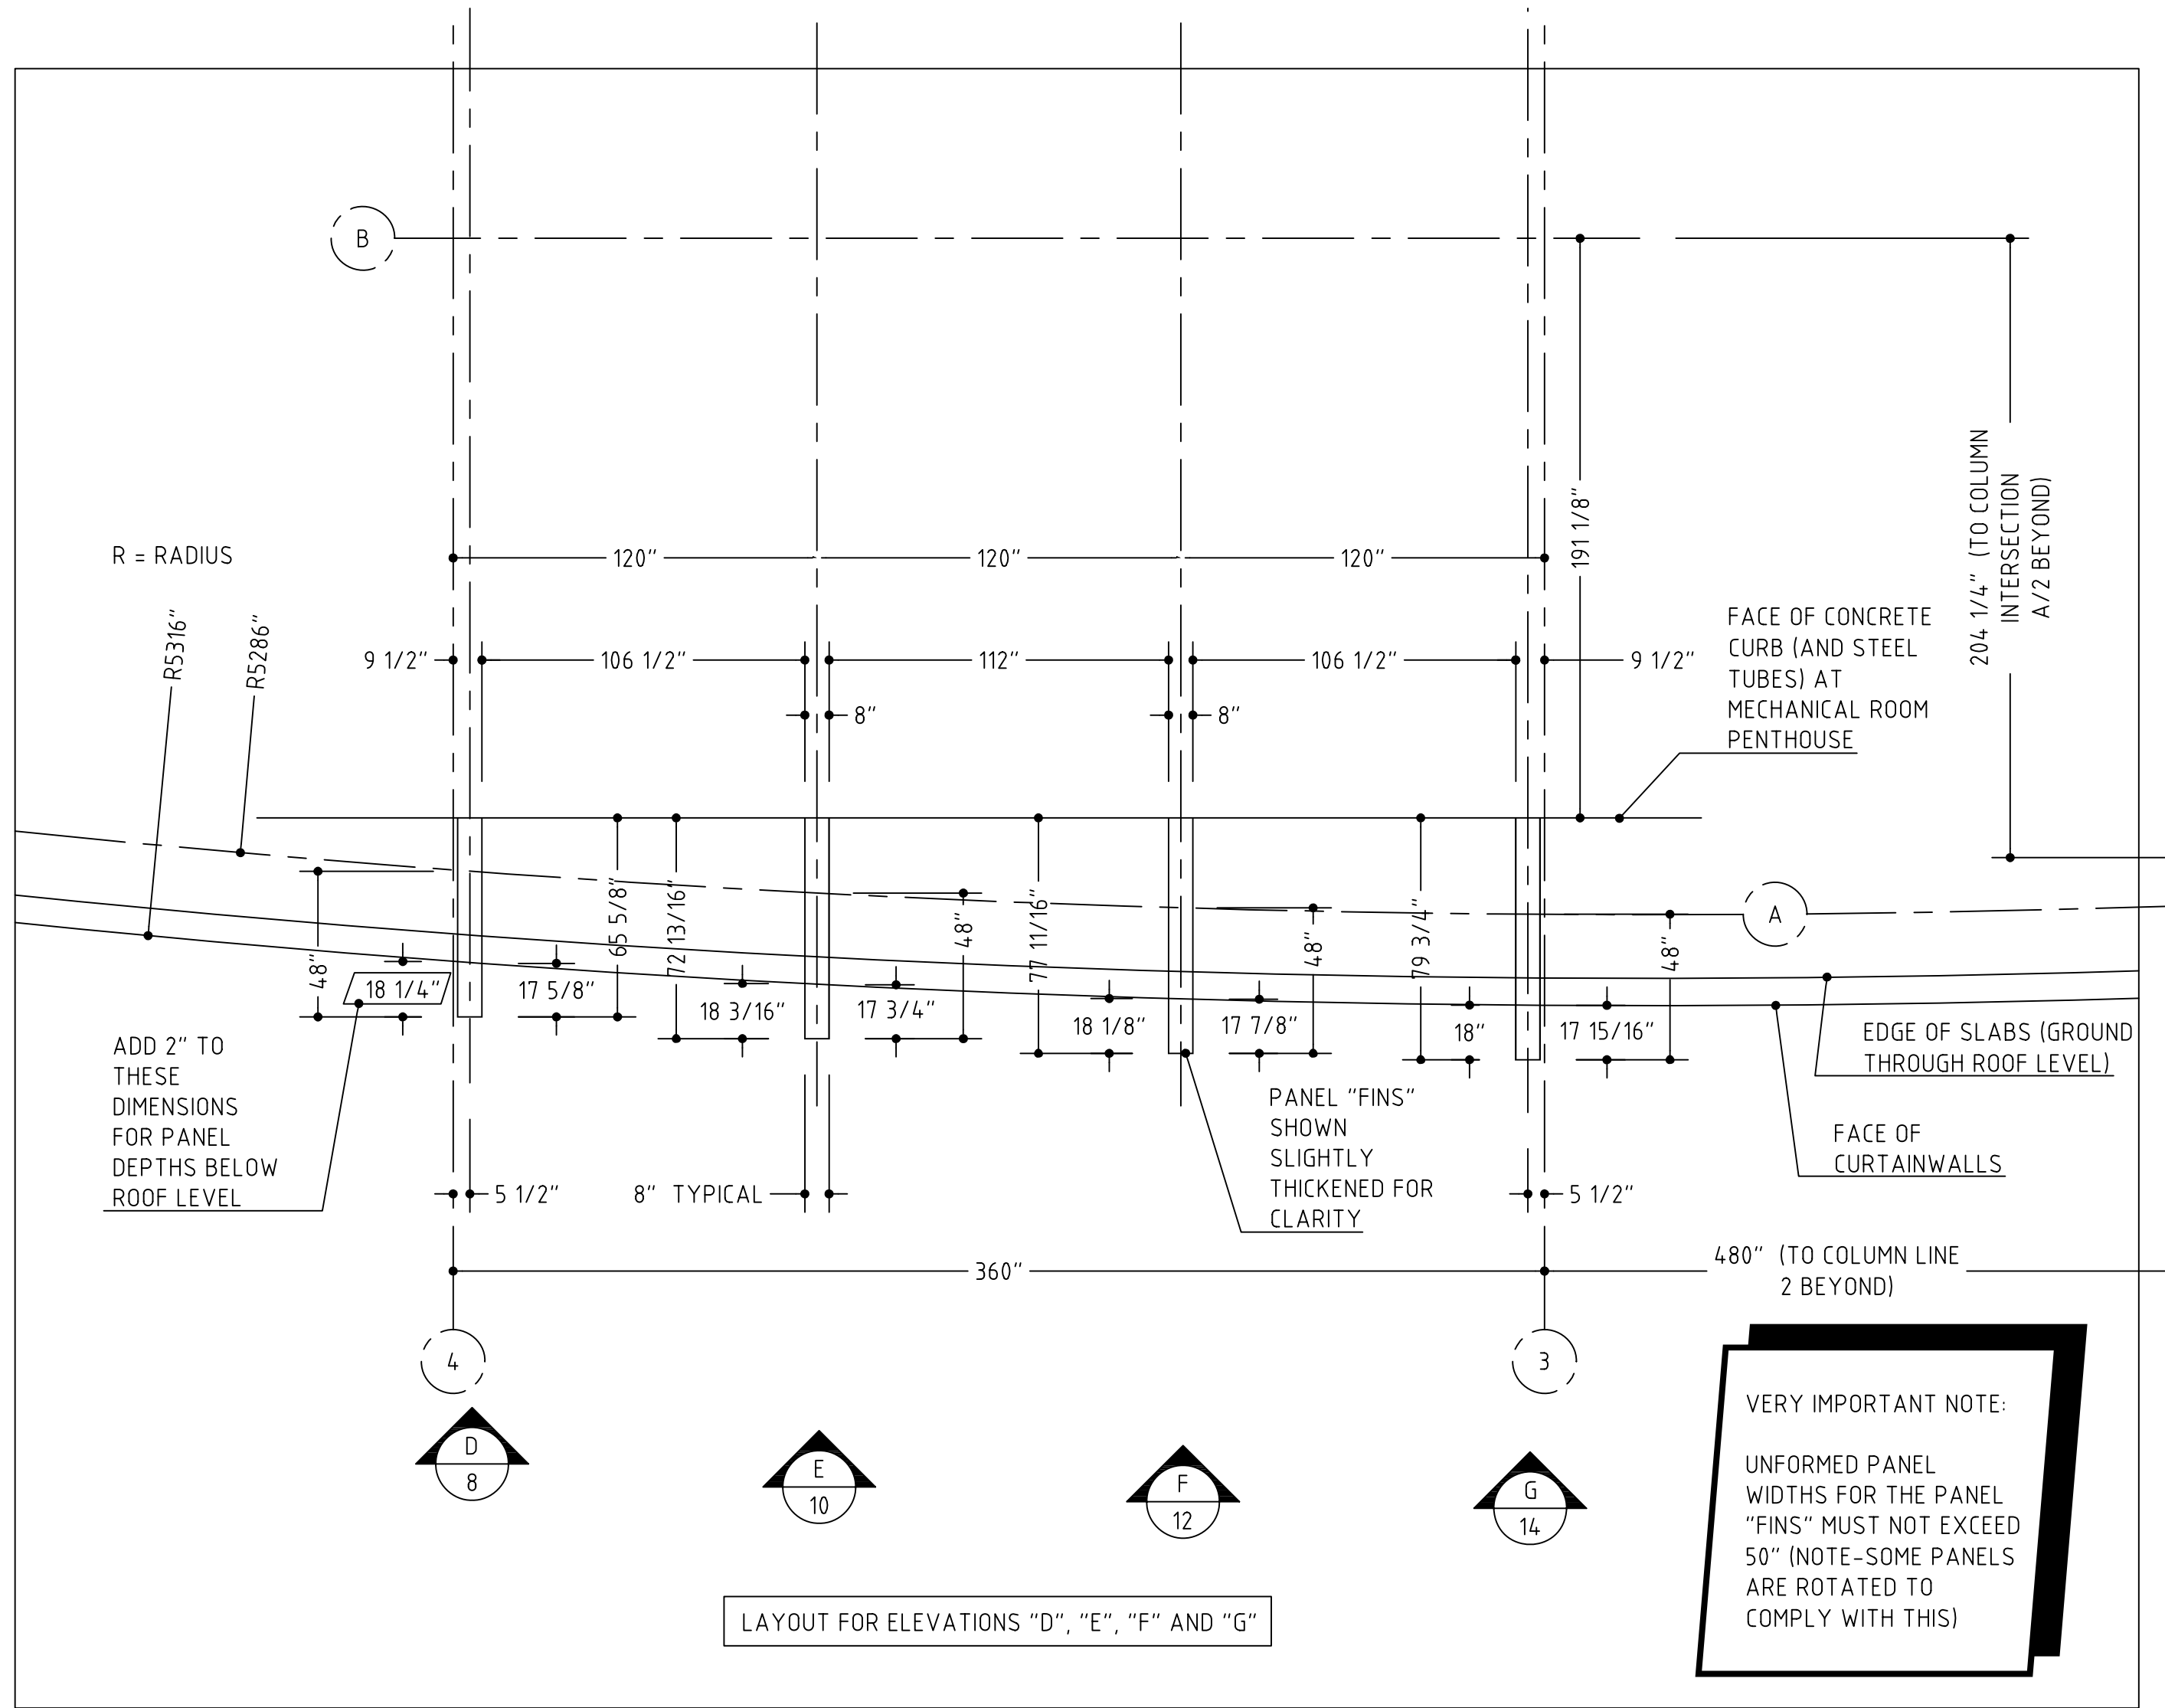

FABRICATION RELEASE:

THE PANEL DIMENSIONS HAVE BEEN REVIEWED AND APPROVED AS NOTED ON THIS DRAWING. THE PANELS ARE HEREBY RELEASED FOR FABRICATION.

VERY IMPORTANT NOTE:


UNFORMED PANEL
WIDTHS FOR THE PANEL
"FINS" MUST NOT EXCEED
50" (NOTE-SOME PANELS
ARE ROTATED TO
COMPLY WITH THIS)


LAYOUT FOR ELEVATIONS "D", "E", "F" AND "G"


OPUS CENTER @
ROCKSPRING
PARK, BETHESDA,
MARYLAND
SHEET #:




FABRICATION RELEASE:
THE PANEL DIMENSIONS HAVE BEEN REVIEWED AND
APPROVED AS NOTED ON THIS DRAWING. THE
PANELS ARE HEREBY RELEASED FOR FABRICATION.

8

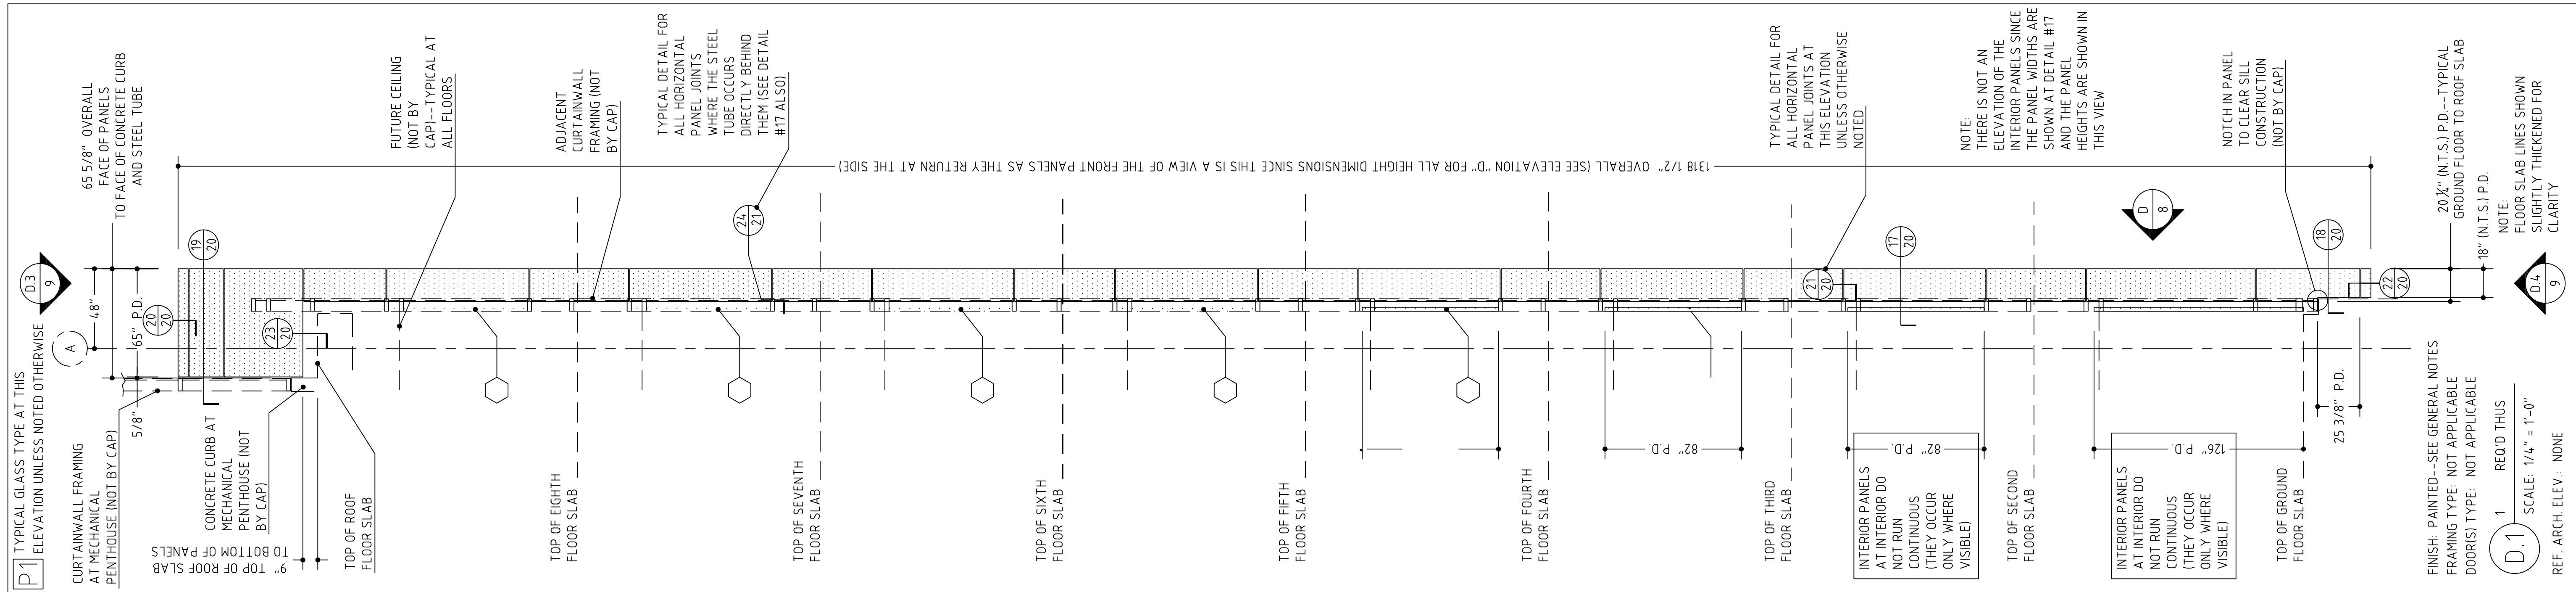

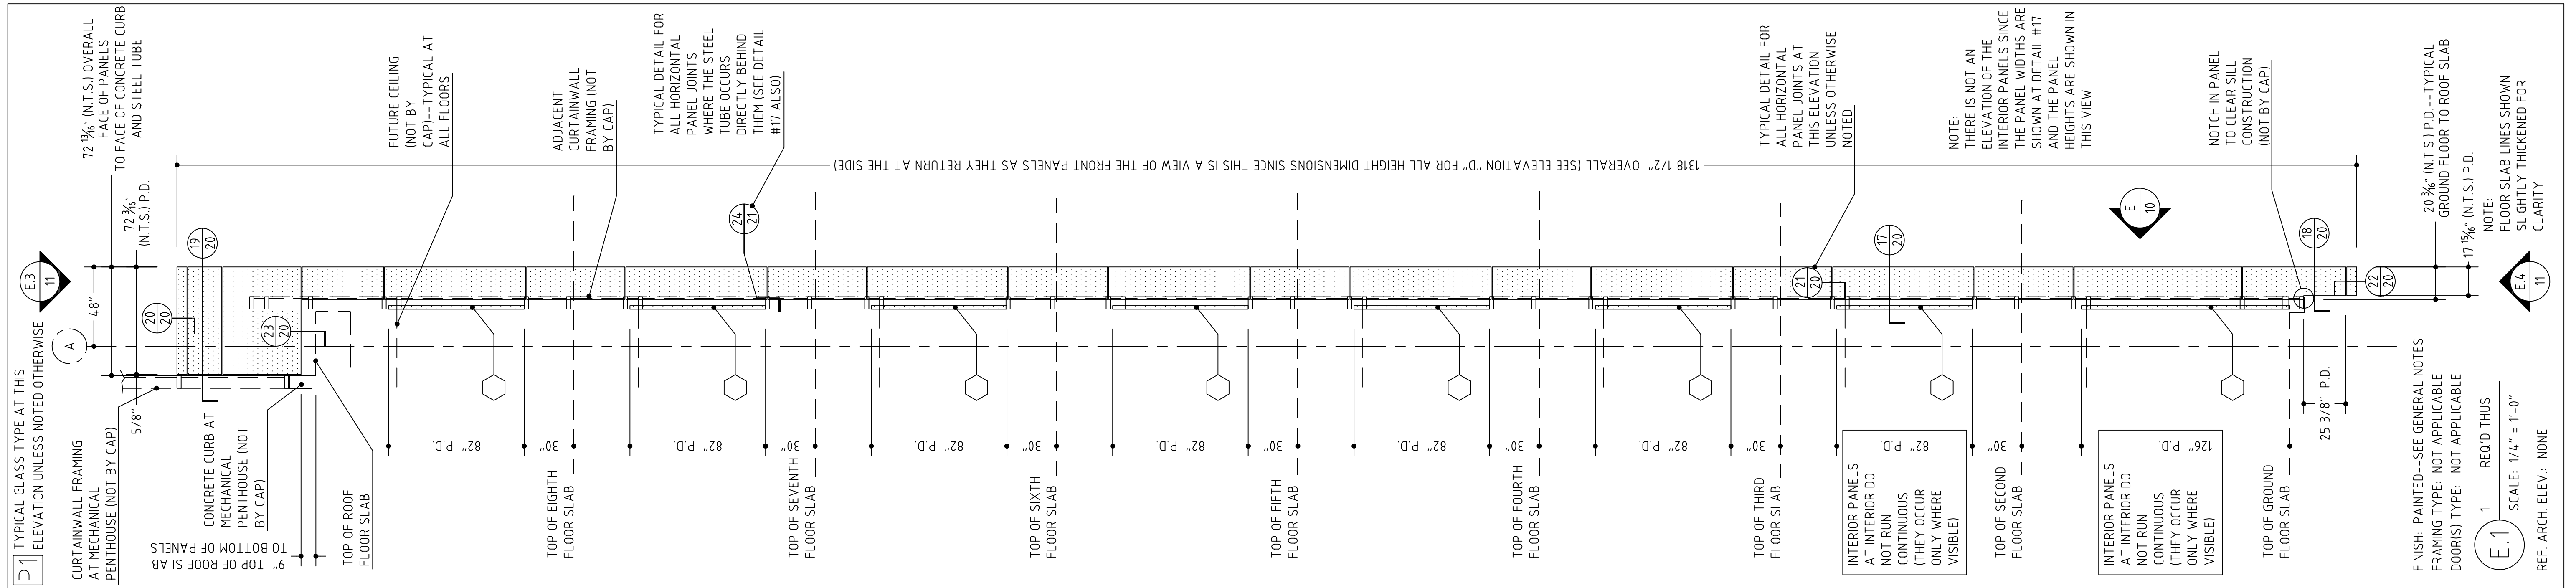




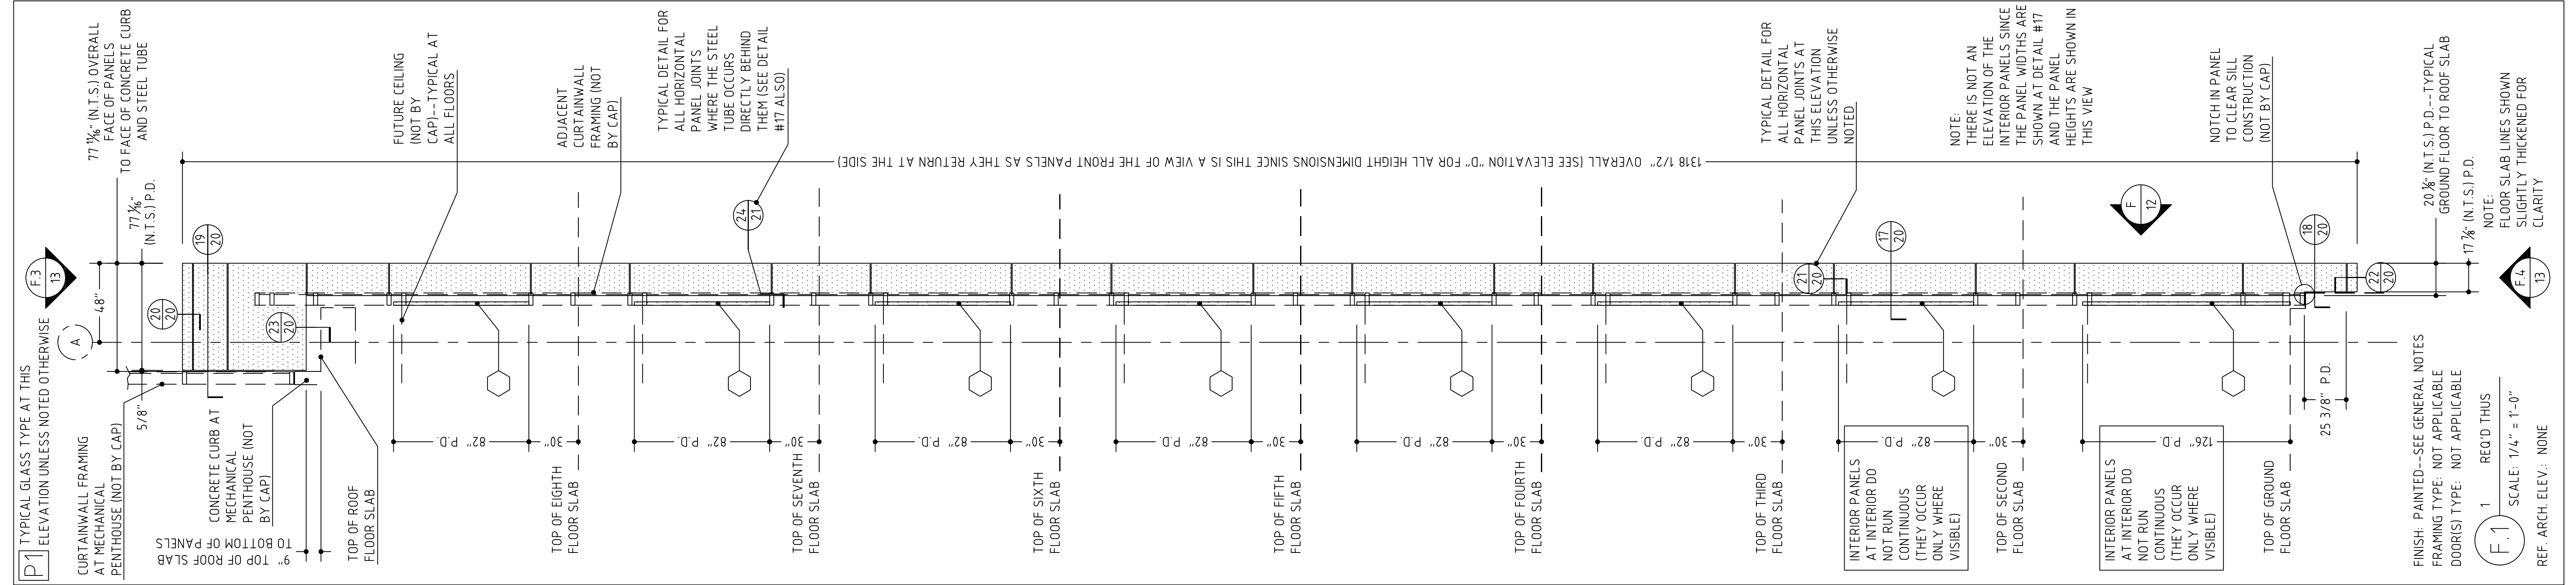


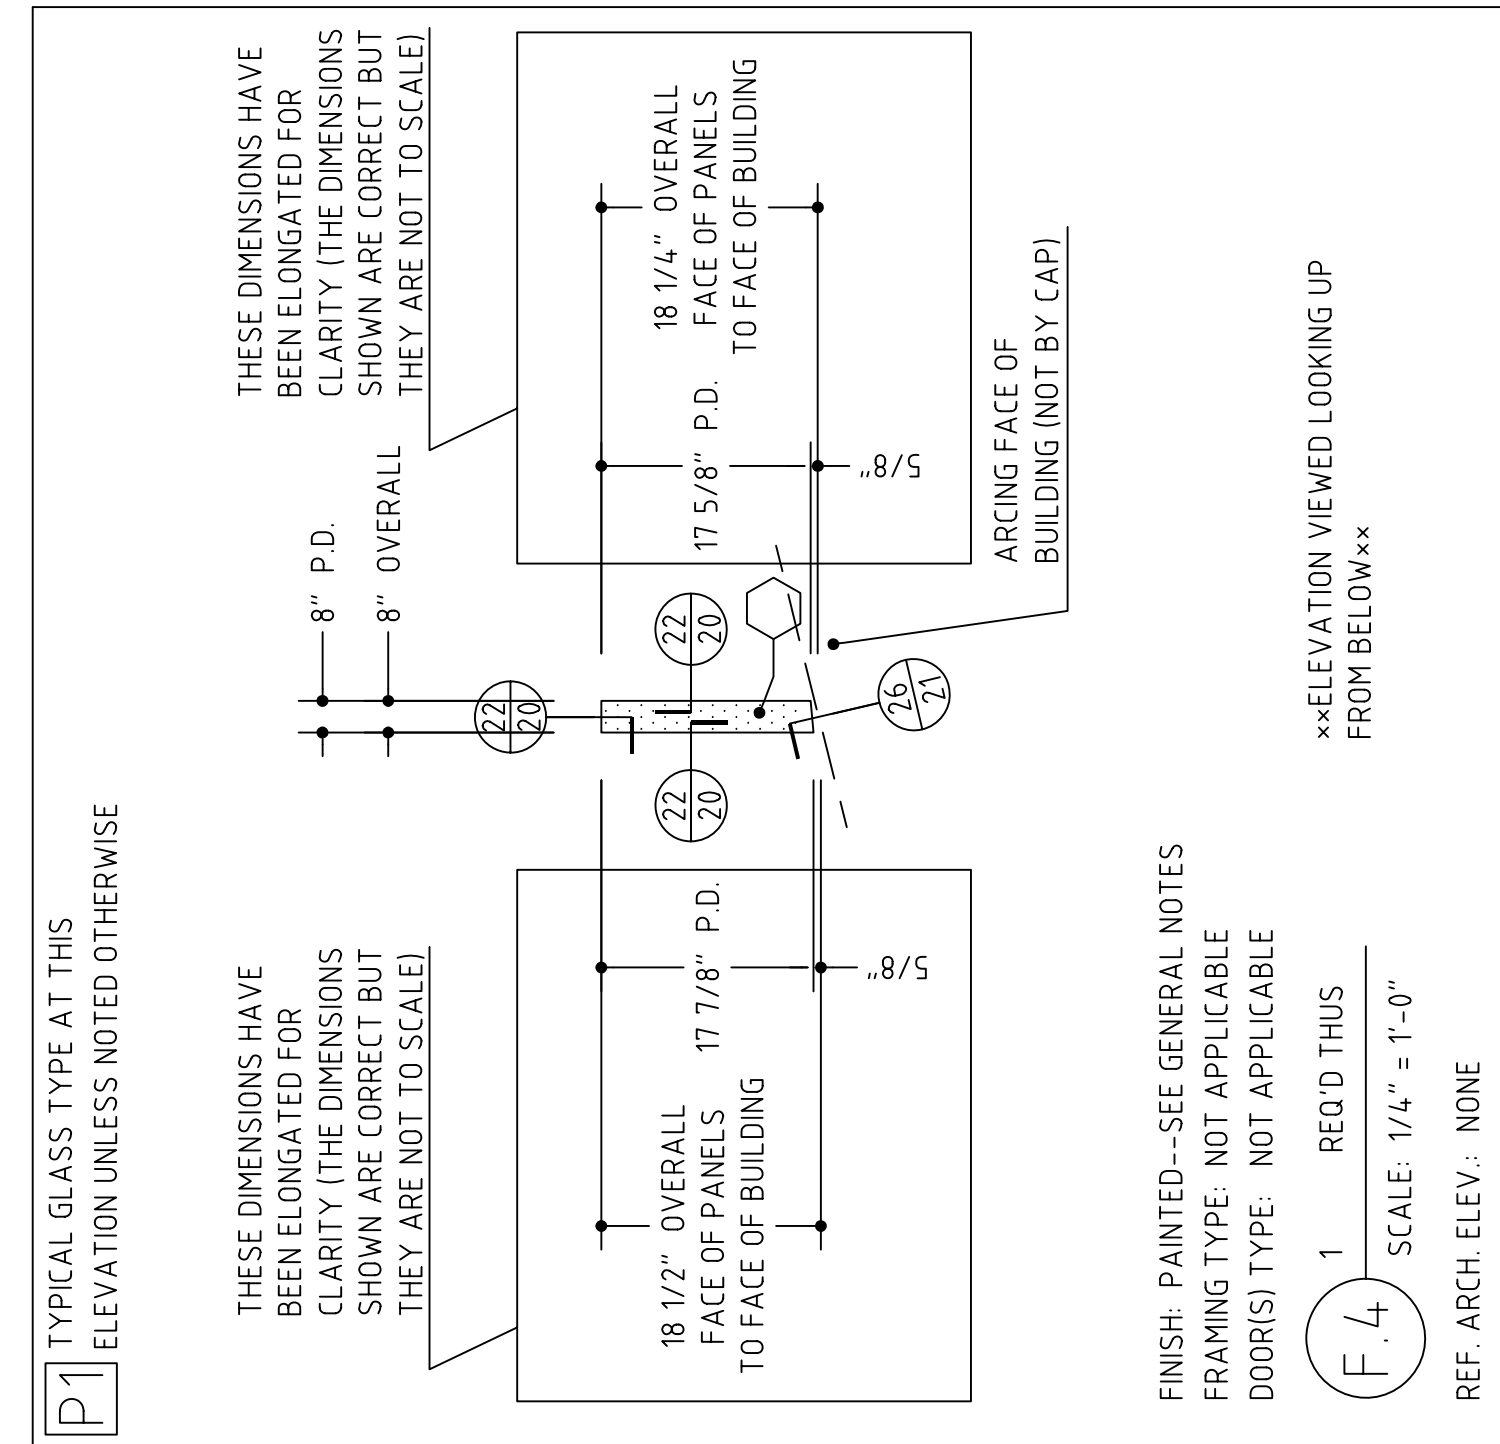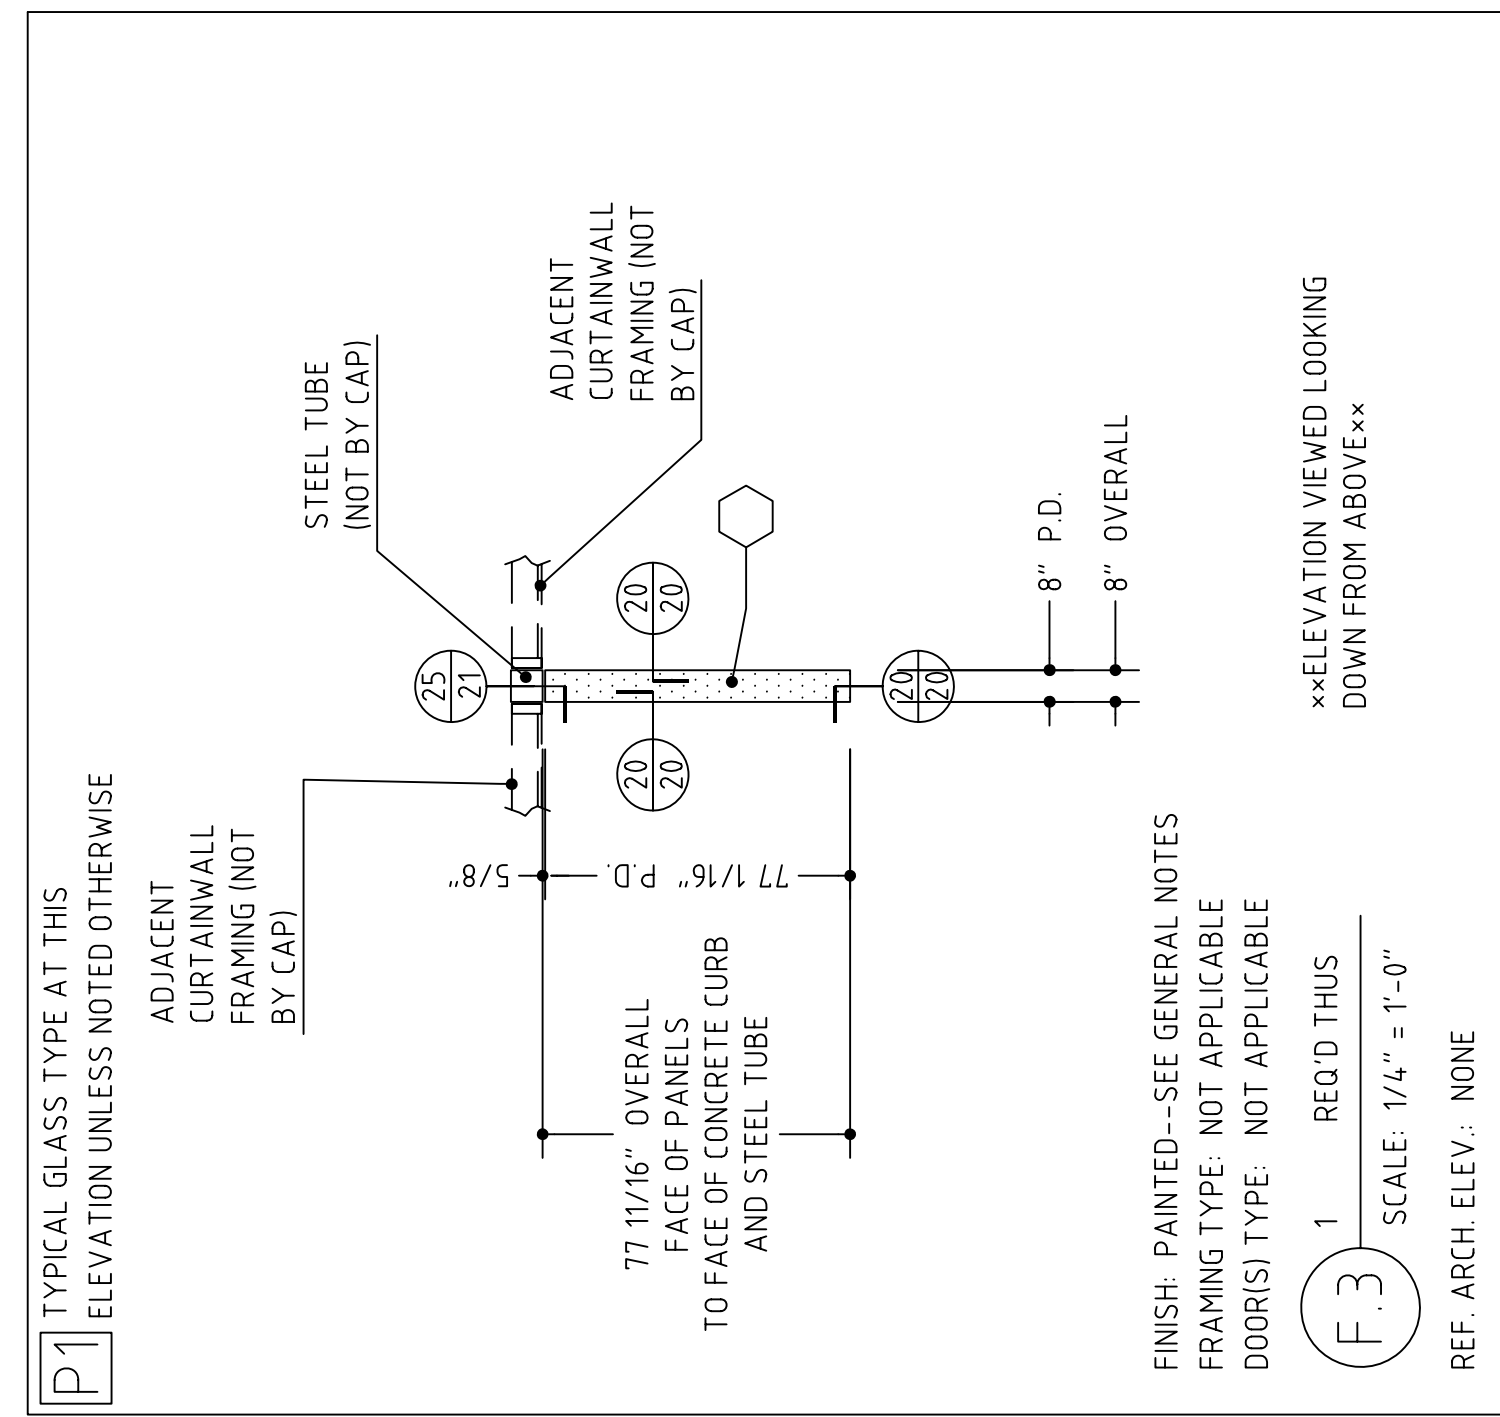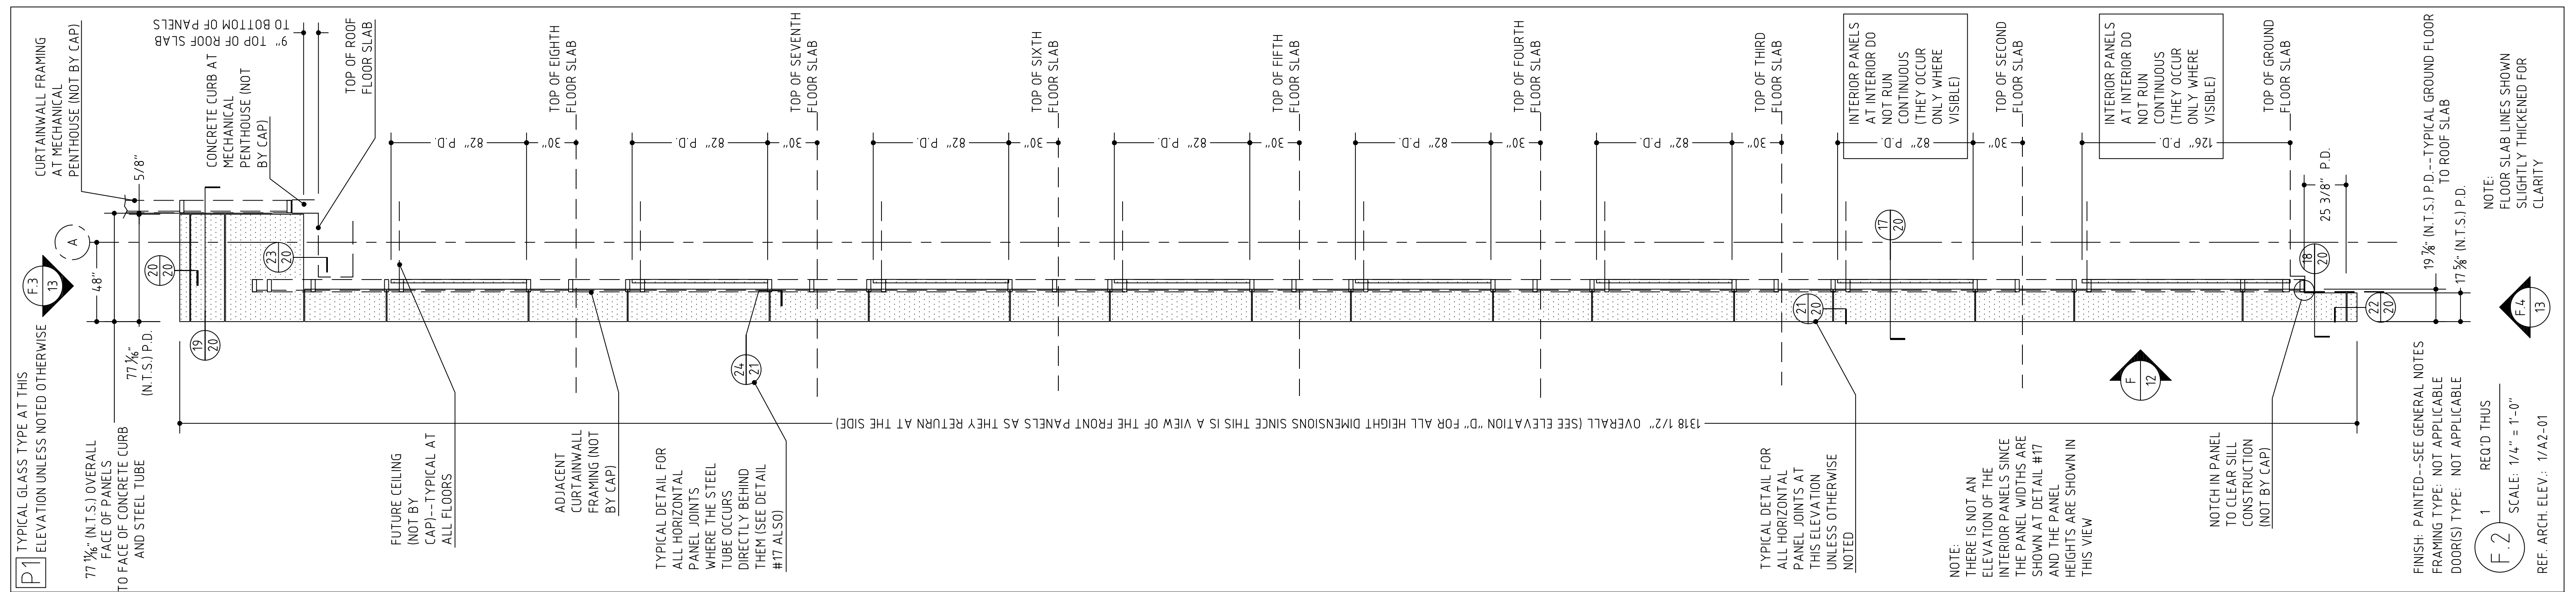

FABRICATION RELEASE:

THE PANEL DIMENSIONS HAVE BEEN REVIEWED AND APPROVED AS NOTED ON THIS DRAWING. THE PANELS ARE HEREBY RELEASED FOR FABRICATION.

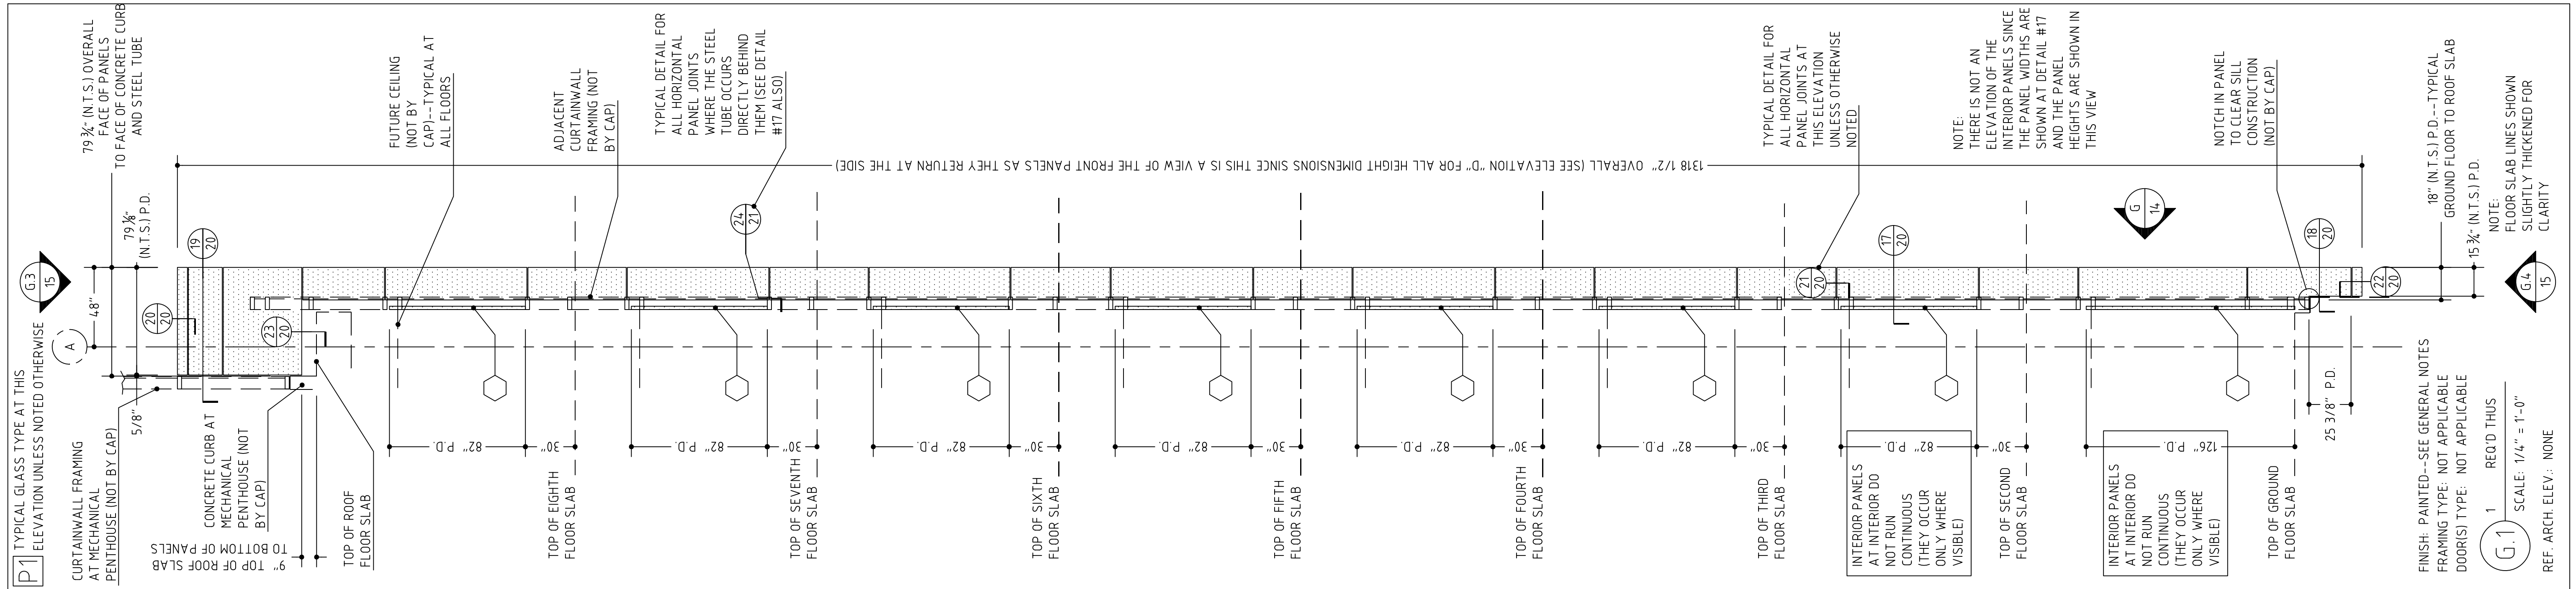

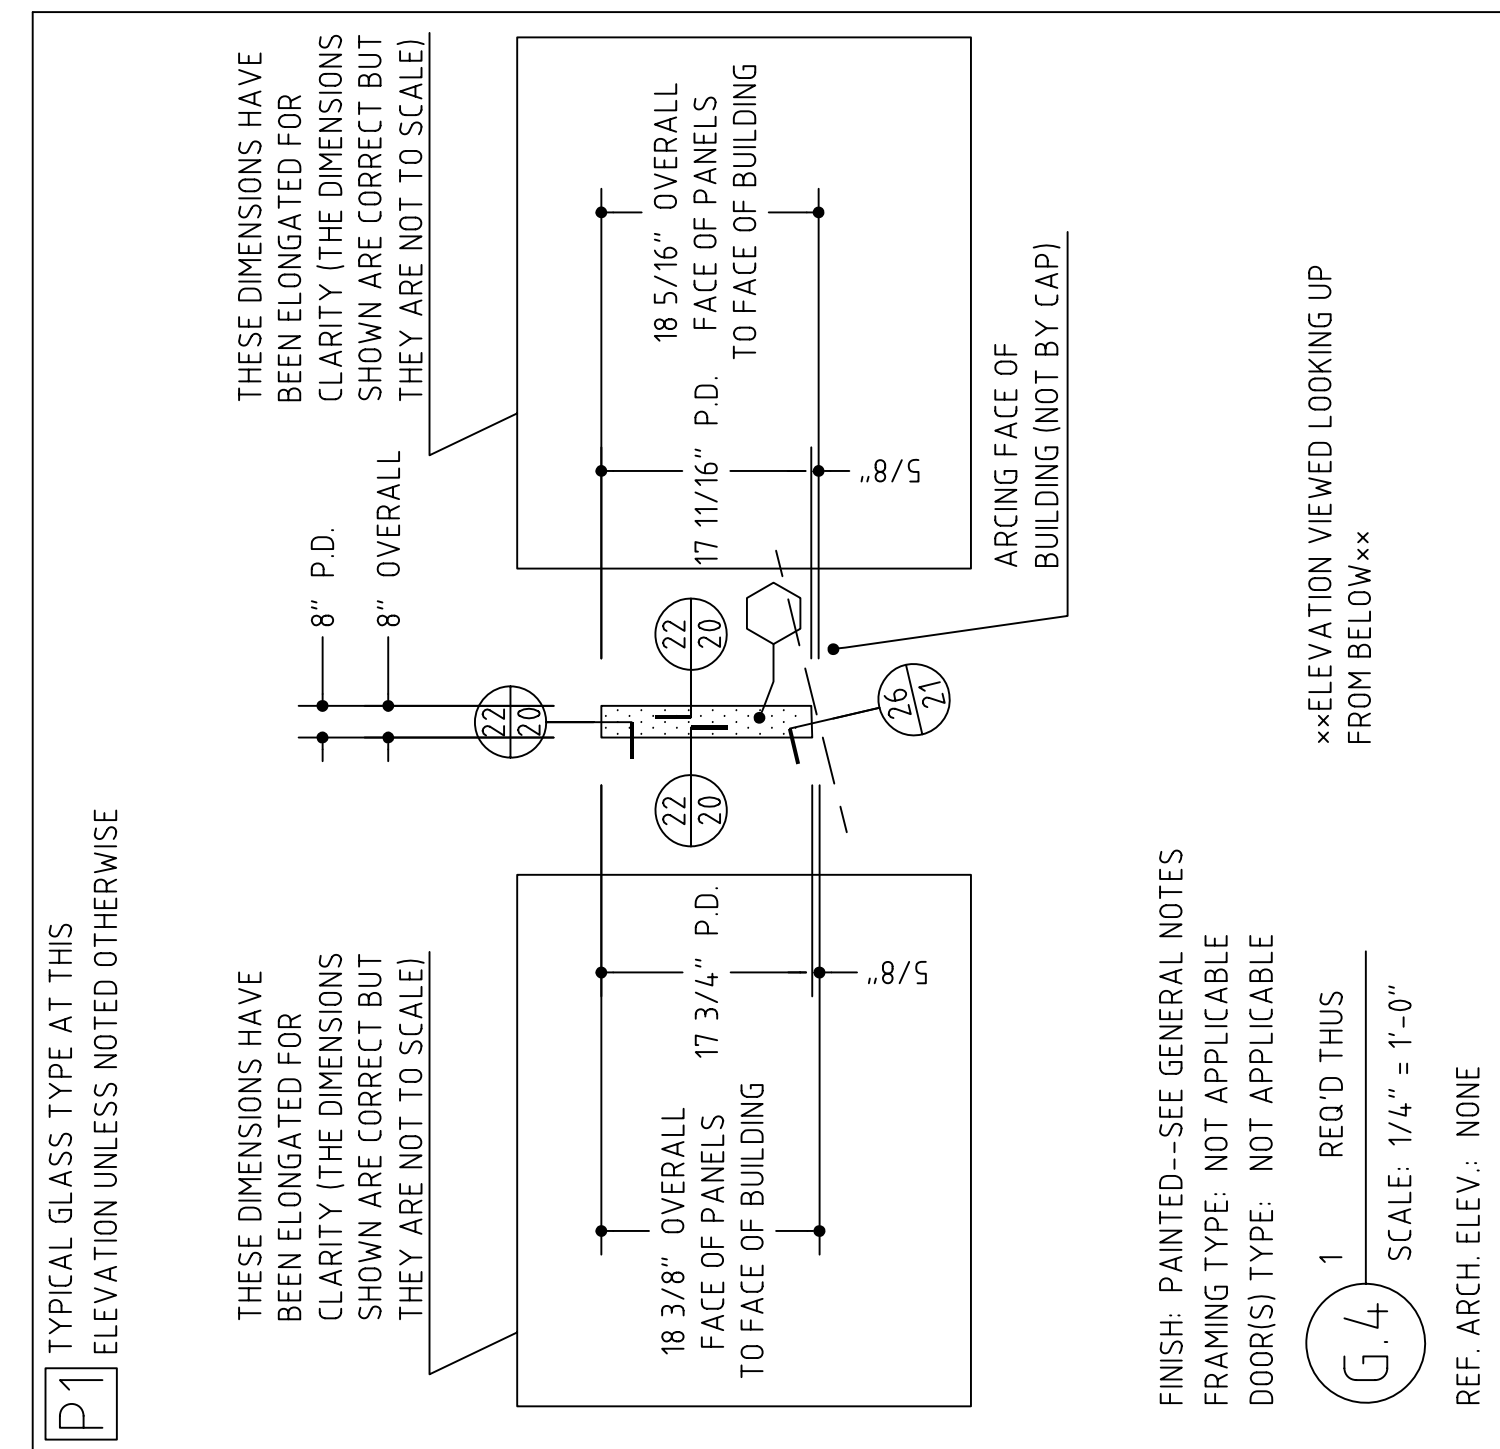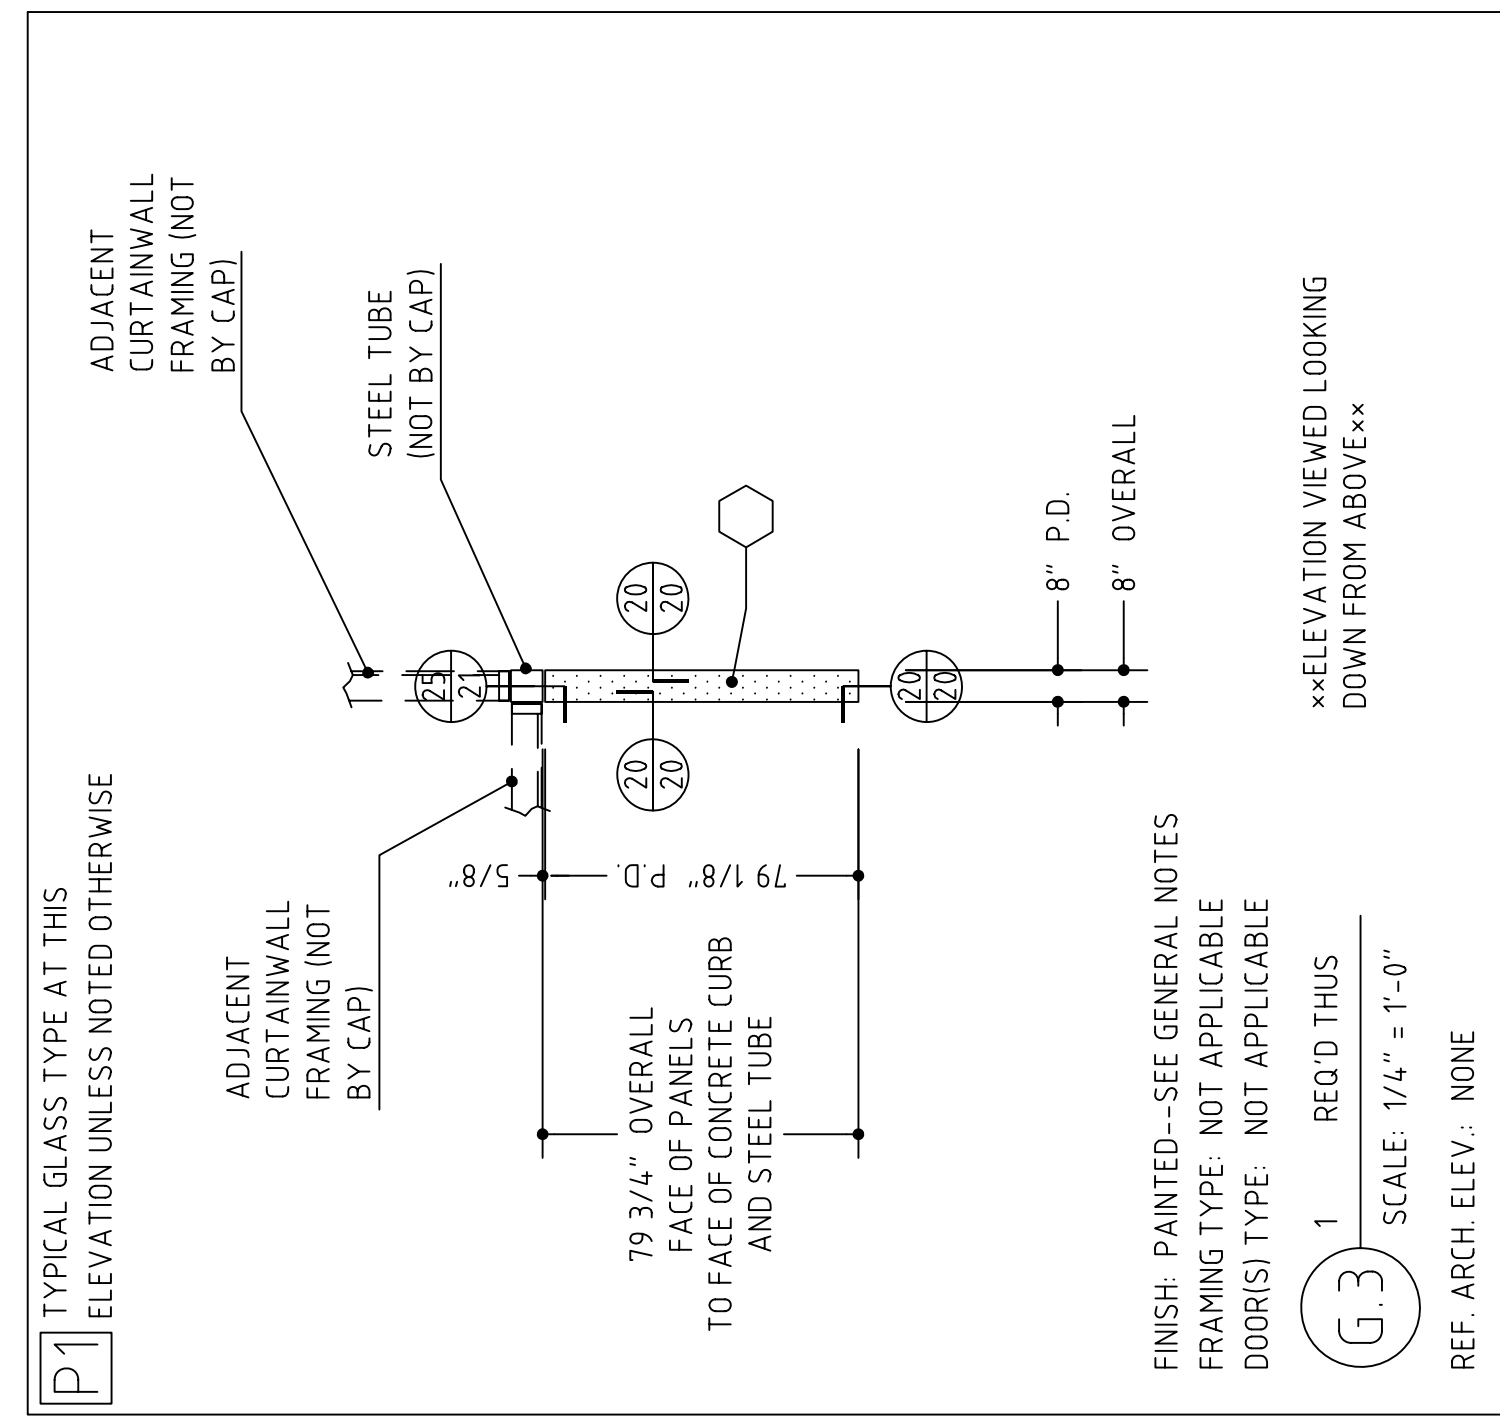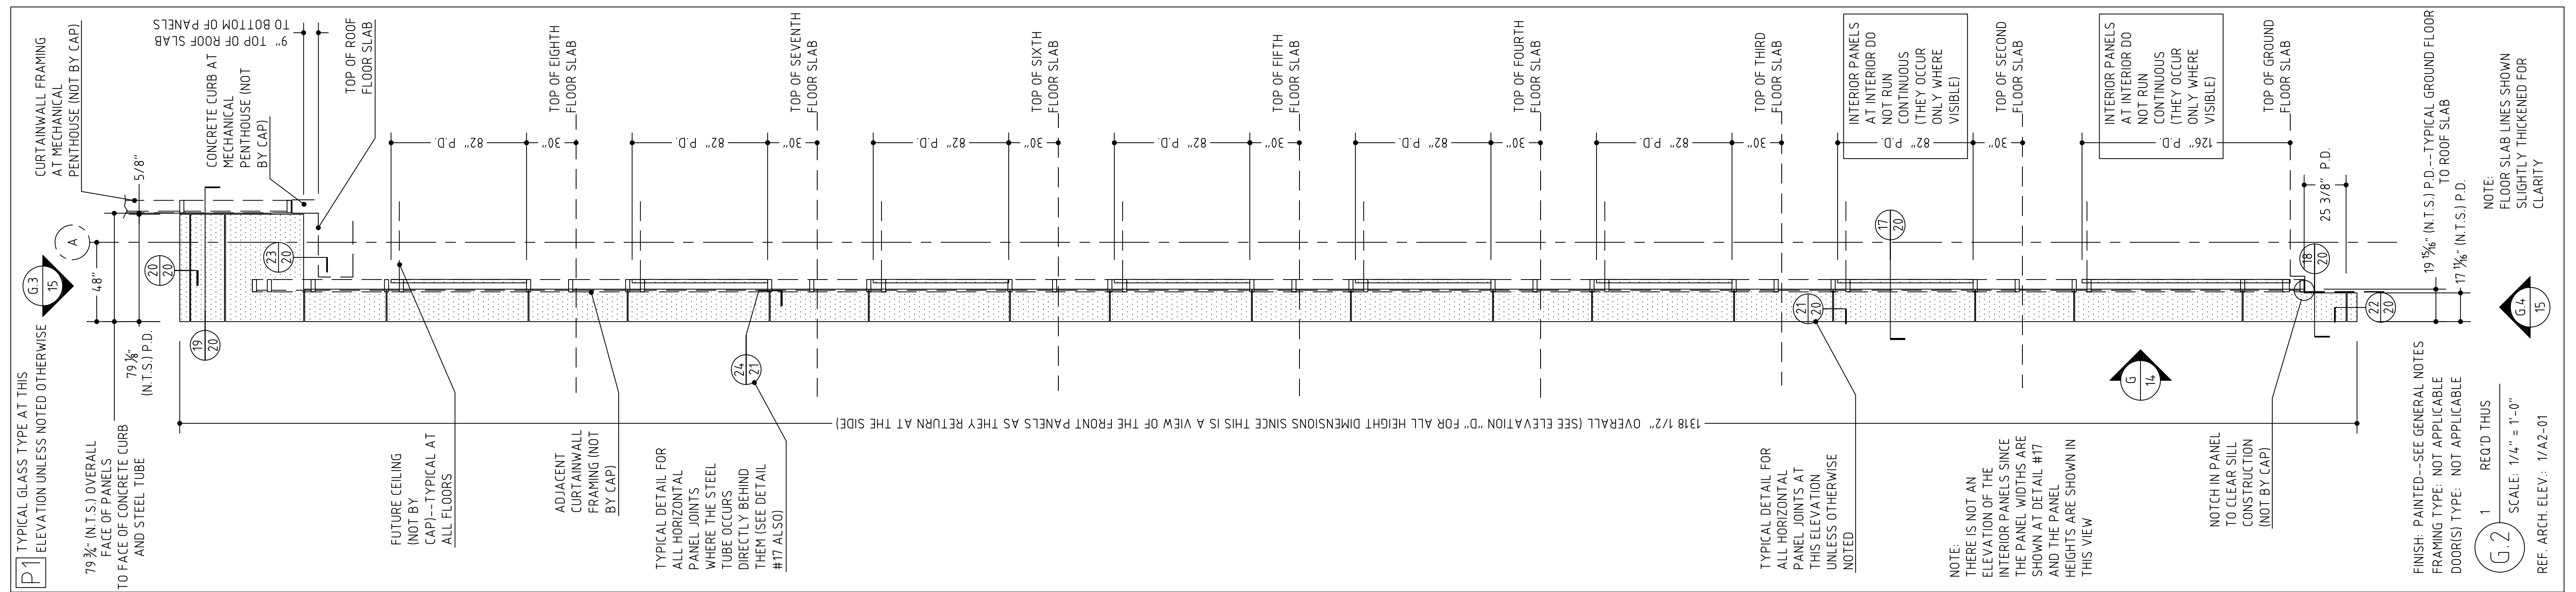




FABRICATION RELEASE:

THE PANEL DIMENSIONS HAVE BEEN REVIEWED AND APPROVED AS NOTED ON THIS DRAWING. THE PANELS ARE HEREBY RELEASED FOR FABRICATION.





VERIFY ALL DIMENSIONS

FABRICATION RELEASE:

THE PANEL DIMENSIONS HAVE BEEN REVIEWED AND
APPROVED AS NOTED ON THIS DRAWING. THE
PANELS ARE HEREBY RELEASED FOR FABRICATION.

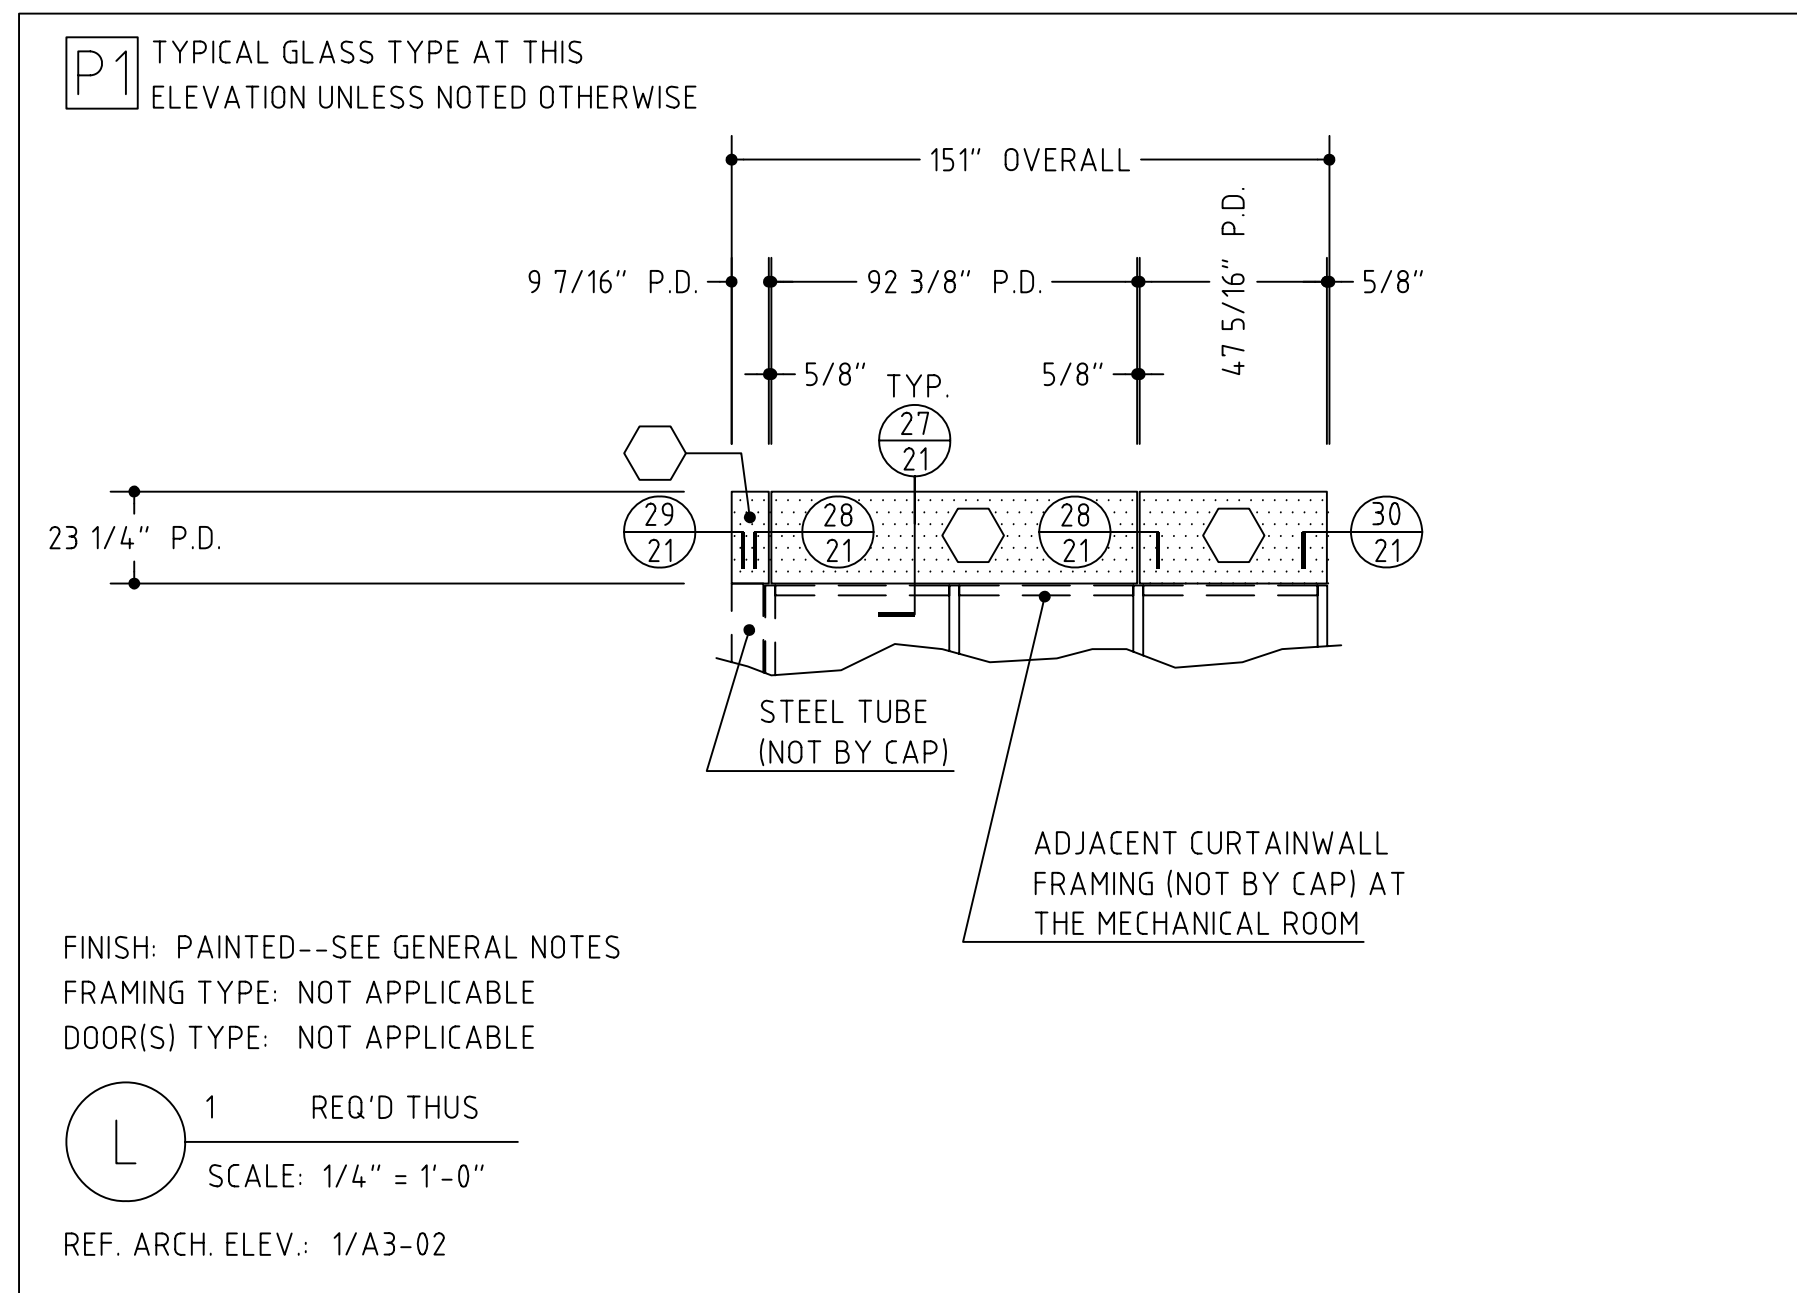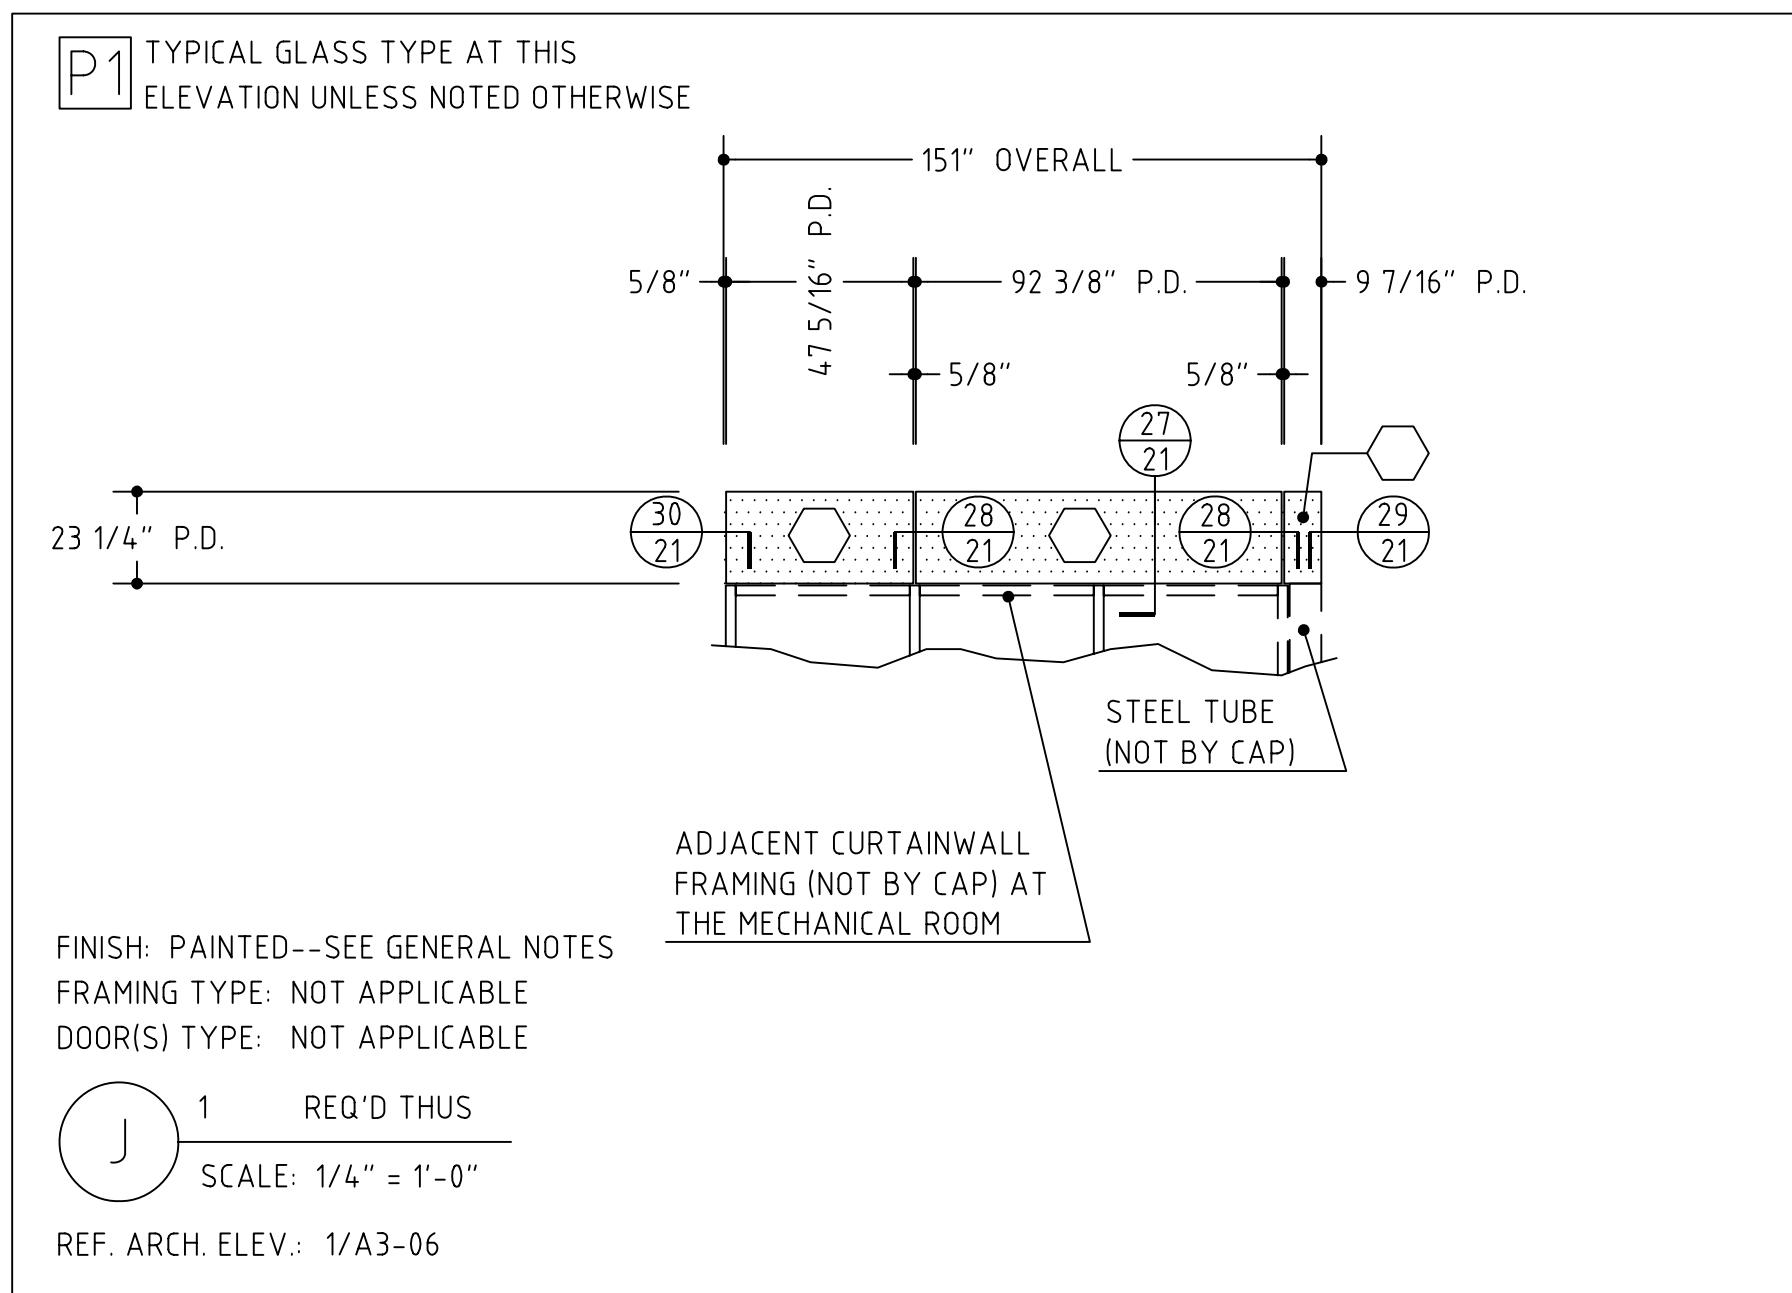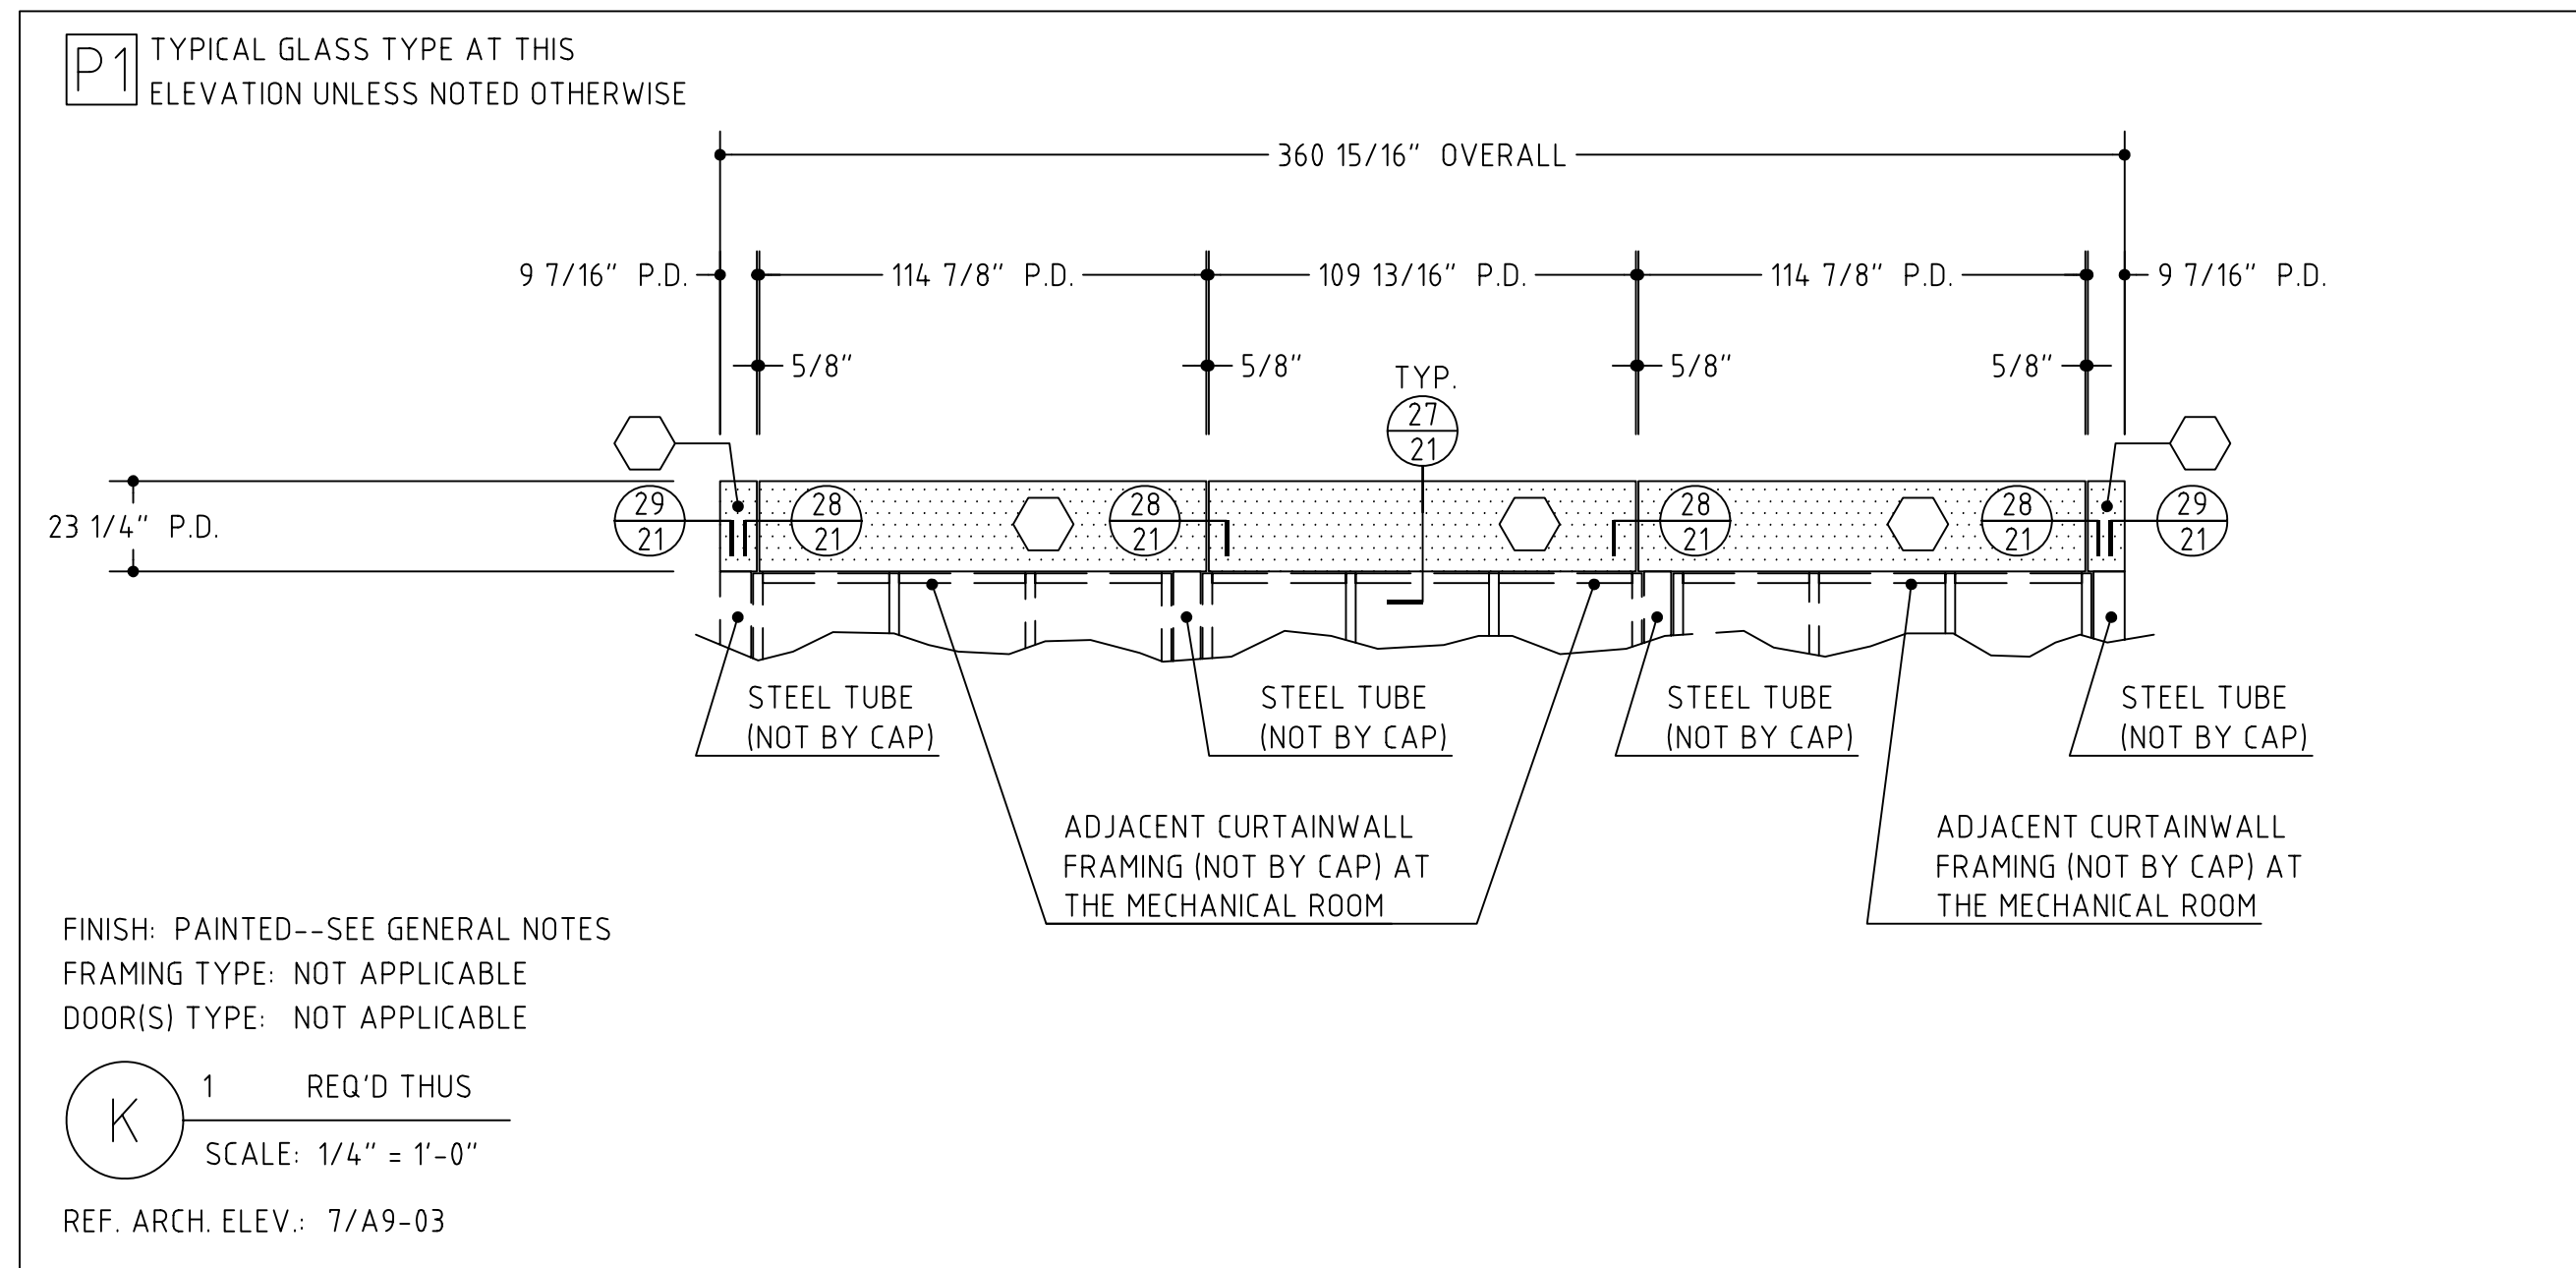



- PANEL NOTES....
- 105 4mm REYNOBOND PANEL (SEE PANEL SCHEDULE ON SHEET #1 FOR MORE INFORMATION)
 - 106 SEALANT NOT BY CAP
 - 107 BACKING ROD, DENVER FOAM OR BOND BREAKER TAPE NOT BY CAP
 - 110 ALUMINUM FLASHING NOT BY CAP
 - 112 FASTENER NOT BY CAP
 - 113 COPING AND ATTACHMENT NOT BY CAP
 - 118 SLIGHTLY THICKENED LINE INDICATES PERIMETER CONSTRUCTION NOT BY CAP
 - 119 SHIMS (SHIM AS NEEDED) NOT BY CAP
 - 120 ALUMINUM CLIP ANGLE (INTERMITTENT UNLESS NOTED OTHERWISE) FURNISHED ONLY BY CAP IN STOCK LENGTHS
 - 121 RIVET CONNECTION BETWEEN PANEL AND ALUMINUM ANGLE (RIVET BY CAP), ACTUAL CONNECTION NOT BY CAP
 - 122 CURTAINWALL FRAMING NOT BY CAP
 - 123 CAULK NOT BY CAP
 - 124 ROOF CONSTRUCTION NOT BY CAP
 - 139 DOOR AND/OR SIDELITE NOT BY CAP

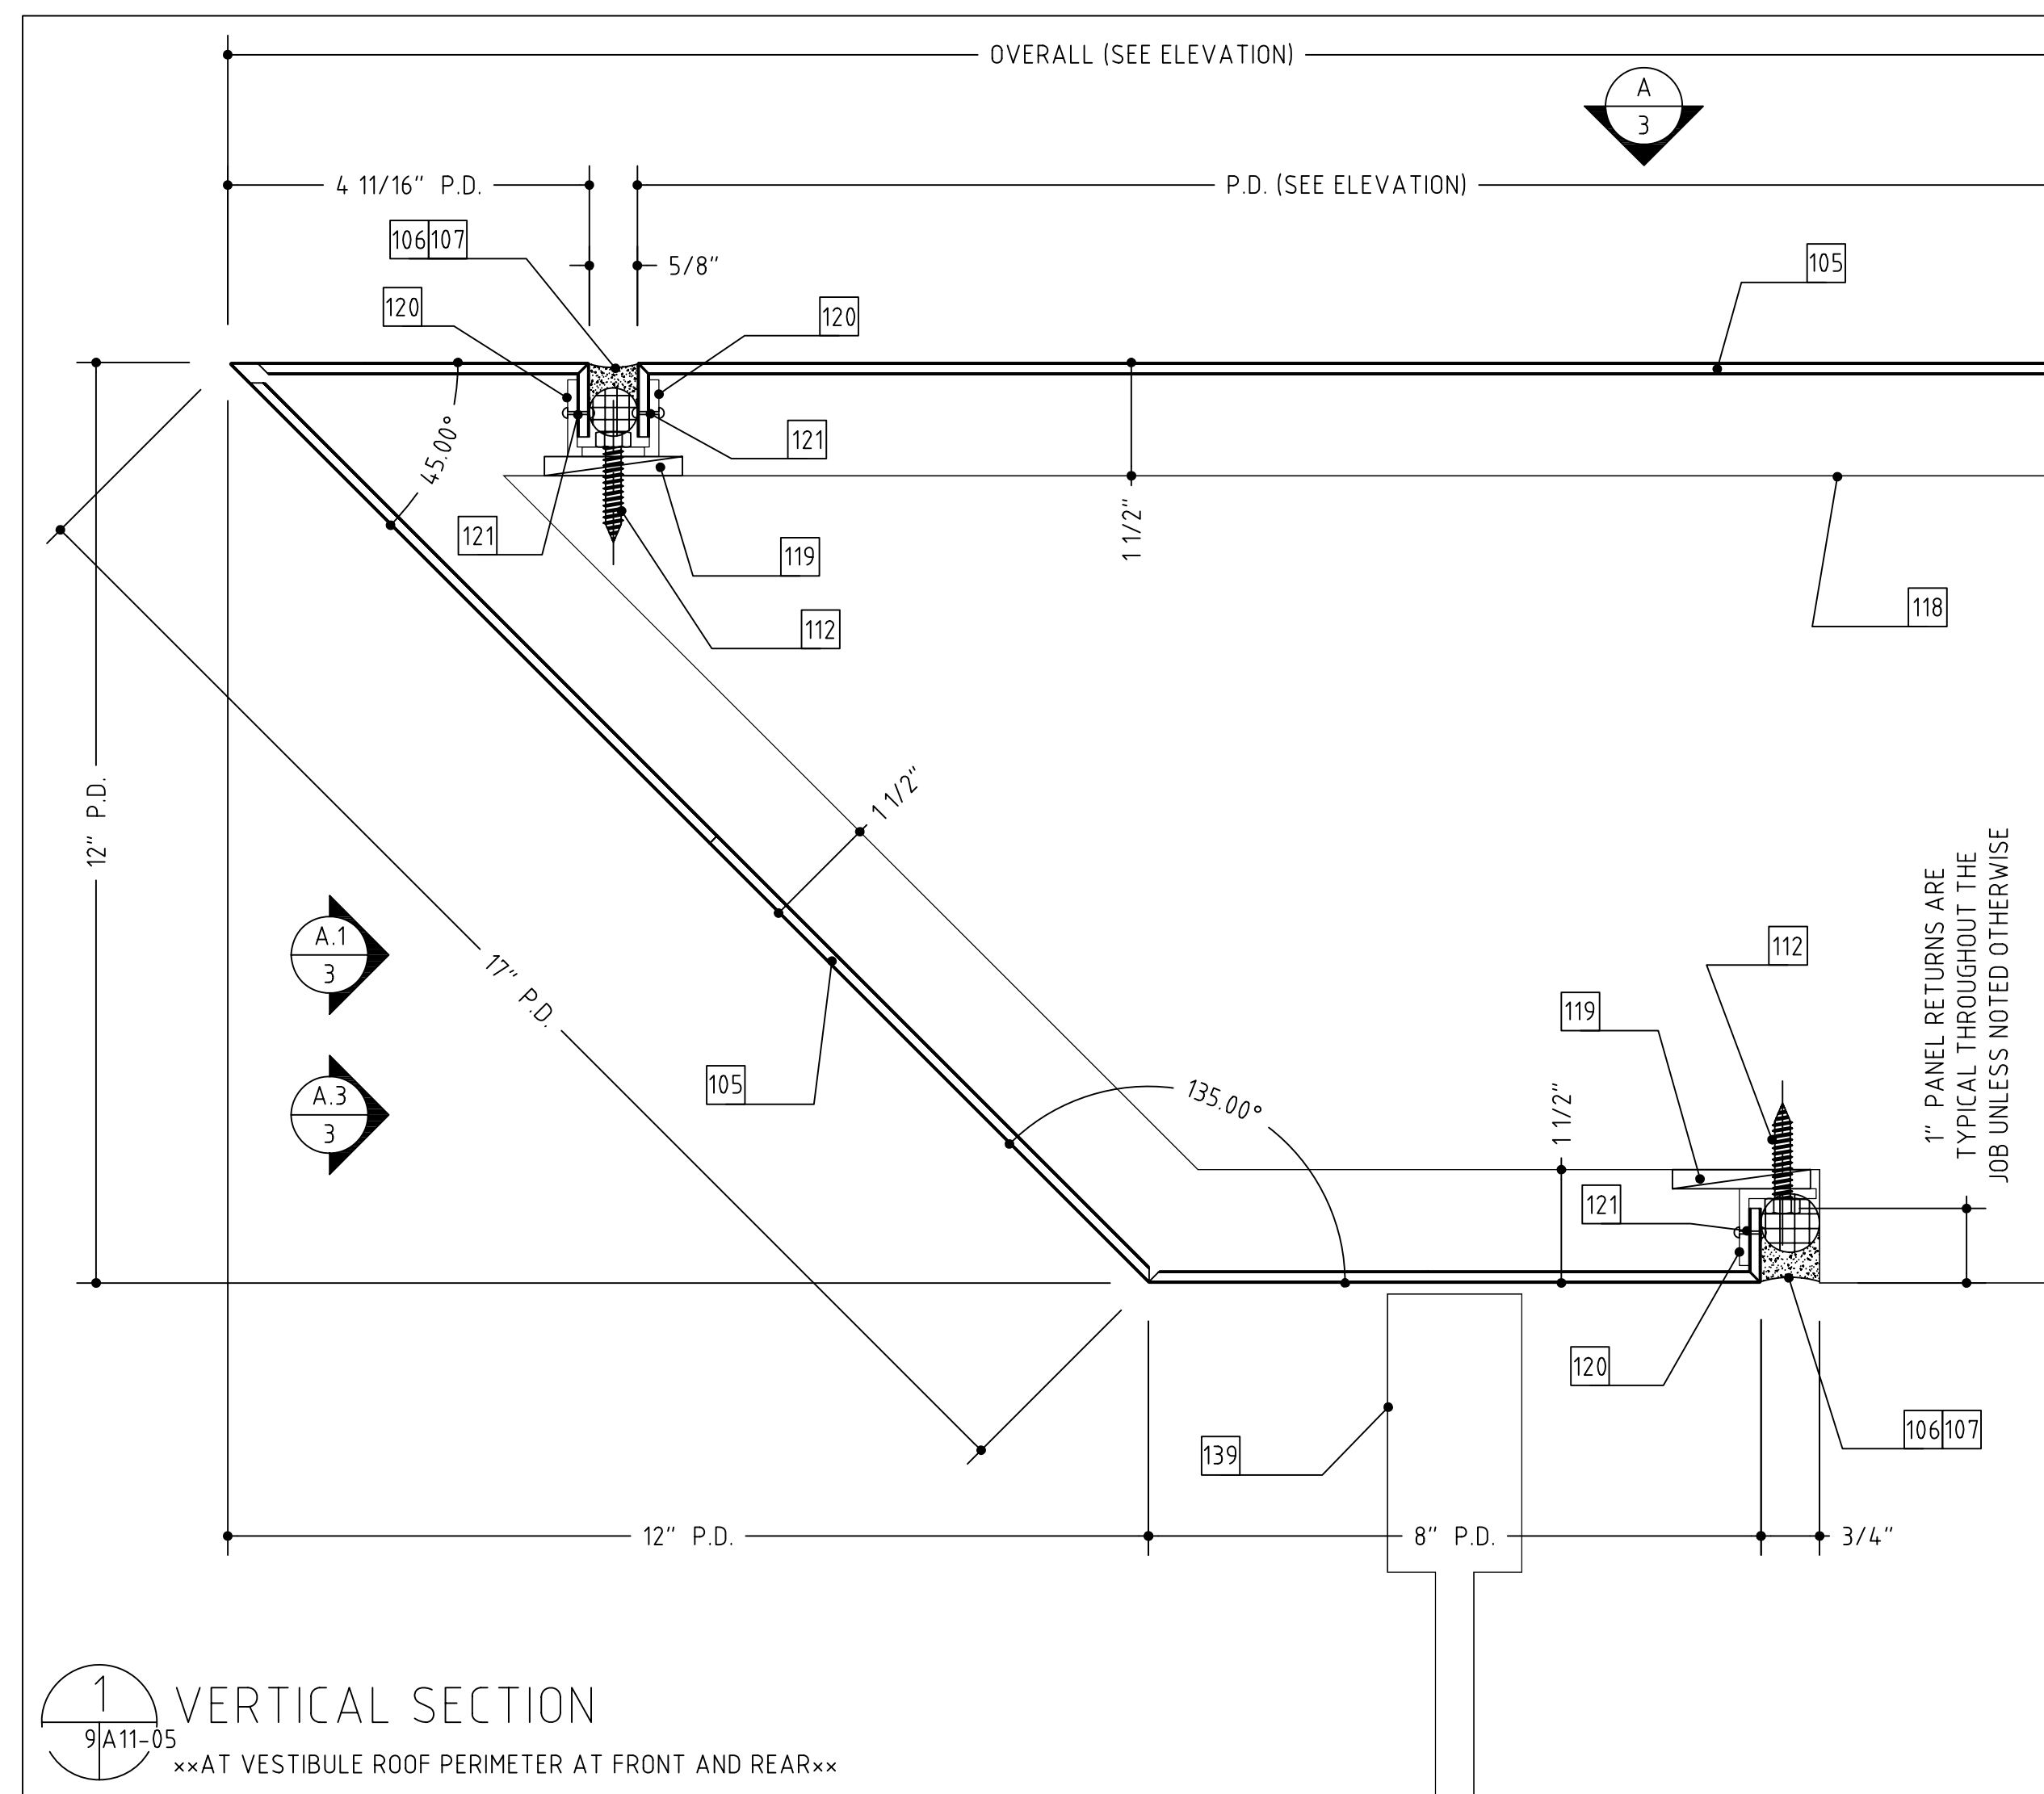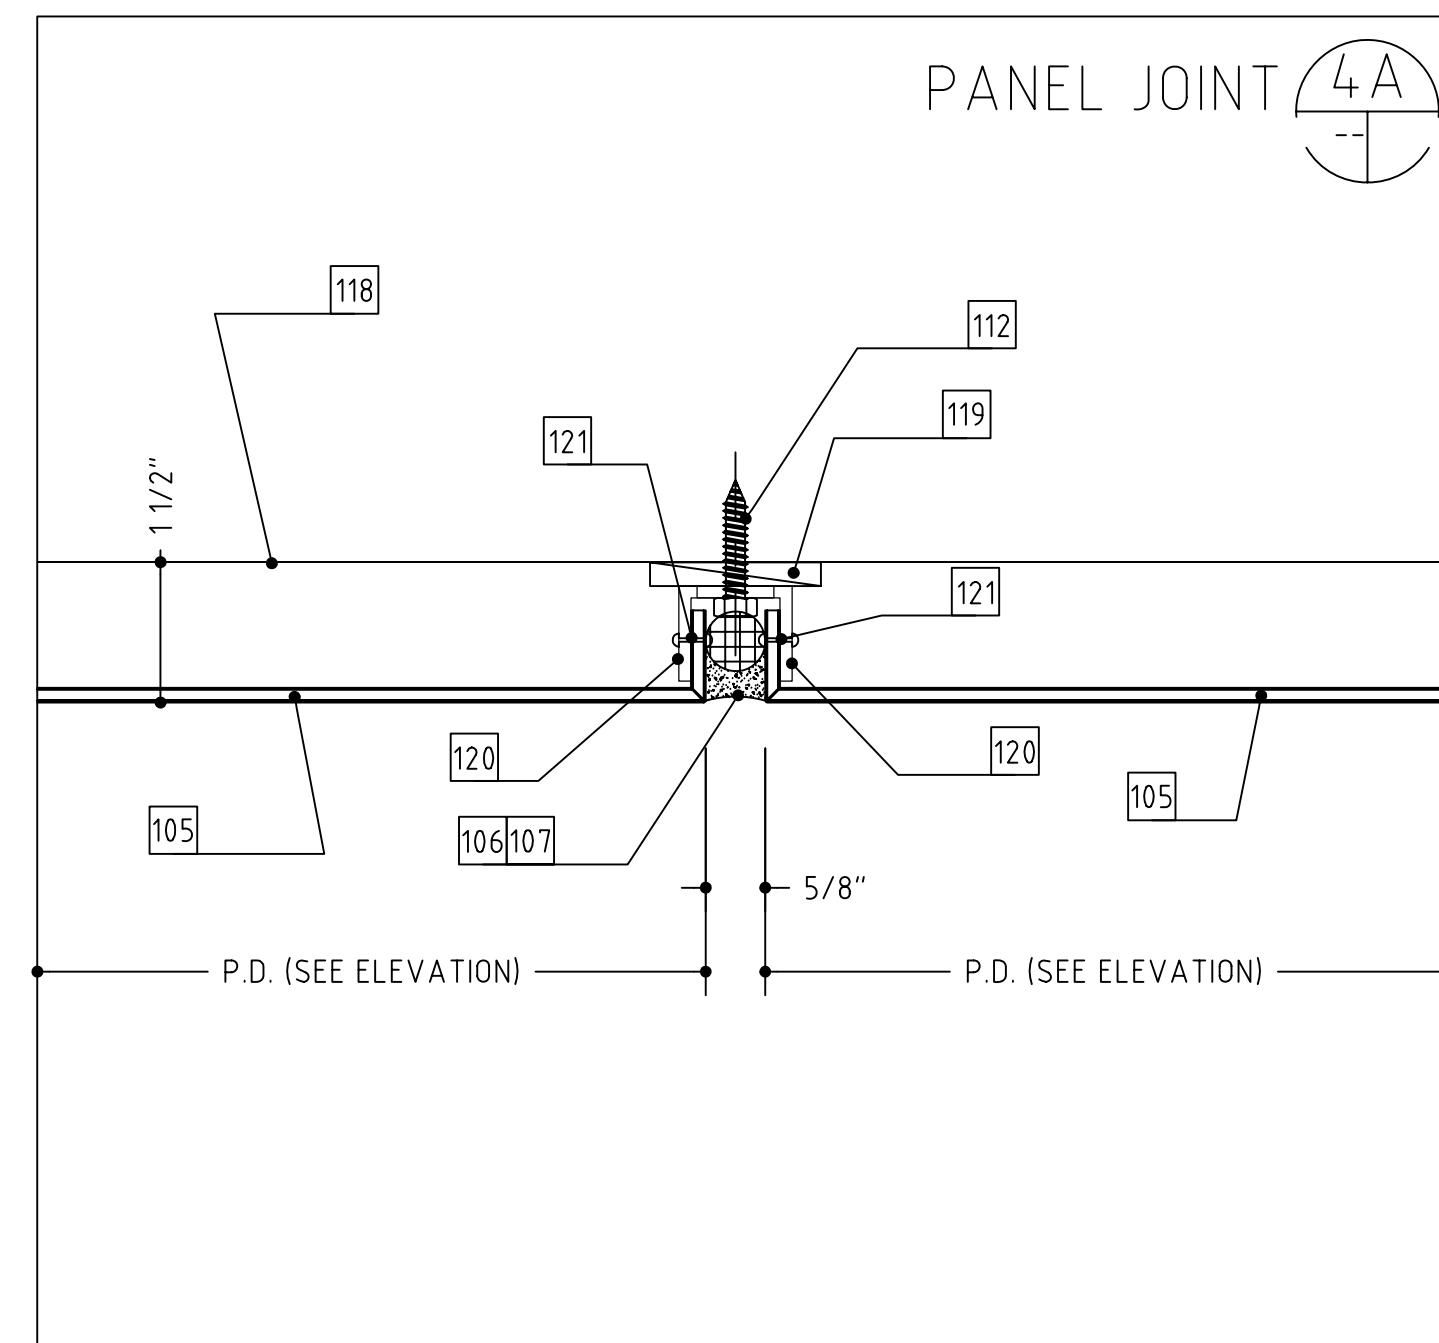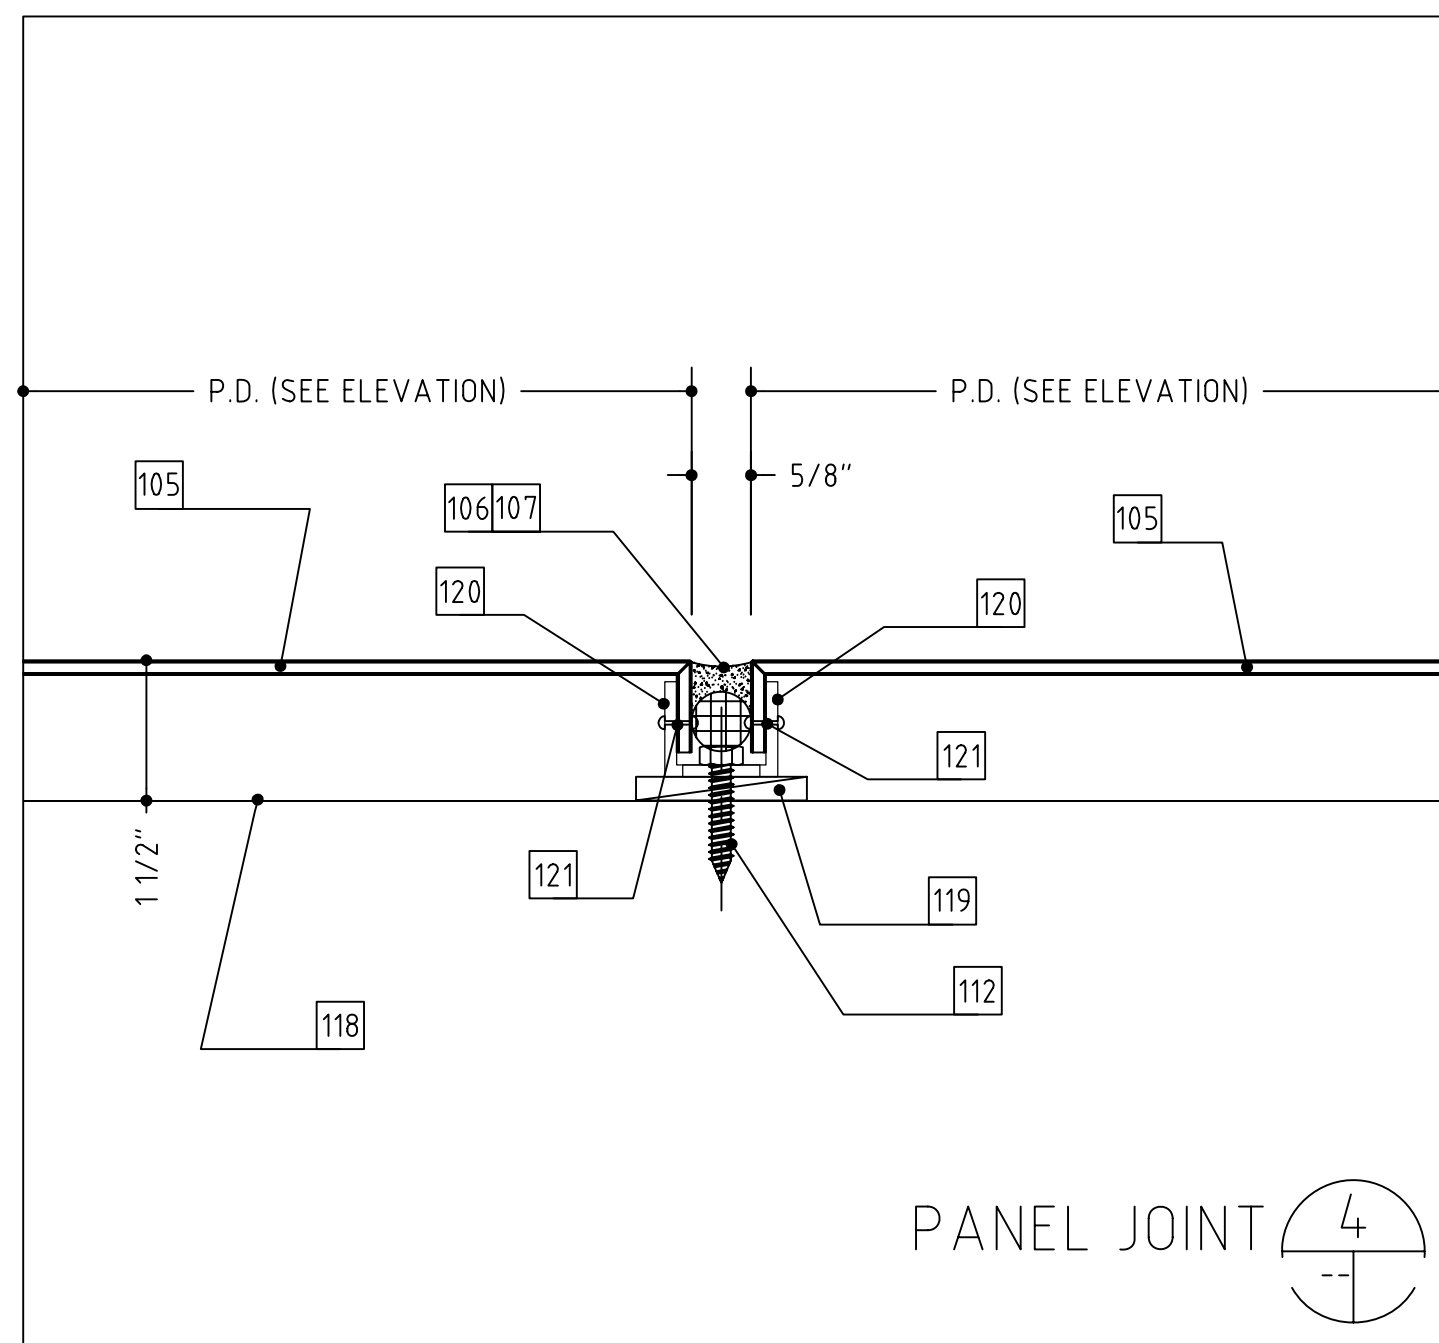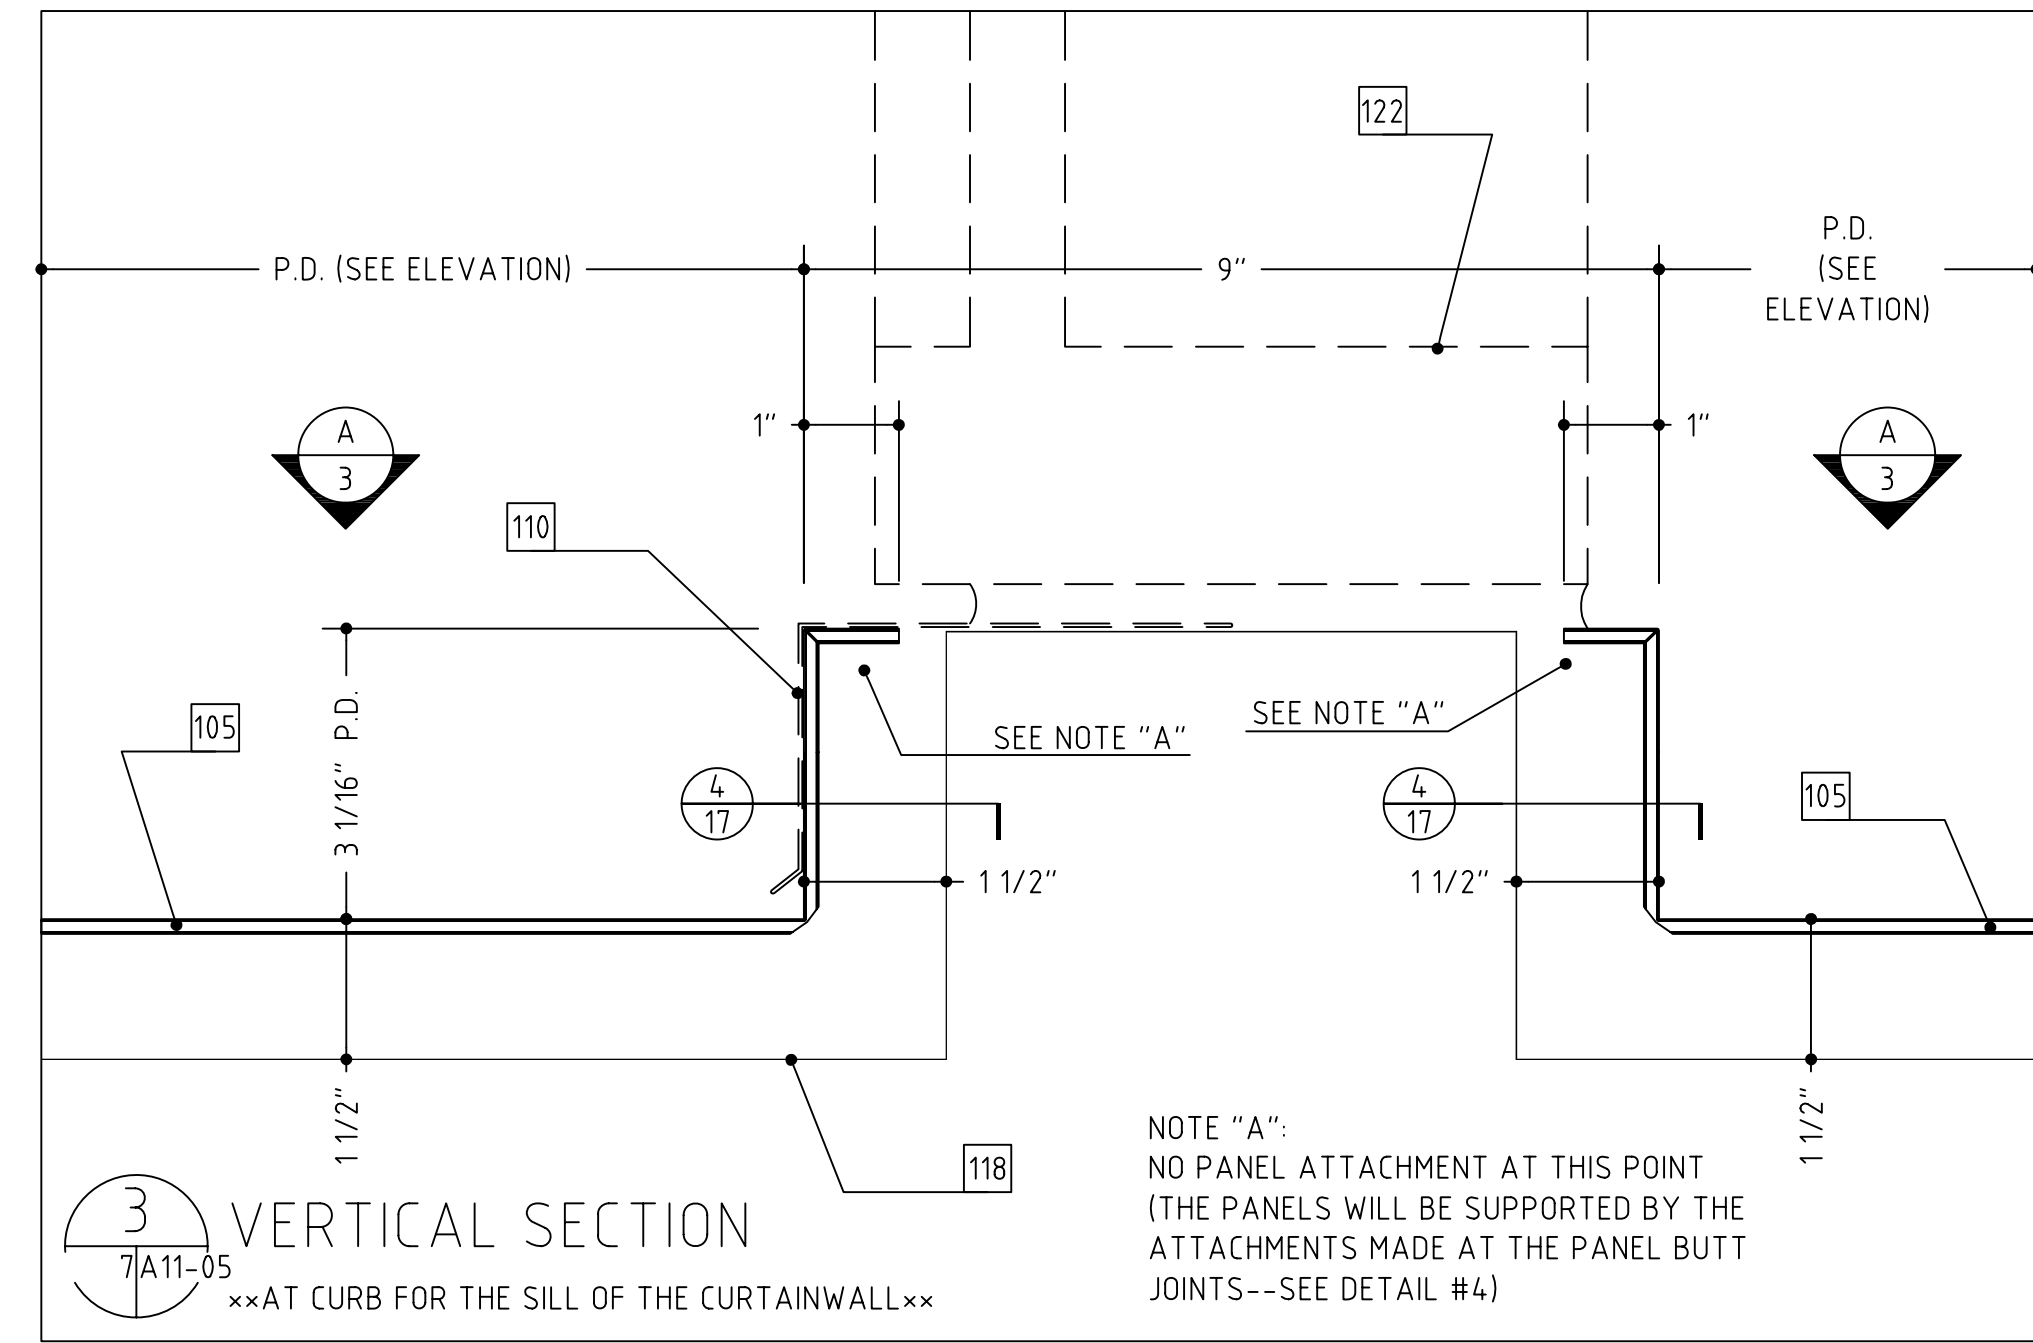

FABRICATION RELEASE:






THE PANEL DIMENSIONS HAVE BEEN REVIEWED AND APPROVED AS NOTED ON THIS DRAWING. THE PANELS ARE HEREBY RELEASED FOR FABRICATION.

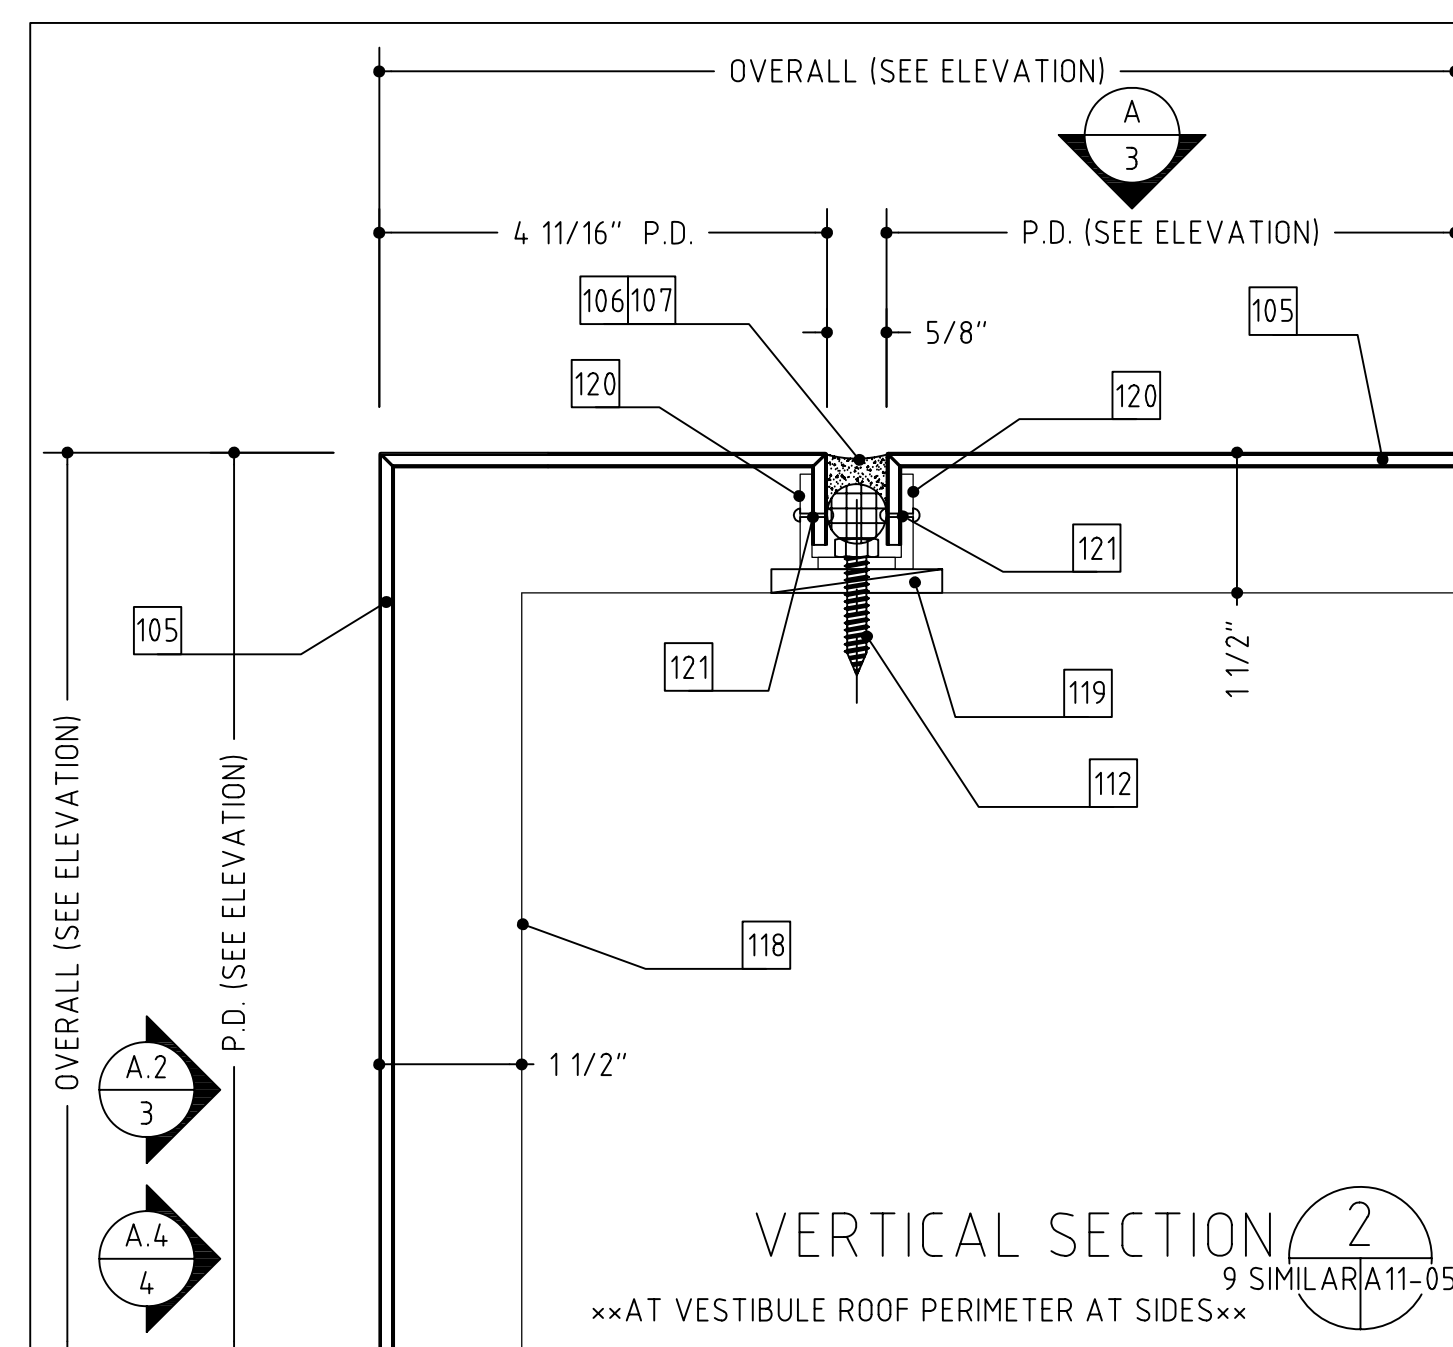

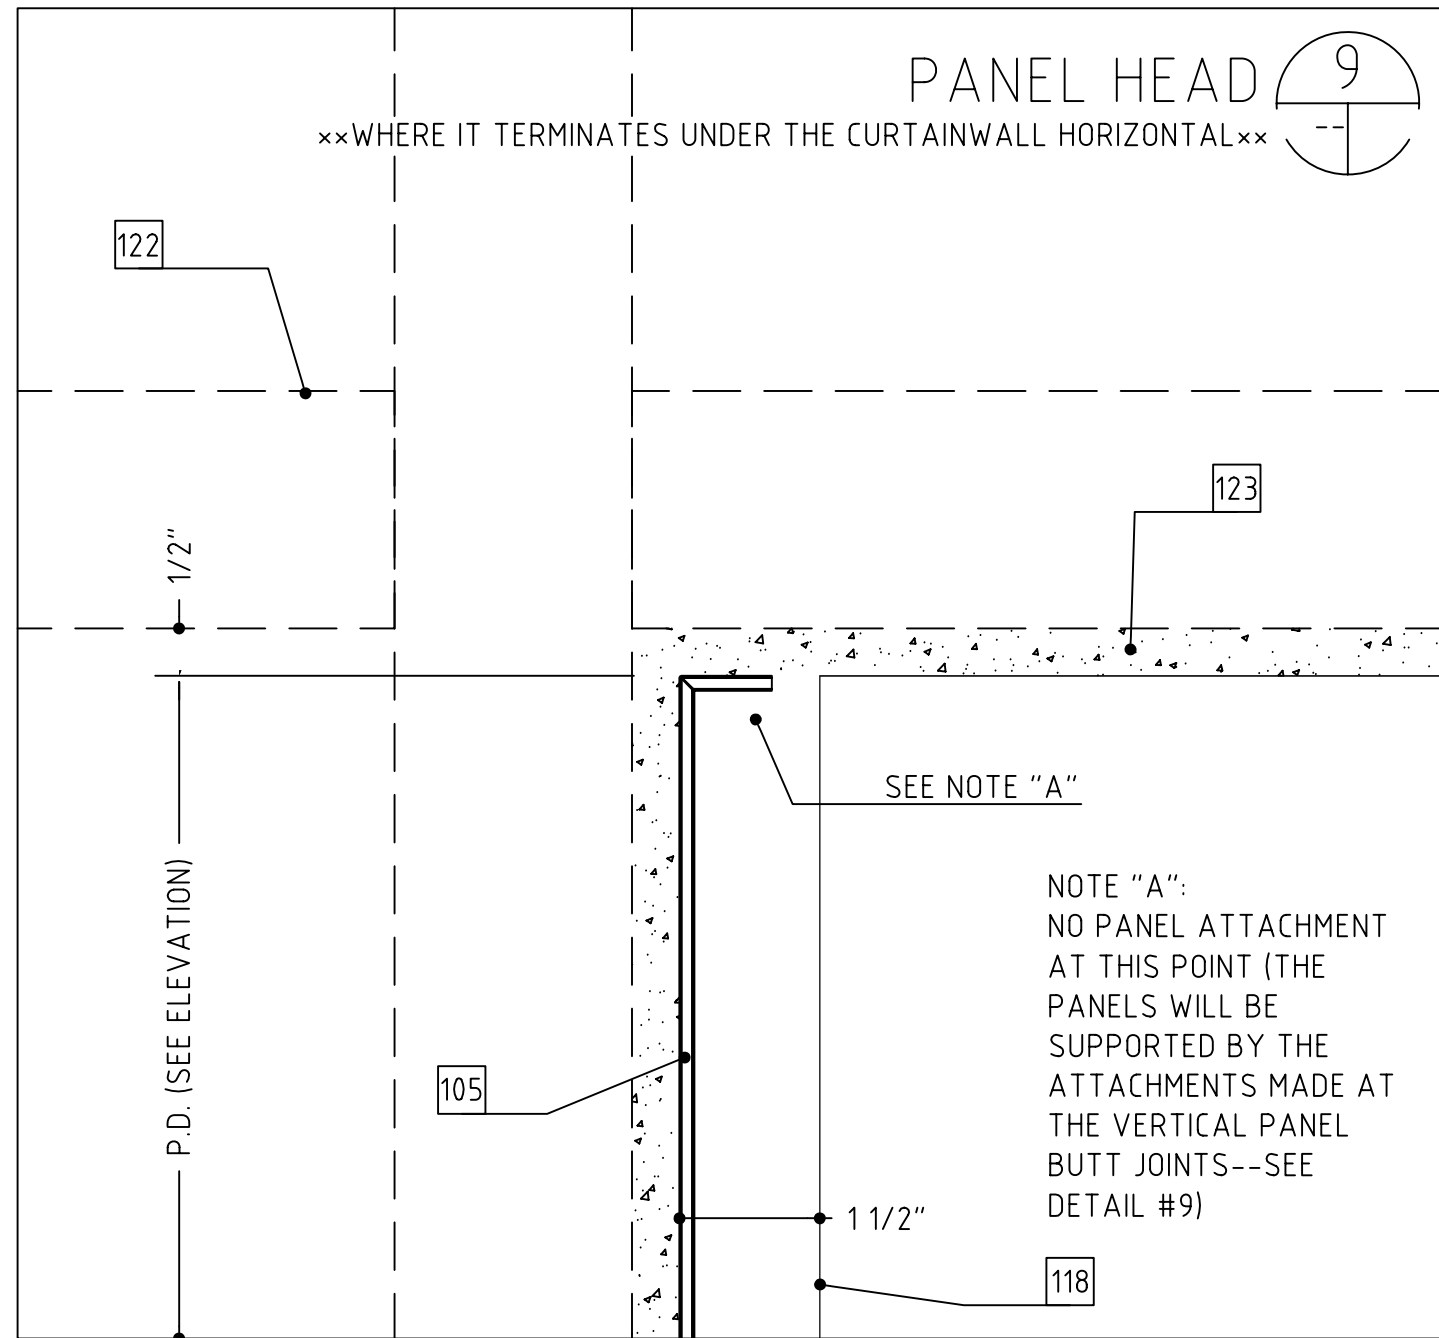




FABRICATION RELEASE:

THE PANEL DIMENSIONS HAVE BEEN REVIEWED AND
APPROVED AS NOTED ON THIS DRAWING. THE
PANELS ARE HEREBY RELEASED FOR FABRICATION.

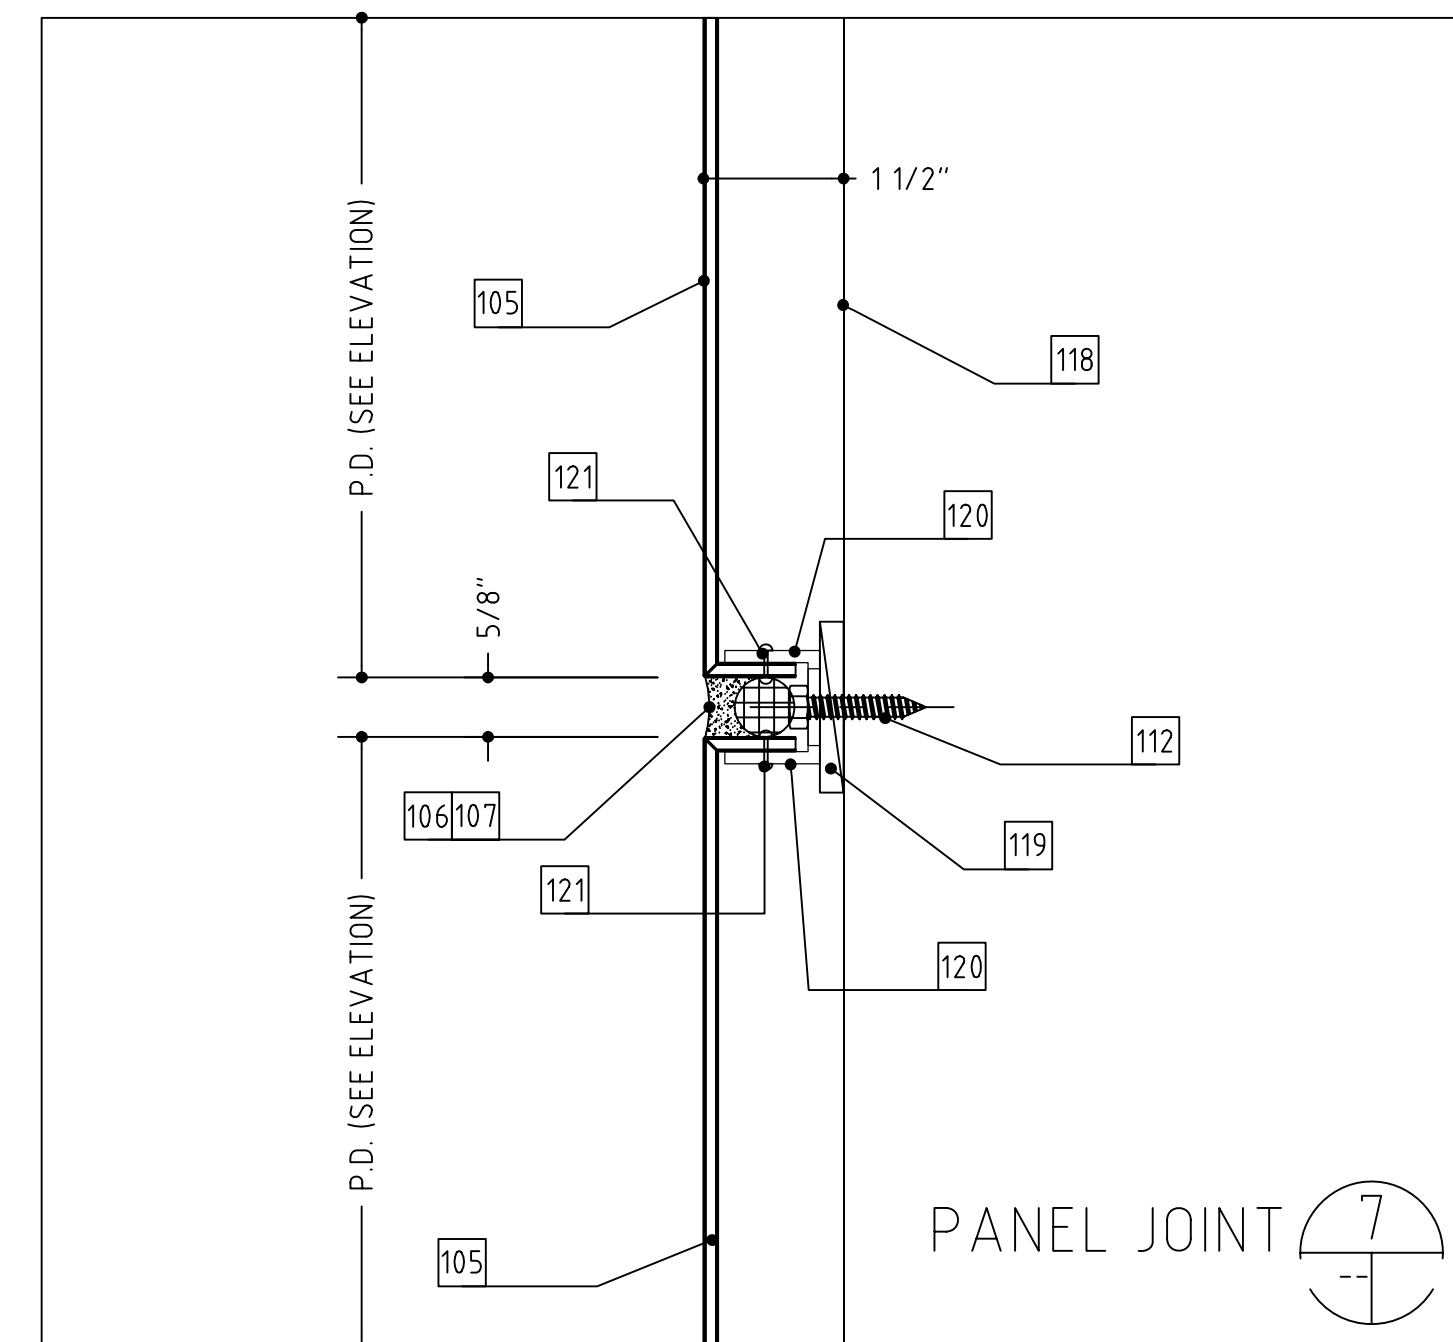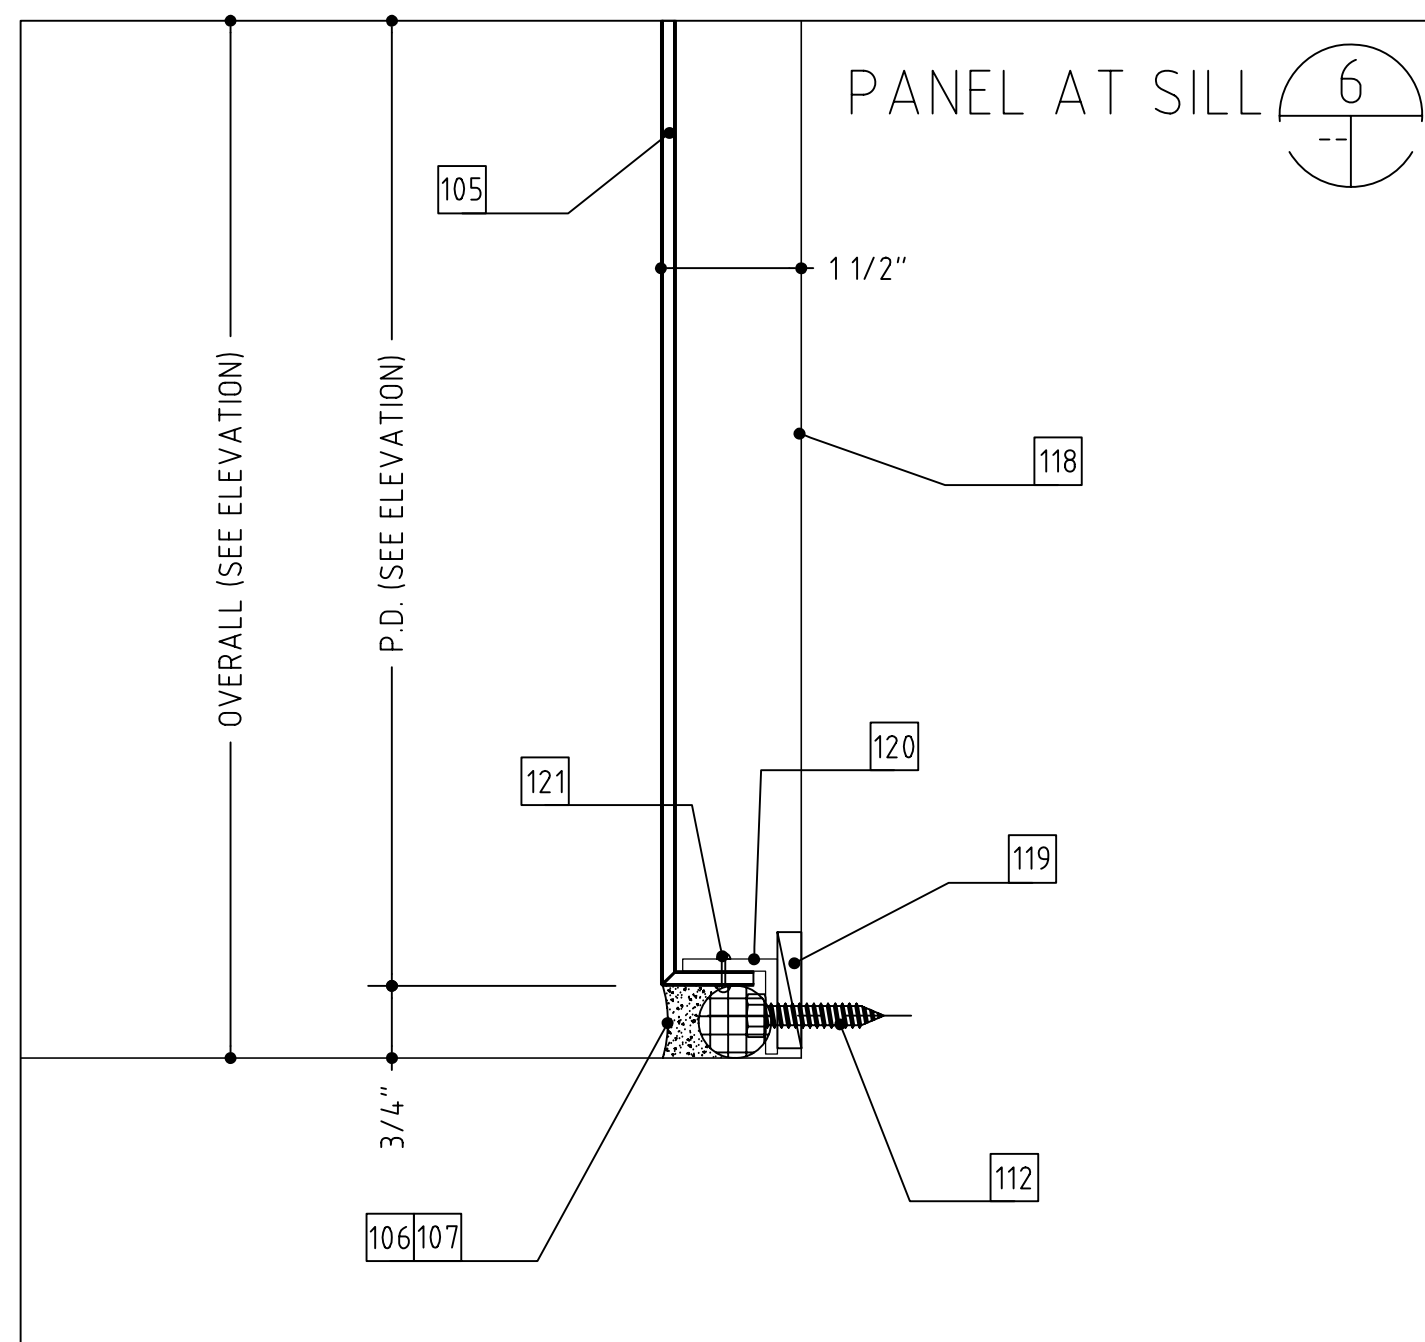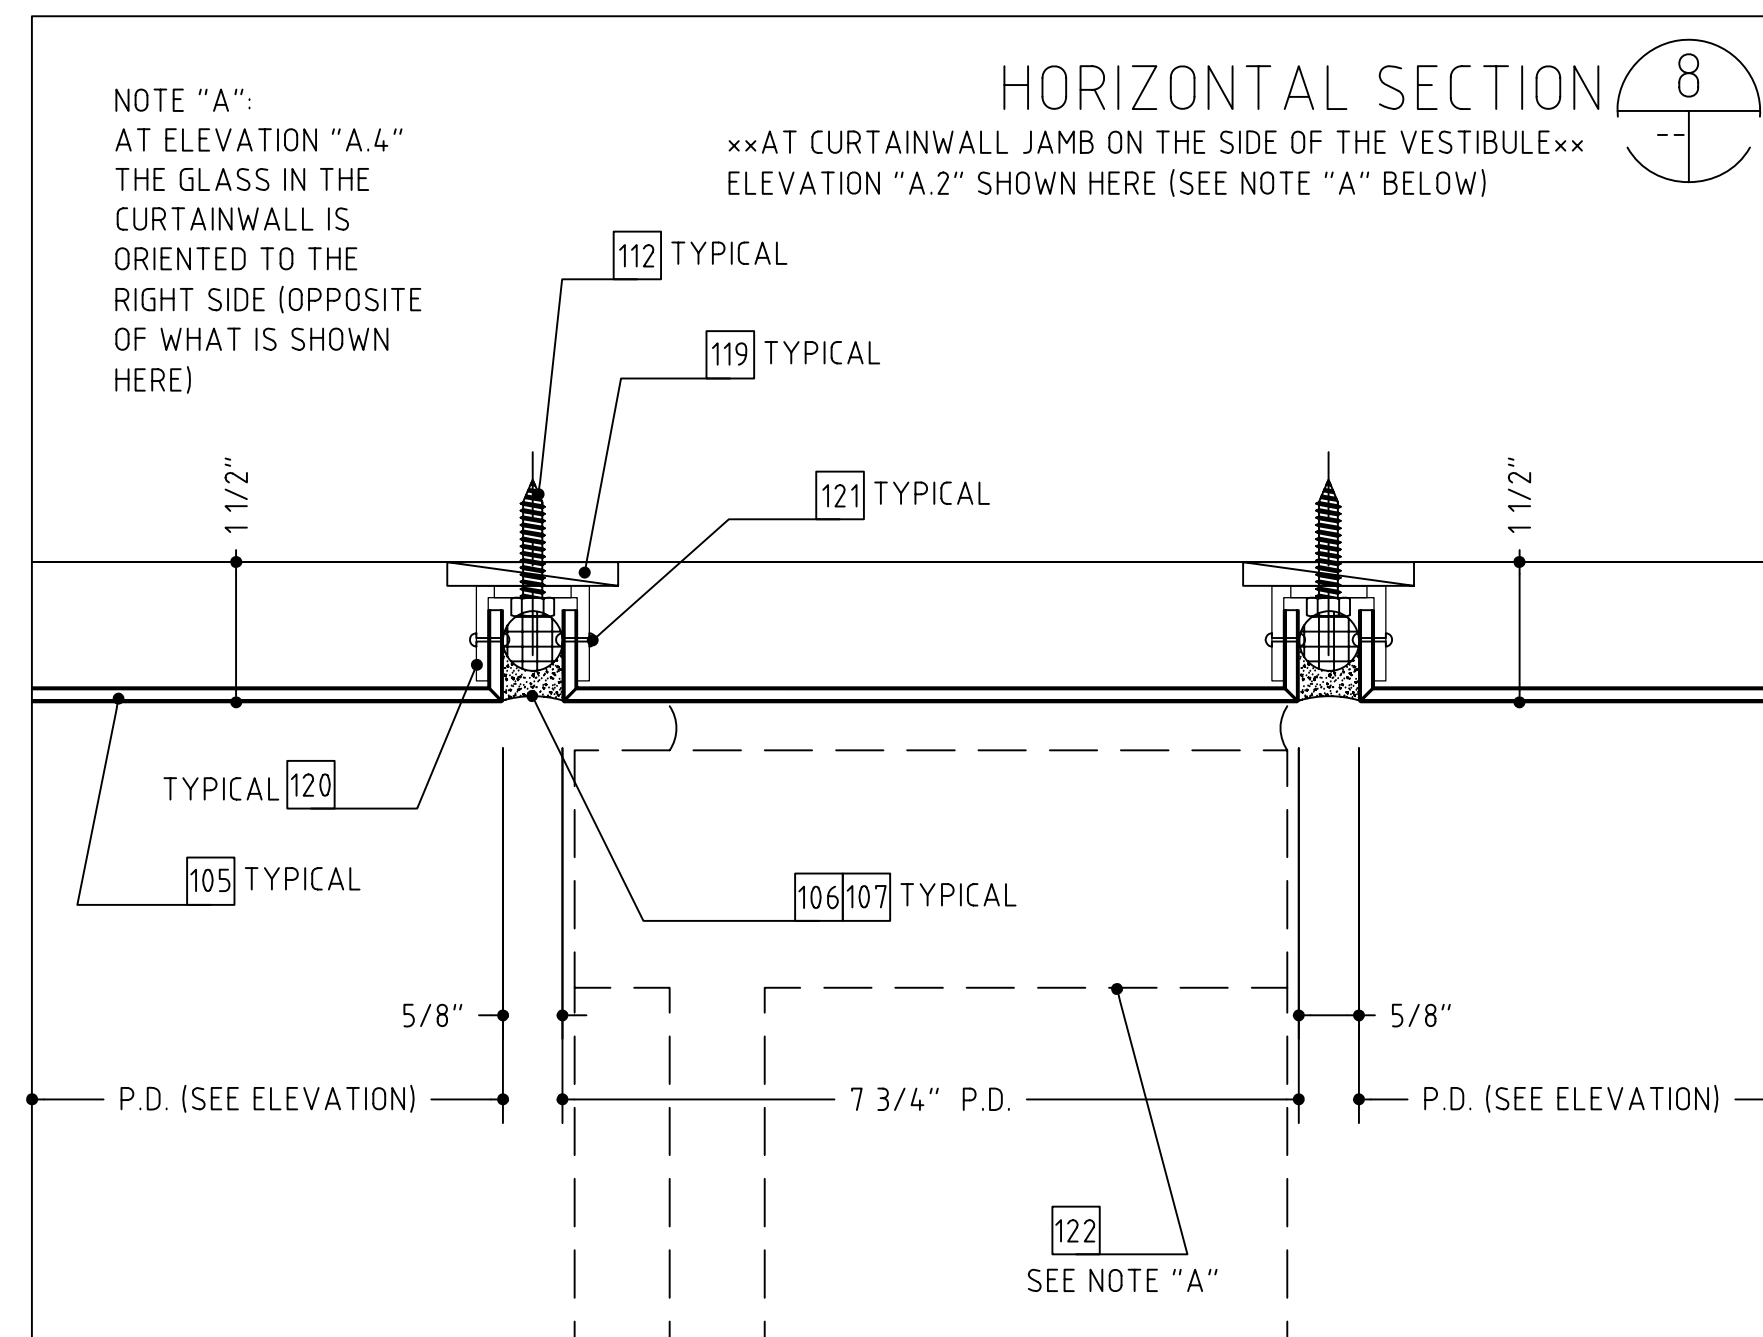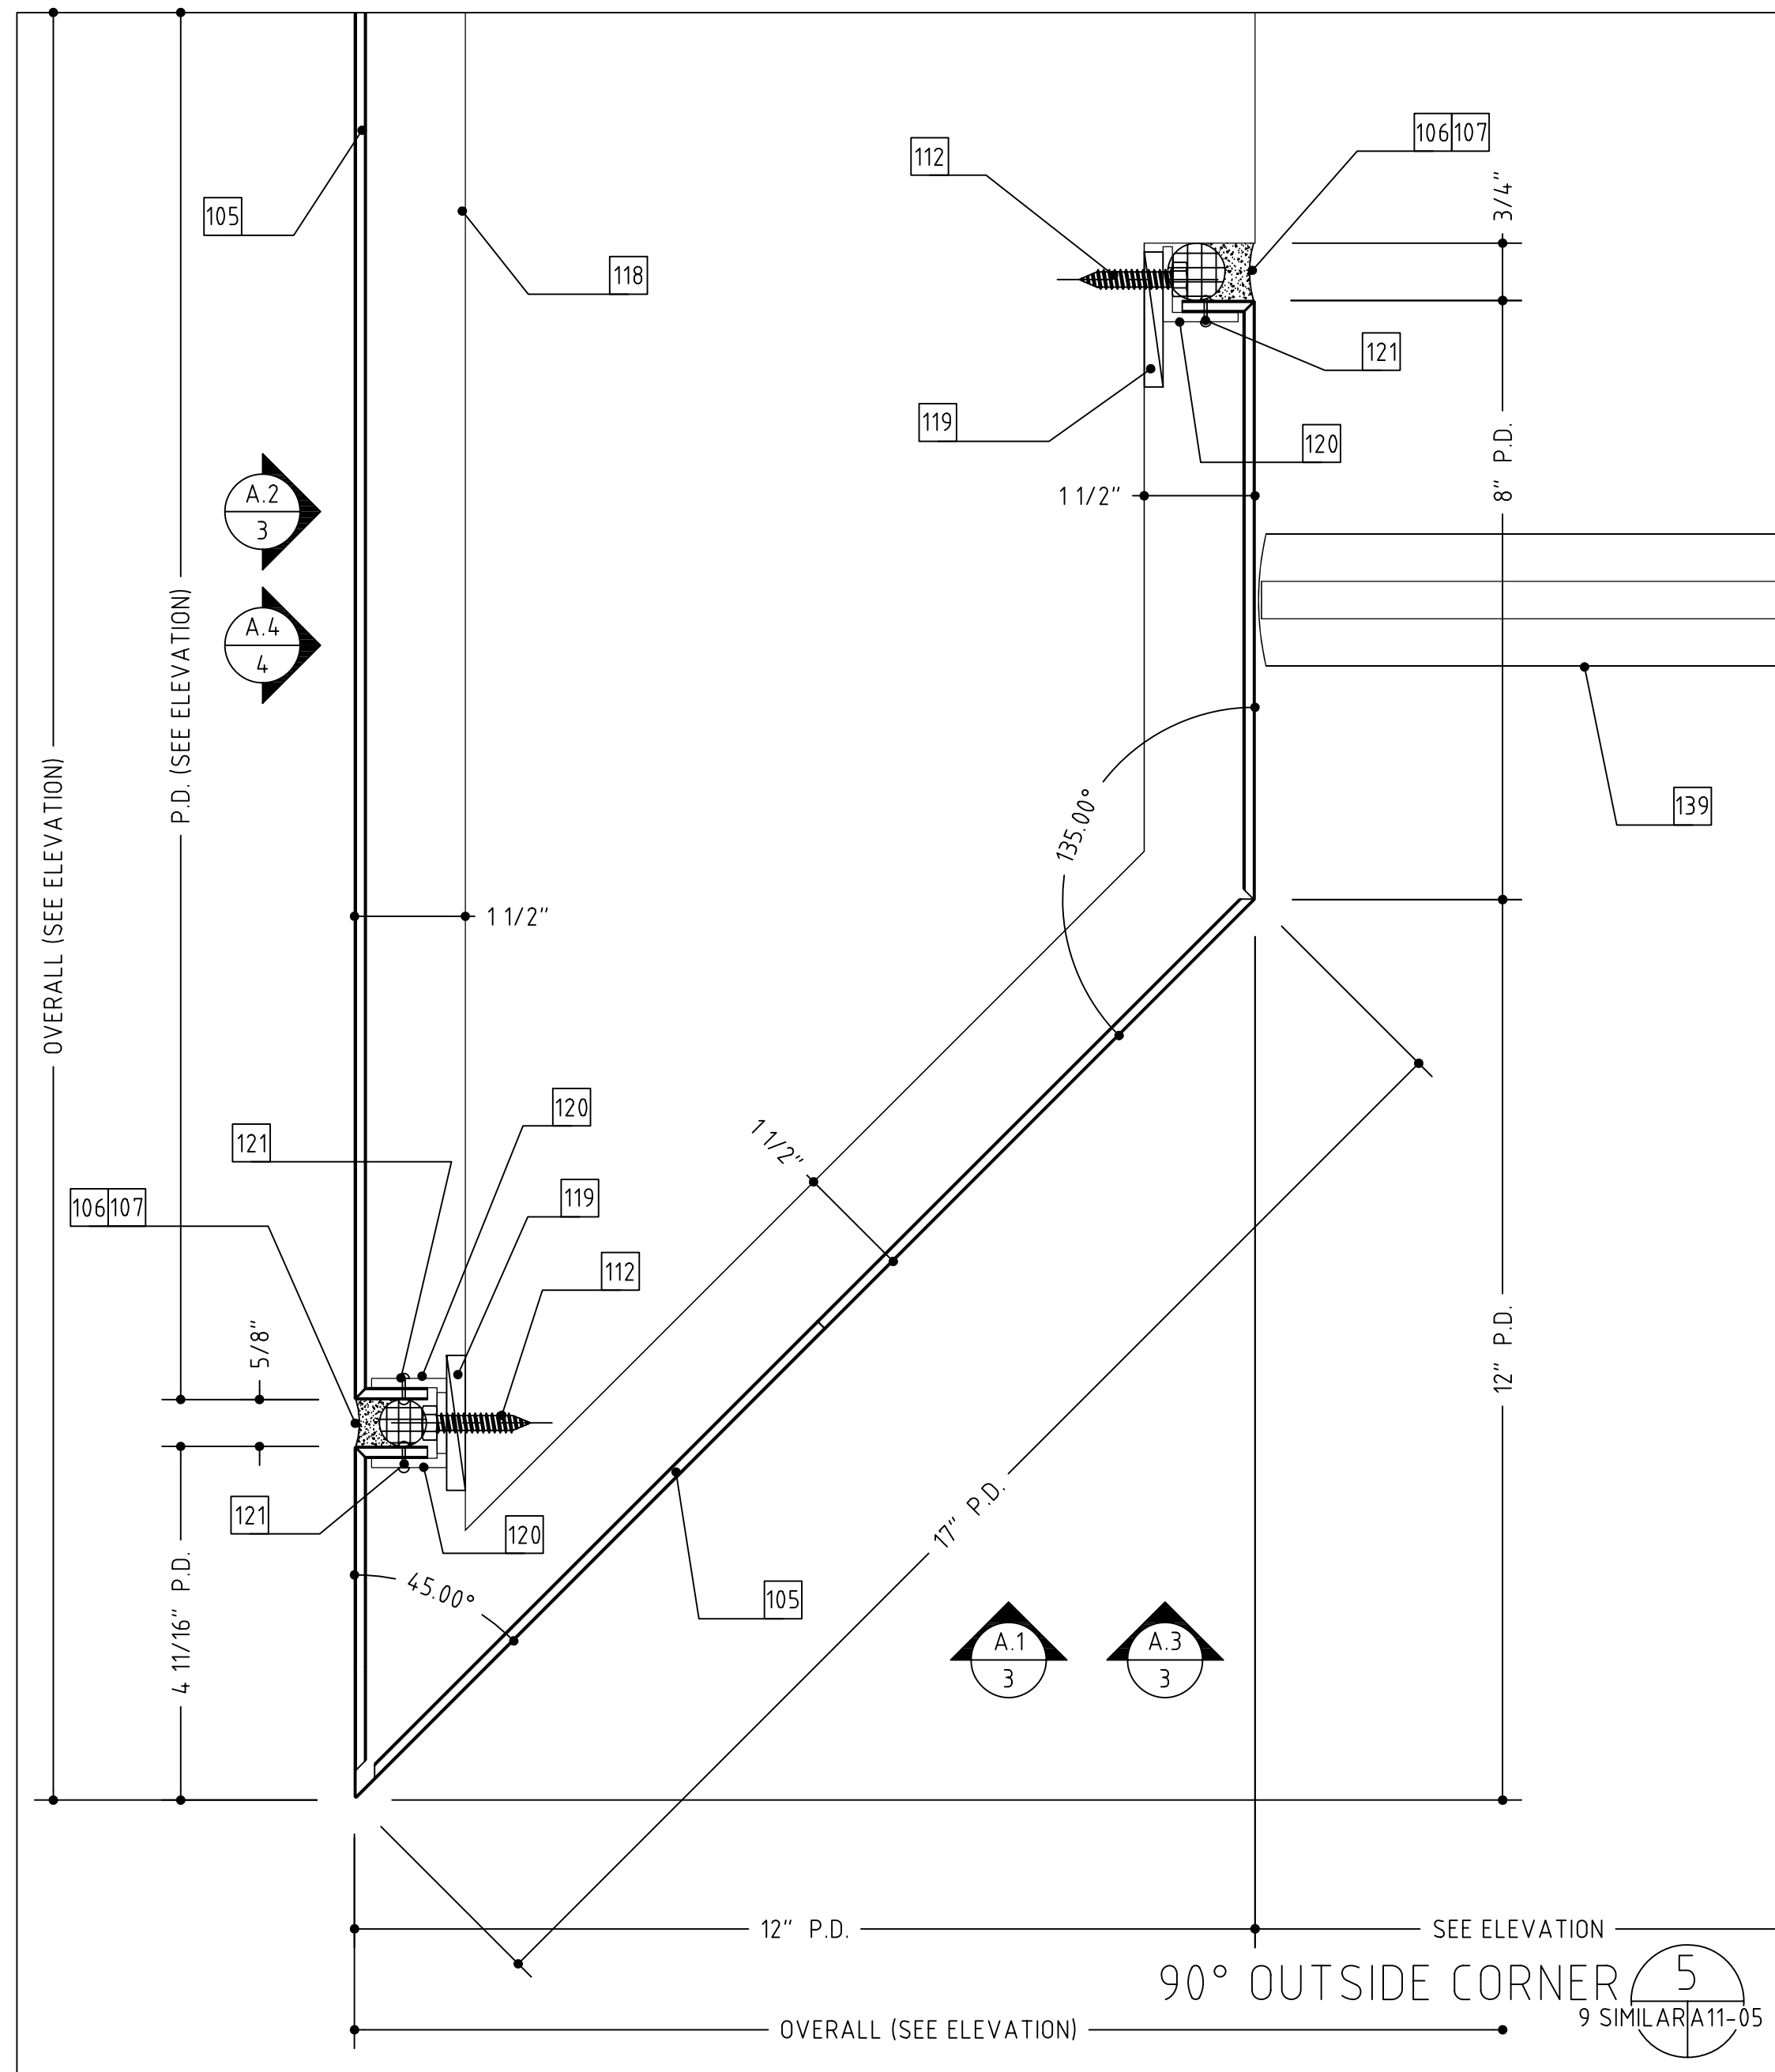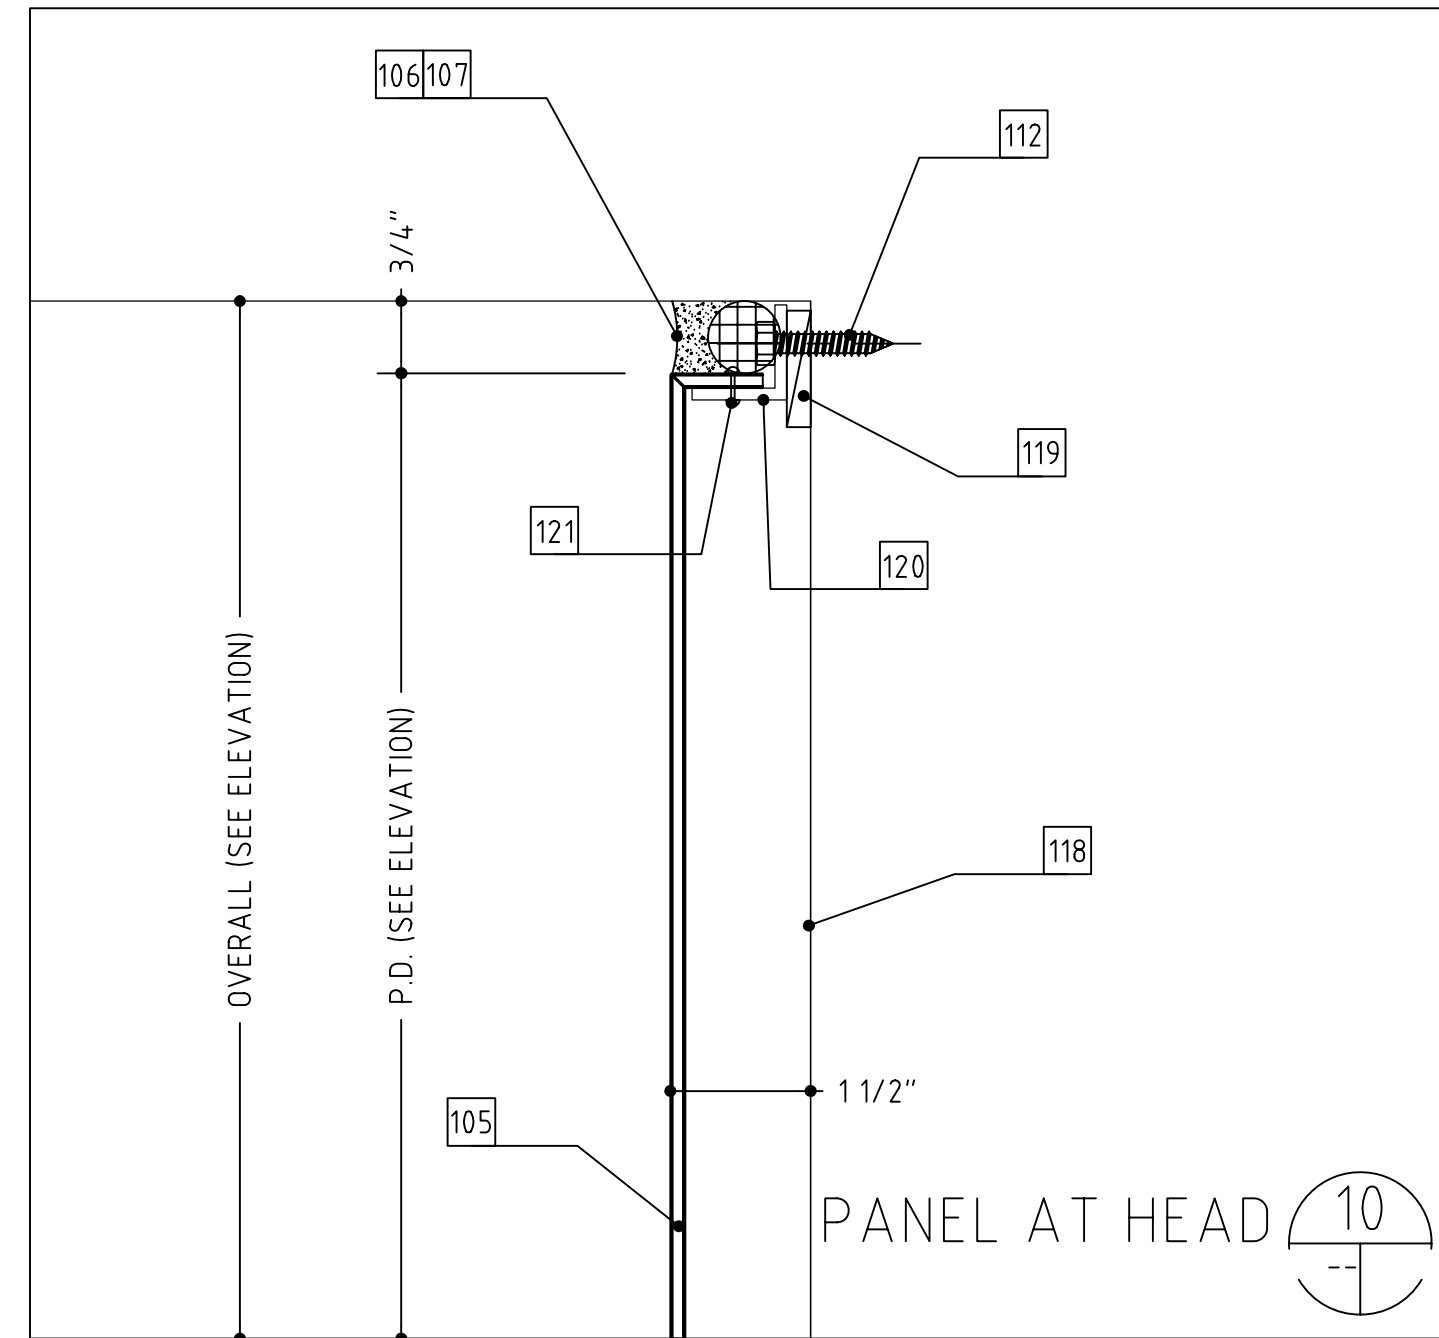

PANEL NOTES....




- 105 4mm REYNOBOND PANEL (SEE PANEL
SCHEDULE ON SHEET #1 FOR MORE
INFORMATION)
- 106 SEALANT NOT BY CAP
- 107 BACKING ROD, DENVER FOAM OR BOND
BREAKER TAPE NOT BY CAP
- 110 ALUMINUM FLASHING NOT BY CAP
- 112 FASTENER NOT BY CAP
- 113 COPING AND ATTACHMENT NOT BY CAP
- 118 SLIGHTLY THICKENED LINE INDICATES
PERIMETER CONSTRUCTION NOT BY CAP
- 119 SHIMS (SHIM AS NEEDED) NOT BY CAP
- 120 ALUMINUM CLIP ANGLE (INTERMITTENT
UNLESS NOTED OTHERWISE) FURNISHED
ONLY BY CAP IN STOCK LENGTHS
- 121 RIVET CONNECTION BETWEEN PANEL
AND ALUMINUM ANGLE (RIVET BY CAP),
ACTUAL CONNECTION NOT BY CAP
- 122 CURTAINWALL FRAMING NOT BY CAP
- 123 CAULK NOT BY CAP
- 124 ROOF CONSTRUCTION NOT BY CAP
- 139 DOOR AND/OR SIDELITE NOT BY CAP


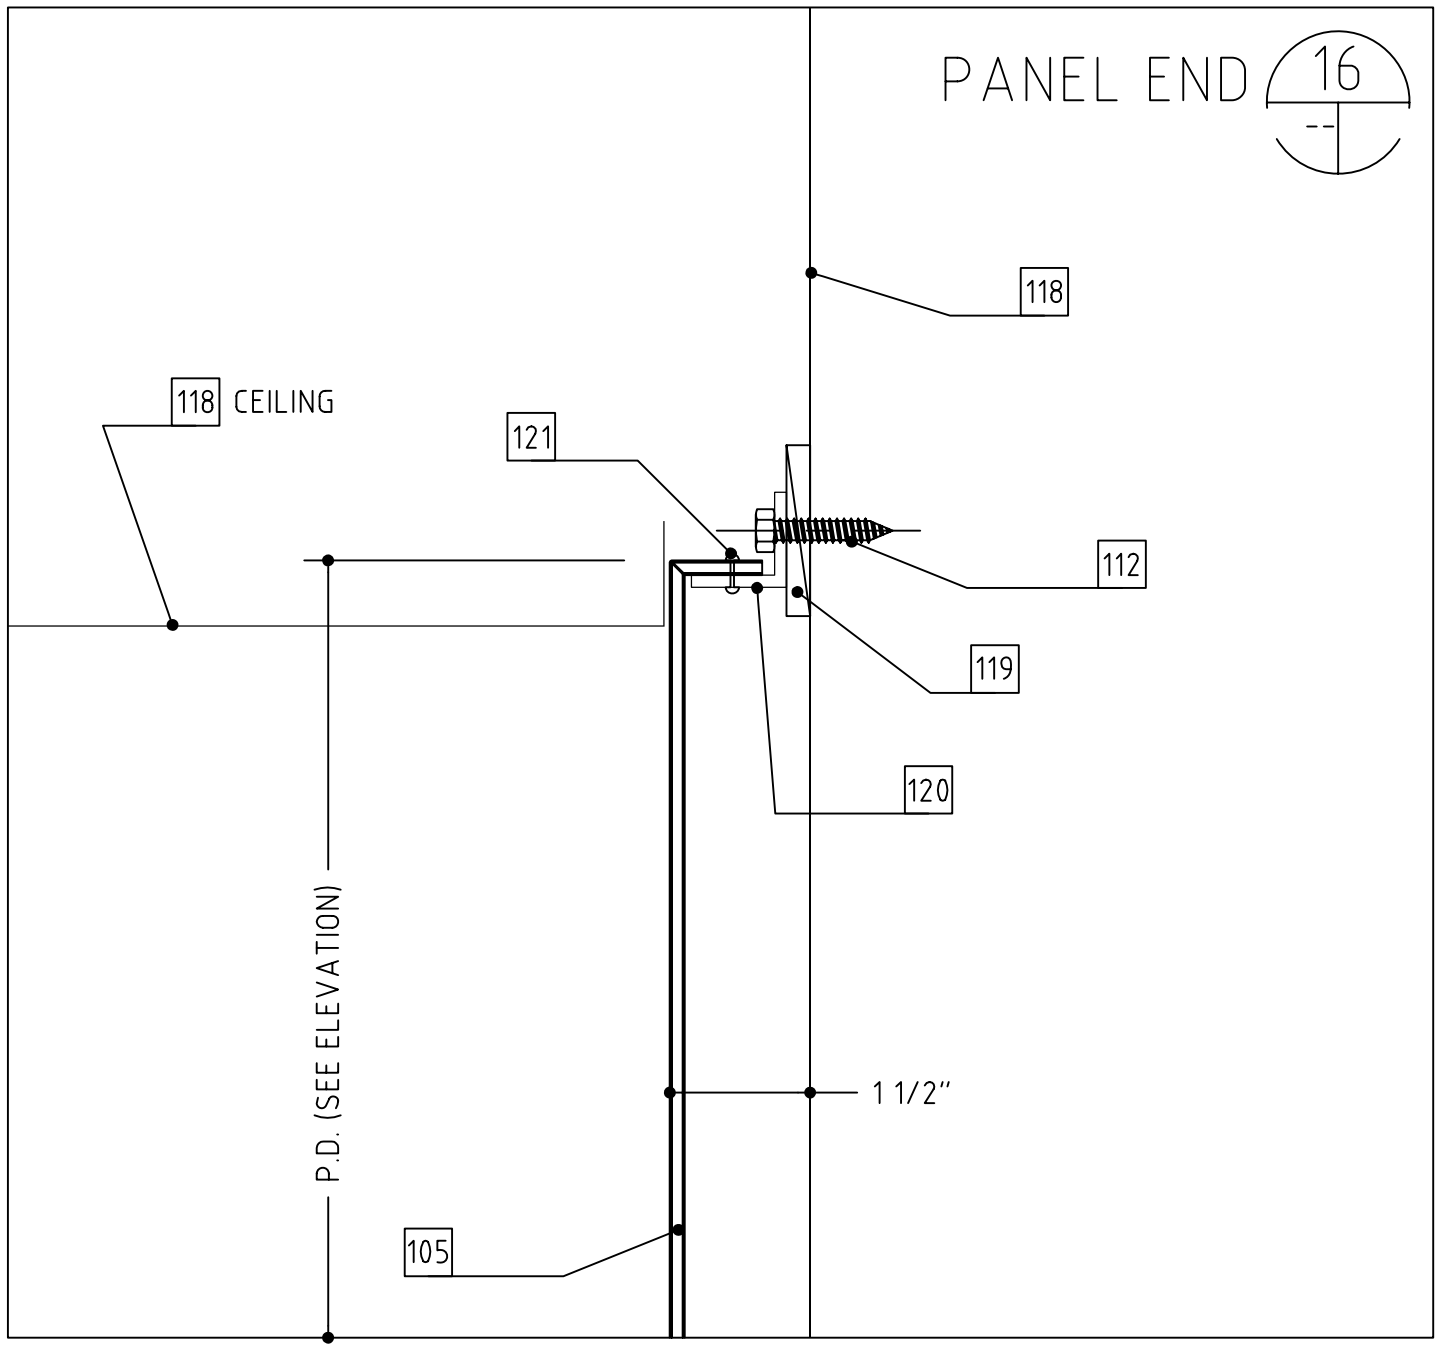
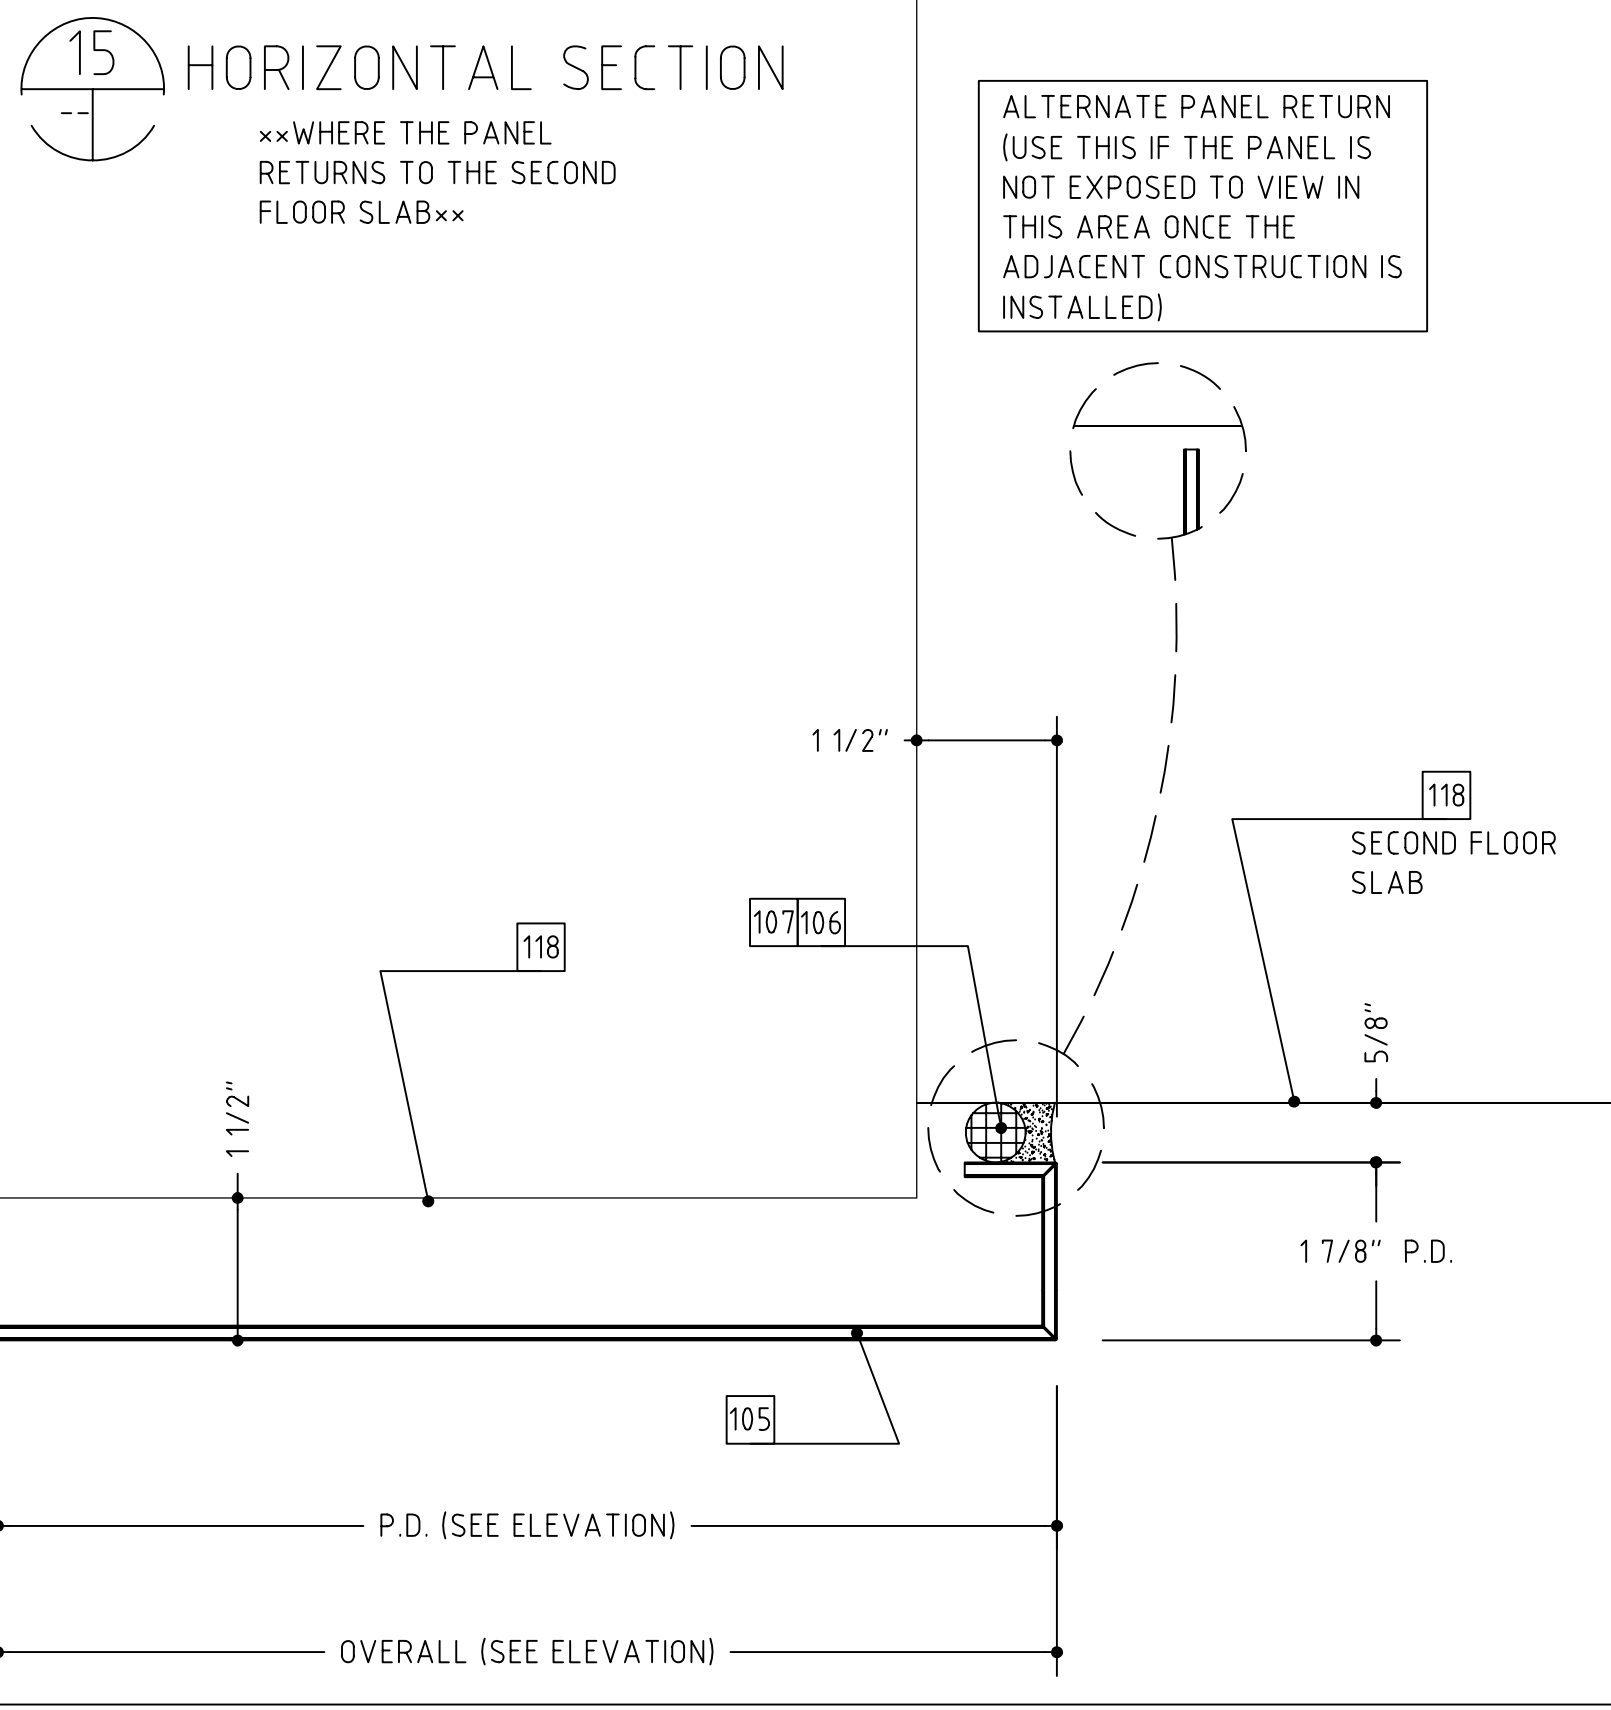
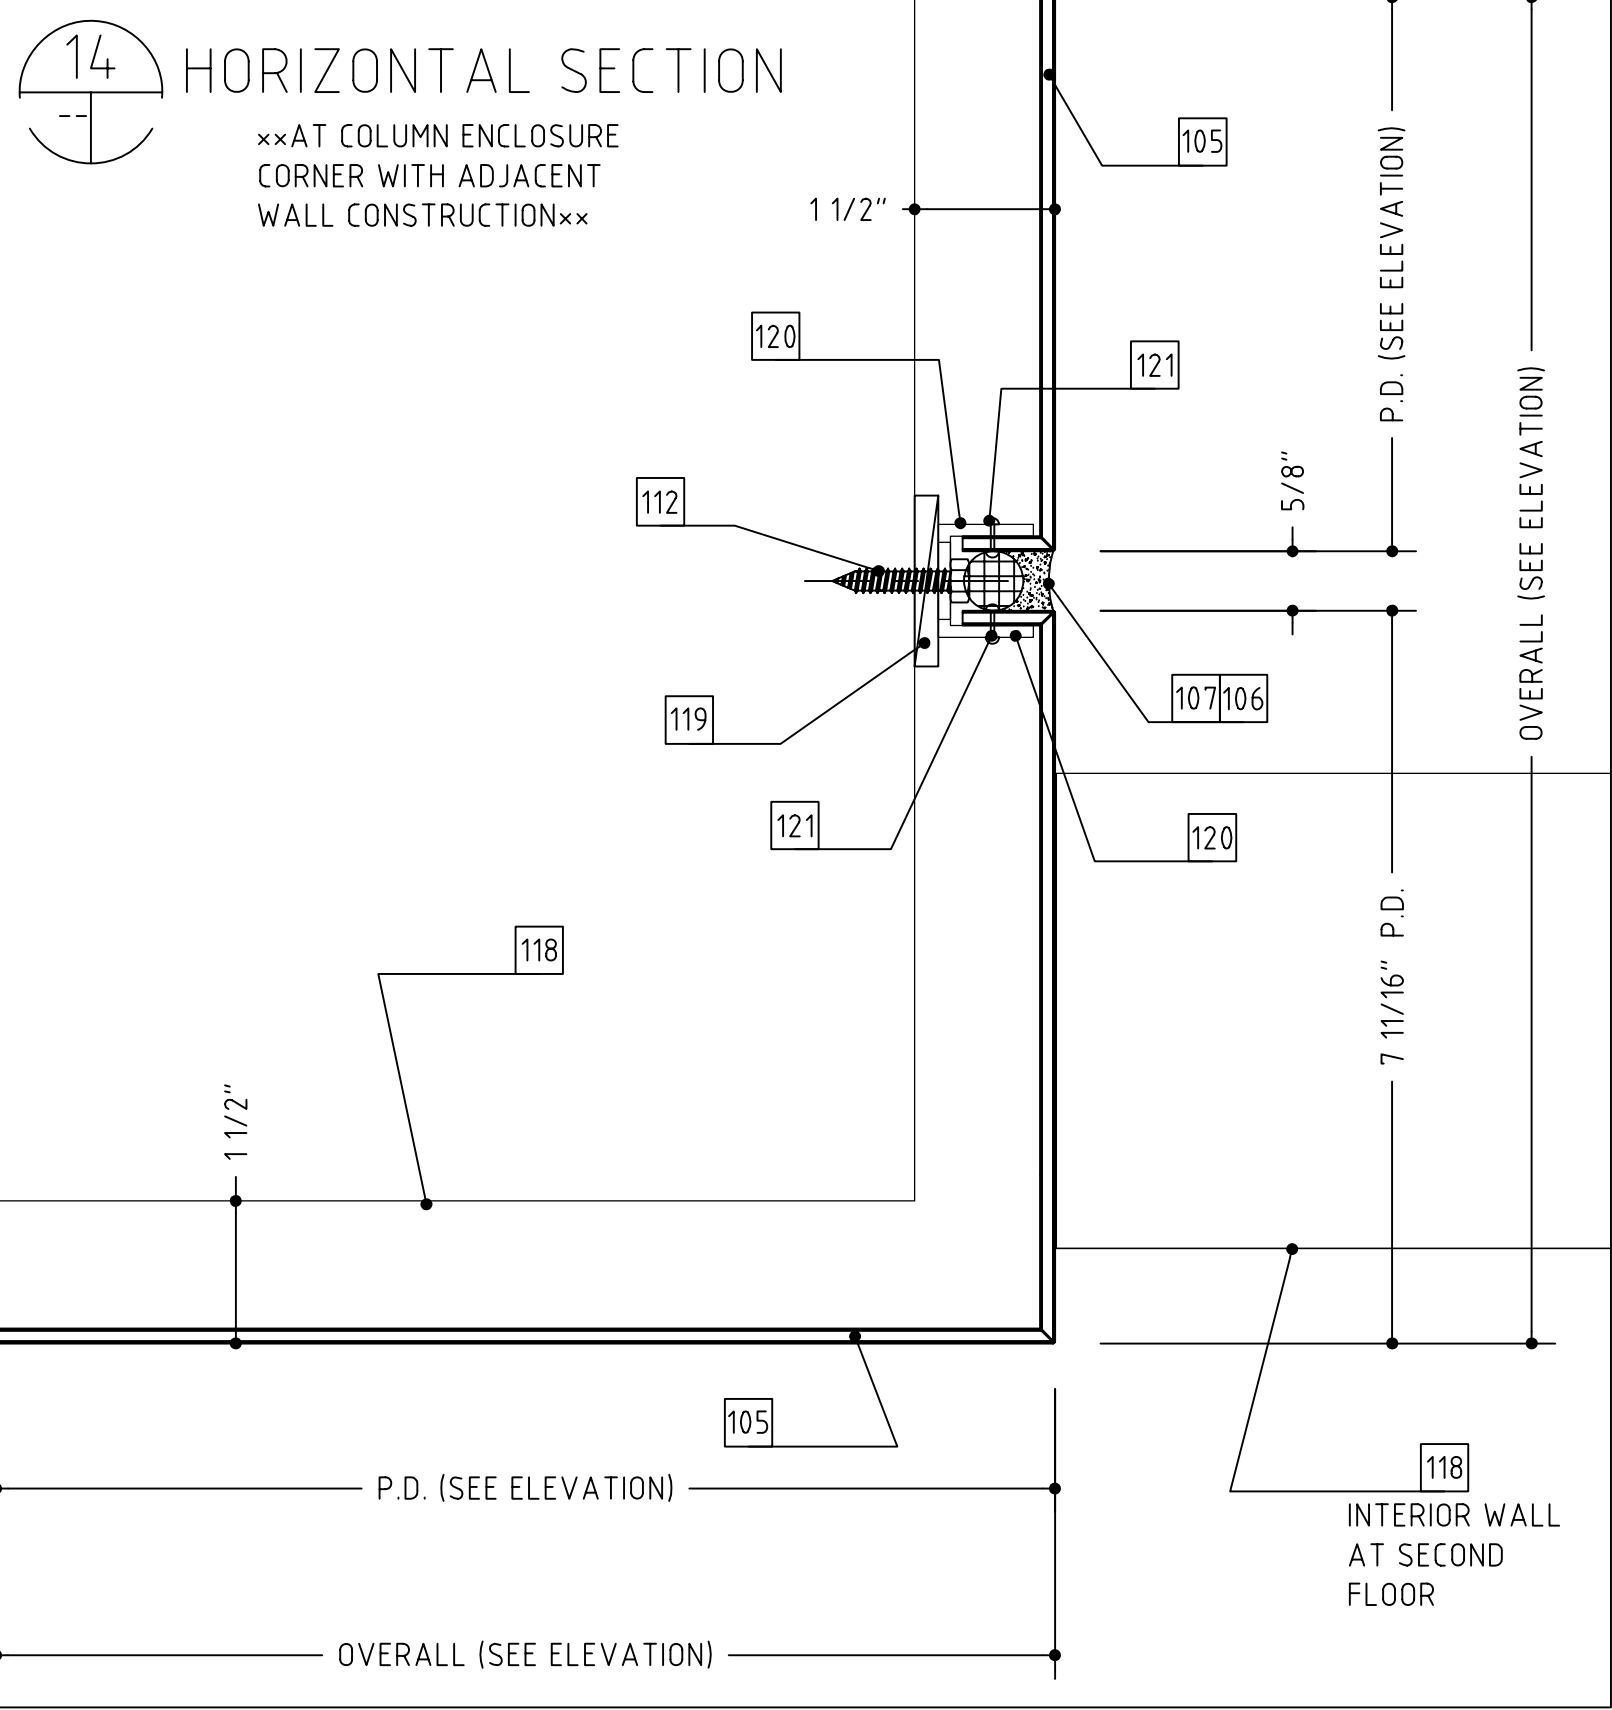


- PANEL NOTES.....
- 105 4mm REYNOBOND PANEL (SEE PANEL SCHEDULE ON SHEET #1 FOR MORE INFORMATION)
 - 106 SEALANT NOT BY CAP
 - 107 BACKING ROD, DENVER FOAM OR BOND BREAKER TAPE NOT BY CAP
 - 110 ALUMINUM FLASHING NOT BY CAP
 - 112 FASTENER NOT BY CAP
 - 113 COPING AND ATTACHMENT NOT BY CAP
 - 118 SLIGHTLY THICKENED LINE INDICATES PERIMETER CONSTRUCTION NOT BY CAP
 - 119 SHIMS (SHIM AS NEEDED) NOT BY CAP
 - 120 ALUMINUM CLIP ANGLE (INTERMITTENT UNLESS NOTED OTHERWISE) FURNISHED ONLY BY CAP IN STOCK LENGTHS
 - 121 RIVET CONNECTION BETWEEN PANEL AND ALUMINUM ANGLE (RIVET BY CAP), ACTUAL CONNECTION NOT BY CAP
 - 122 CURTAINWALL FRAMING NOT BY CAP
 - 123 CAULK NOT BY CAP
 - 124 ROOF CONSTRUCTION NOT BY CAP
 - 139 DOOR AND/OR SIDELITE NOT BY CAP

FABRICATION RELEASE:

THE PANEL DIMENSIONS HAVE BEEN REVIEWED AND APPROVED AS NOTED ON THIS DRAWING. THE PANELS ARE HEREBY RELEASED FOR FABRICATION.

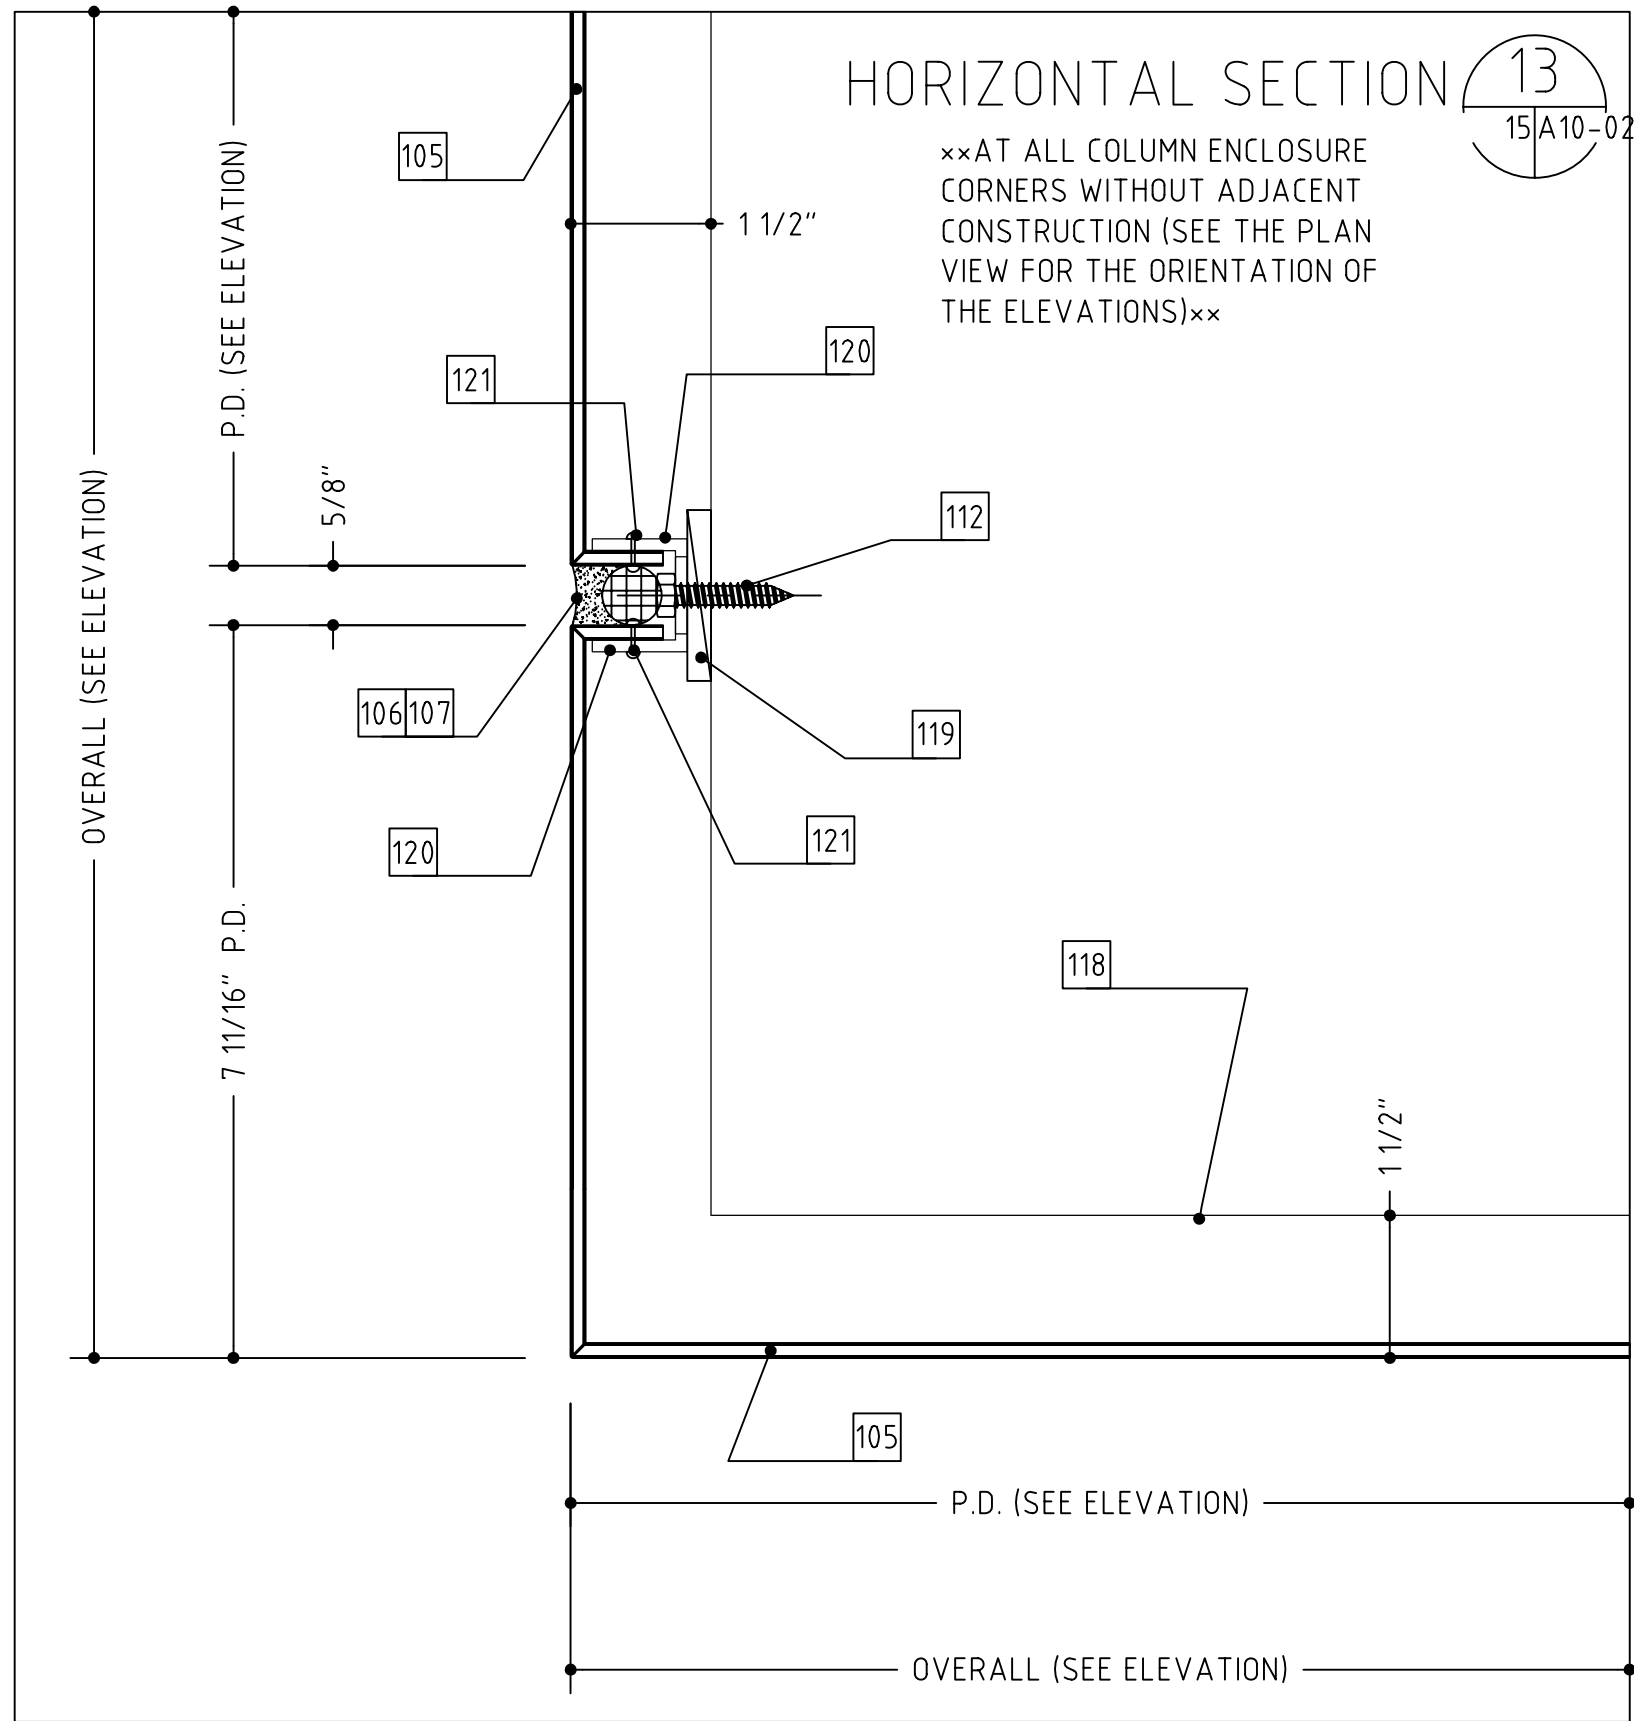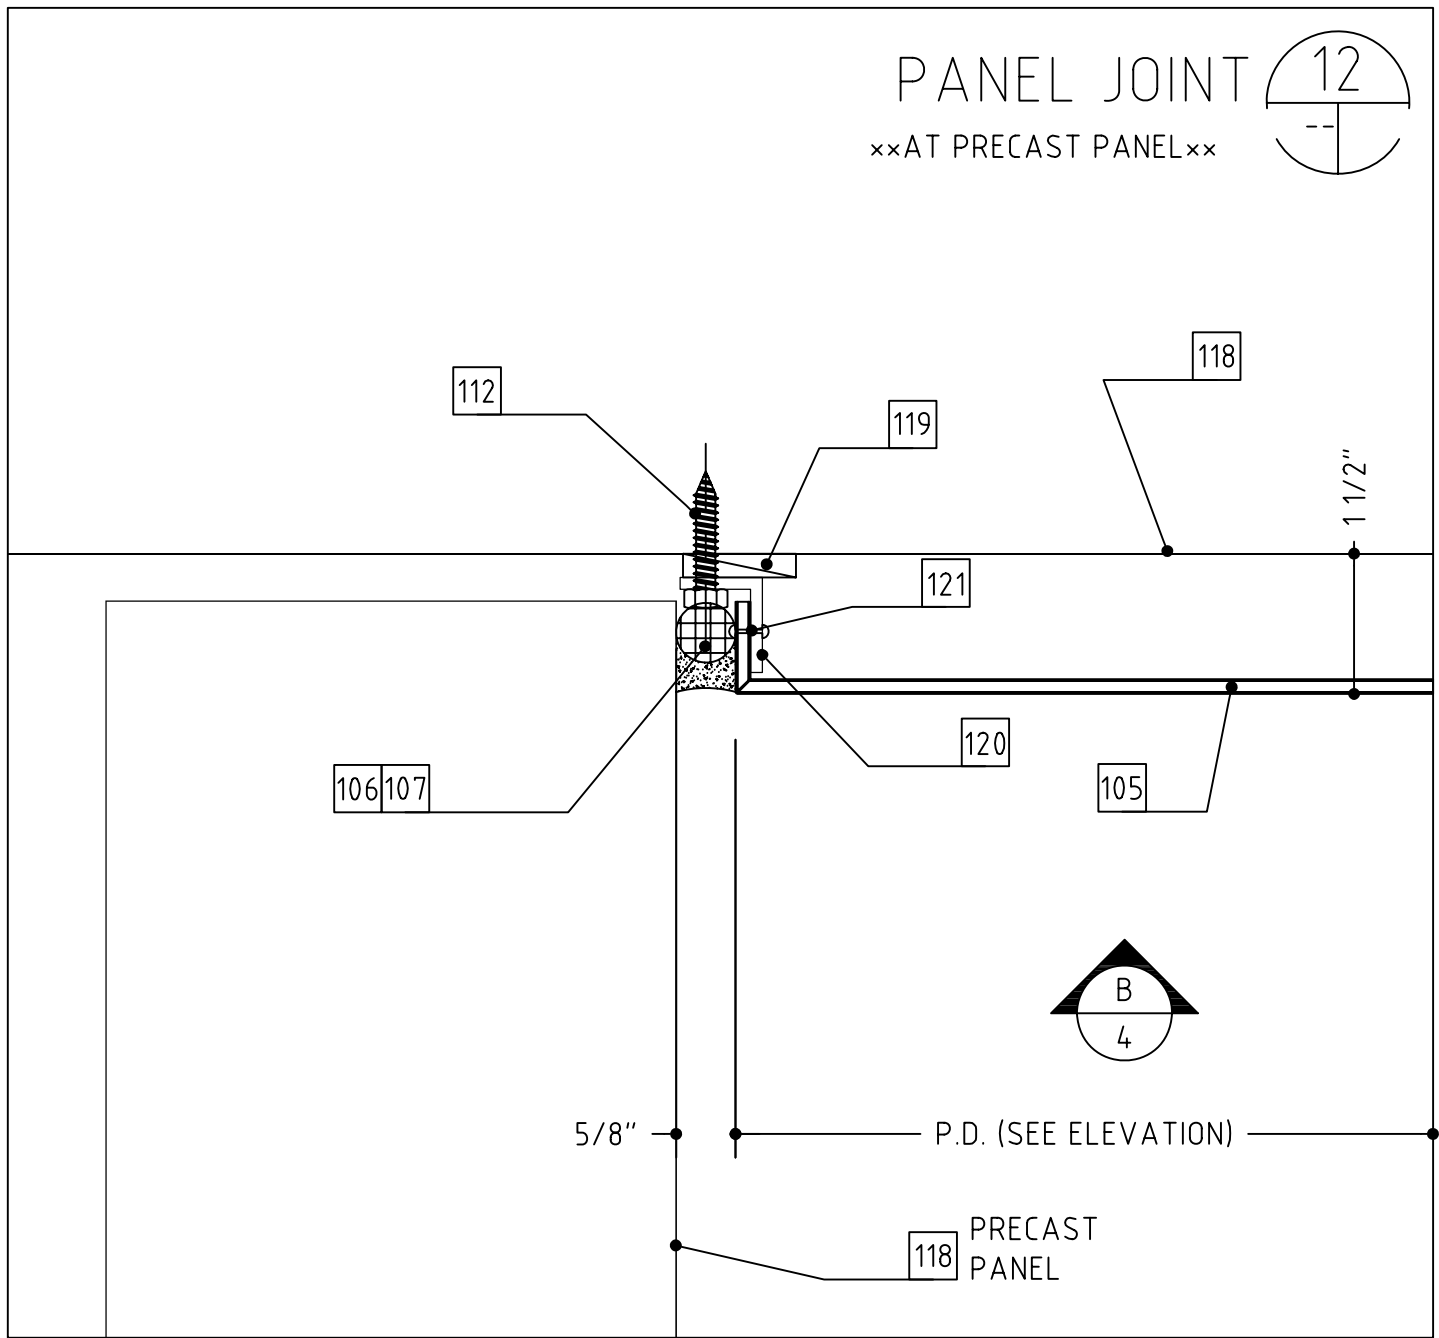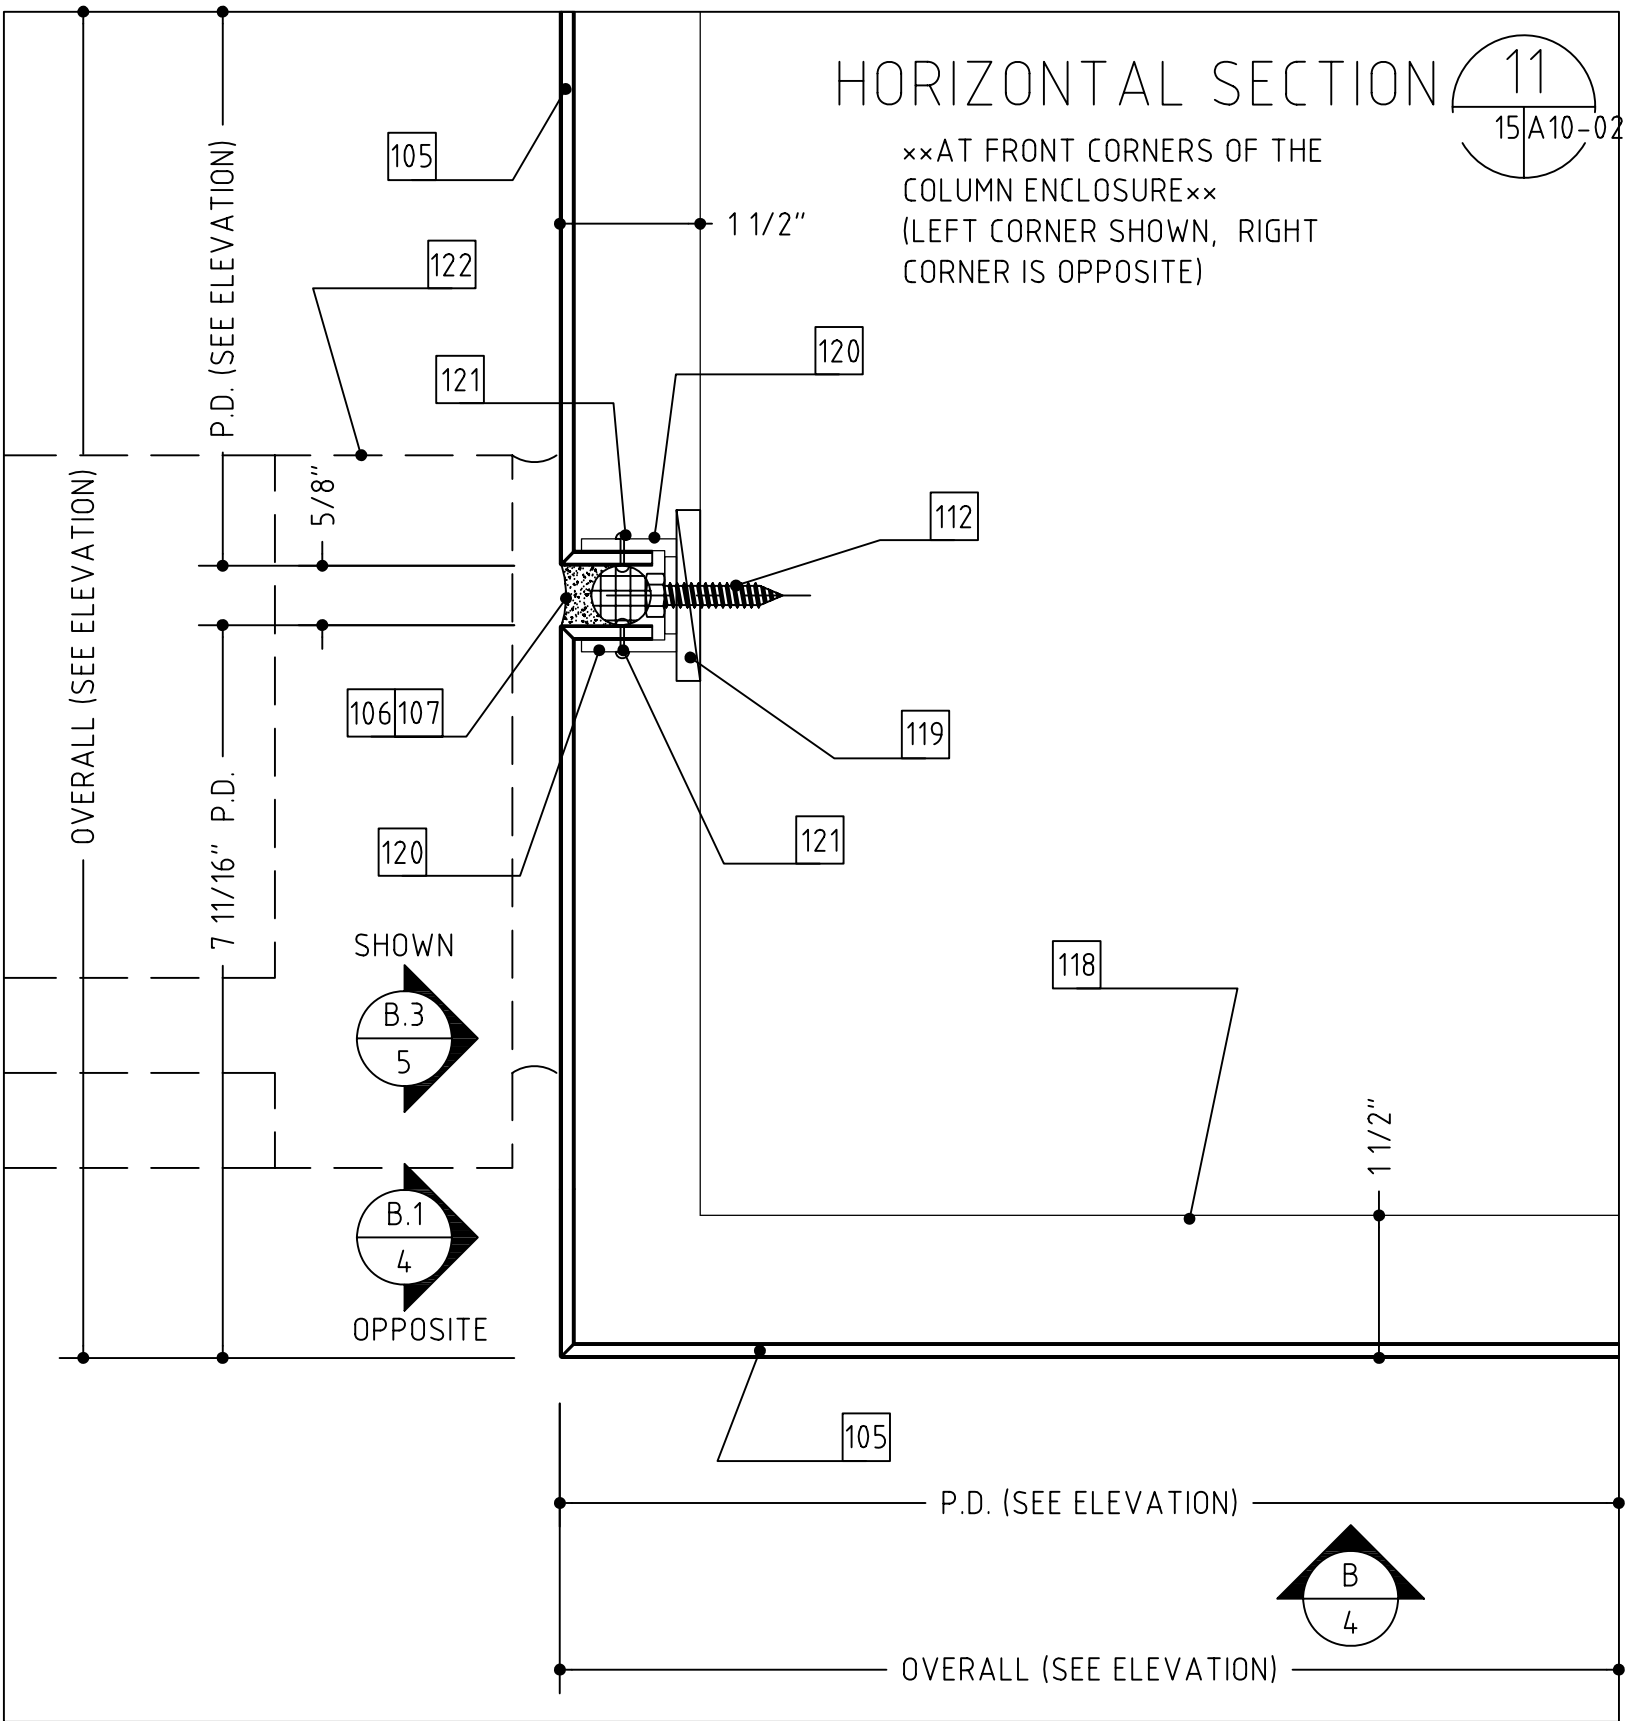

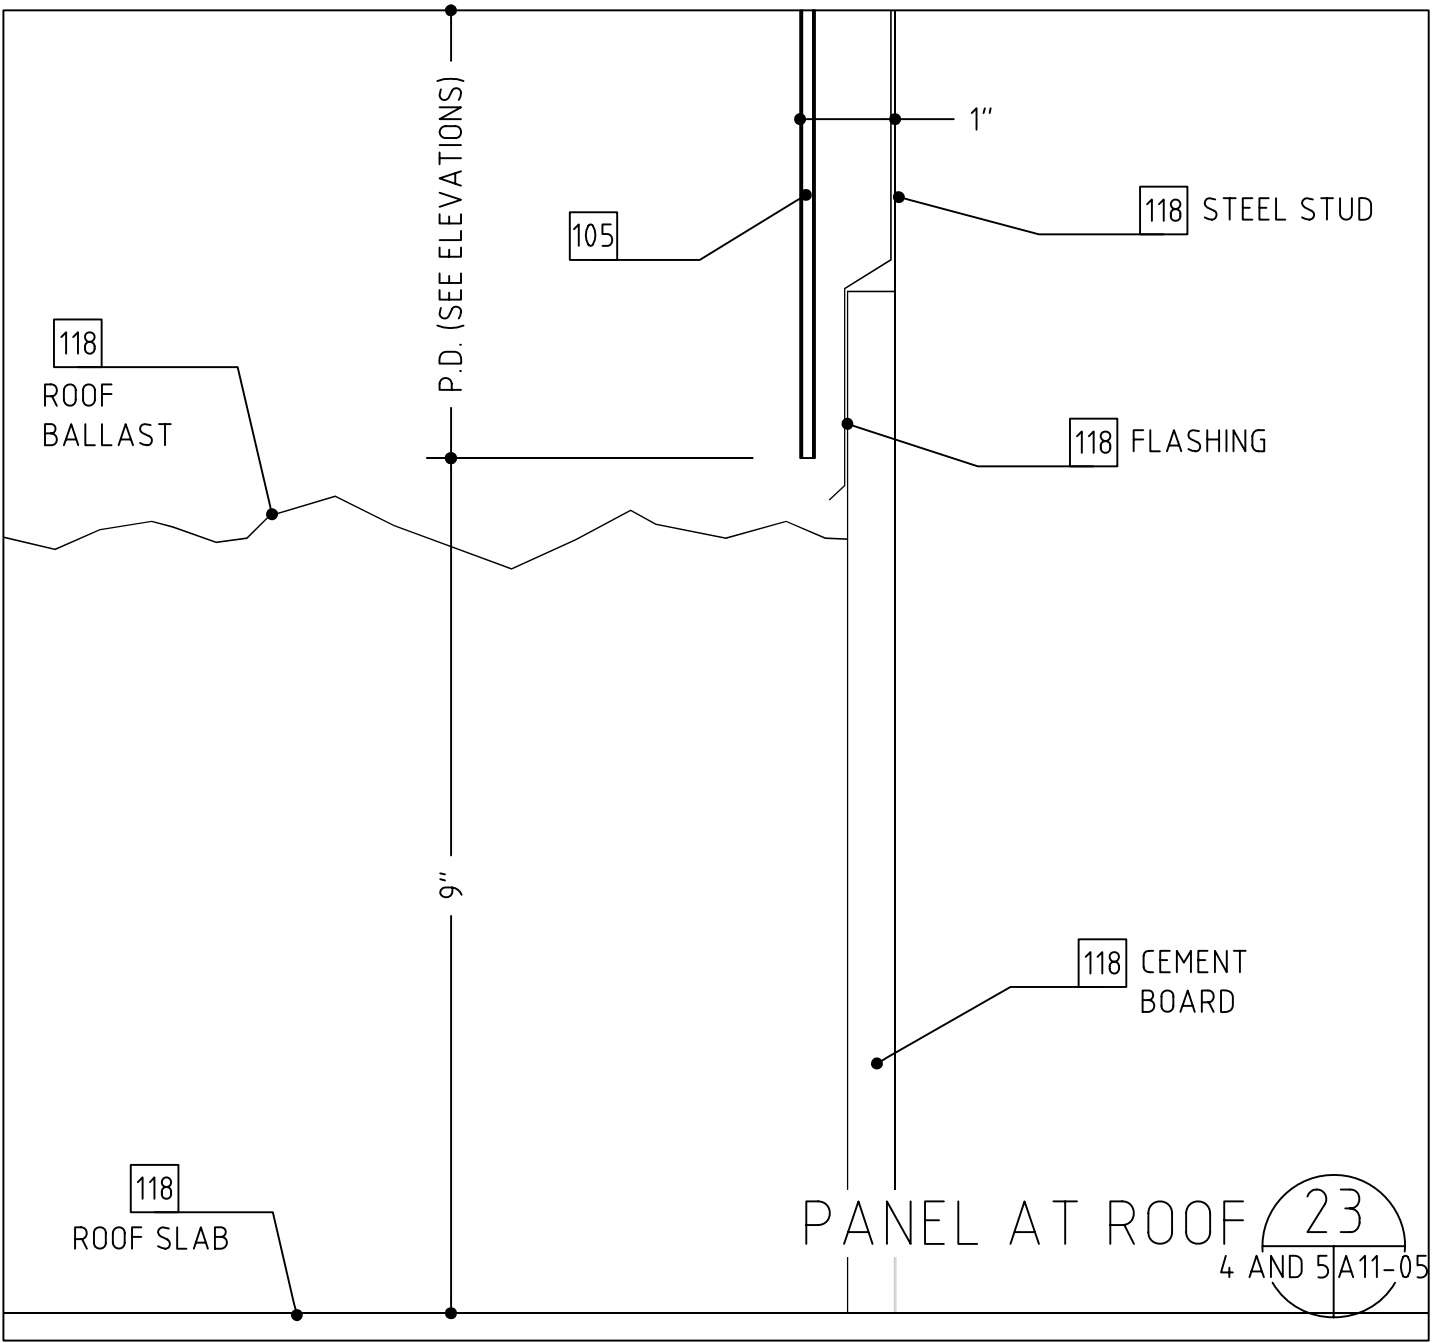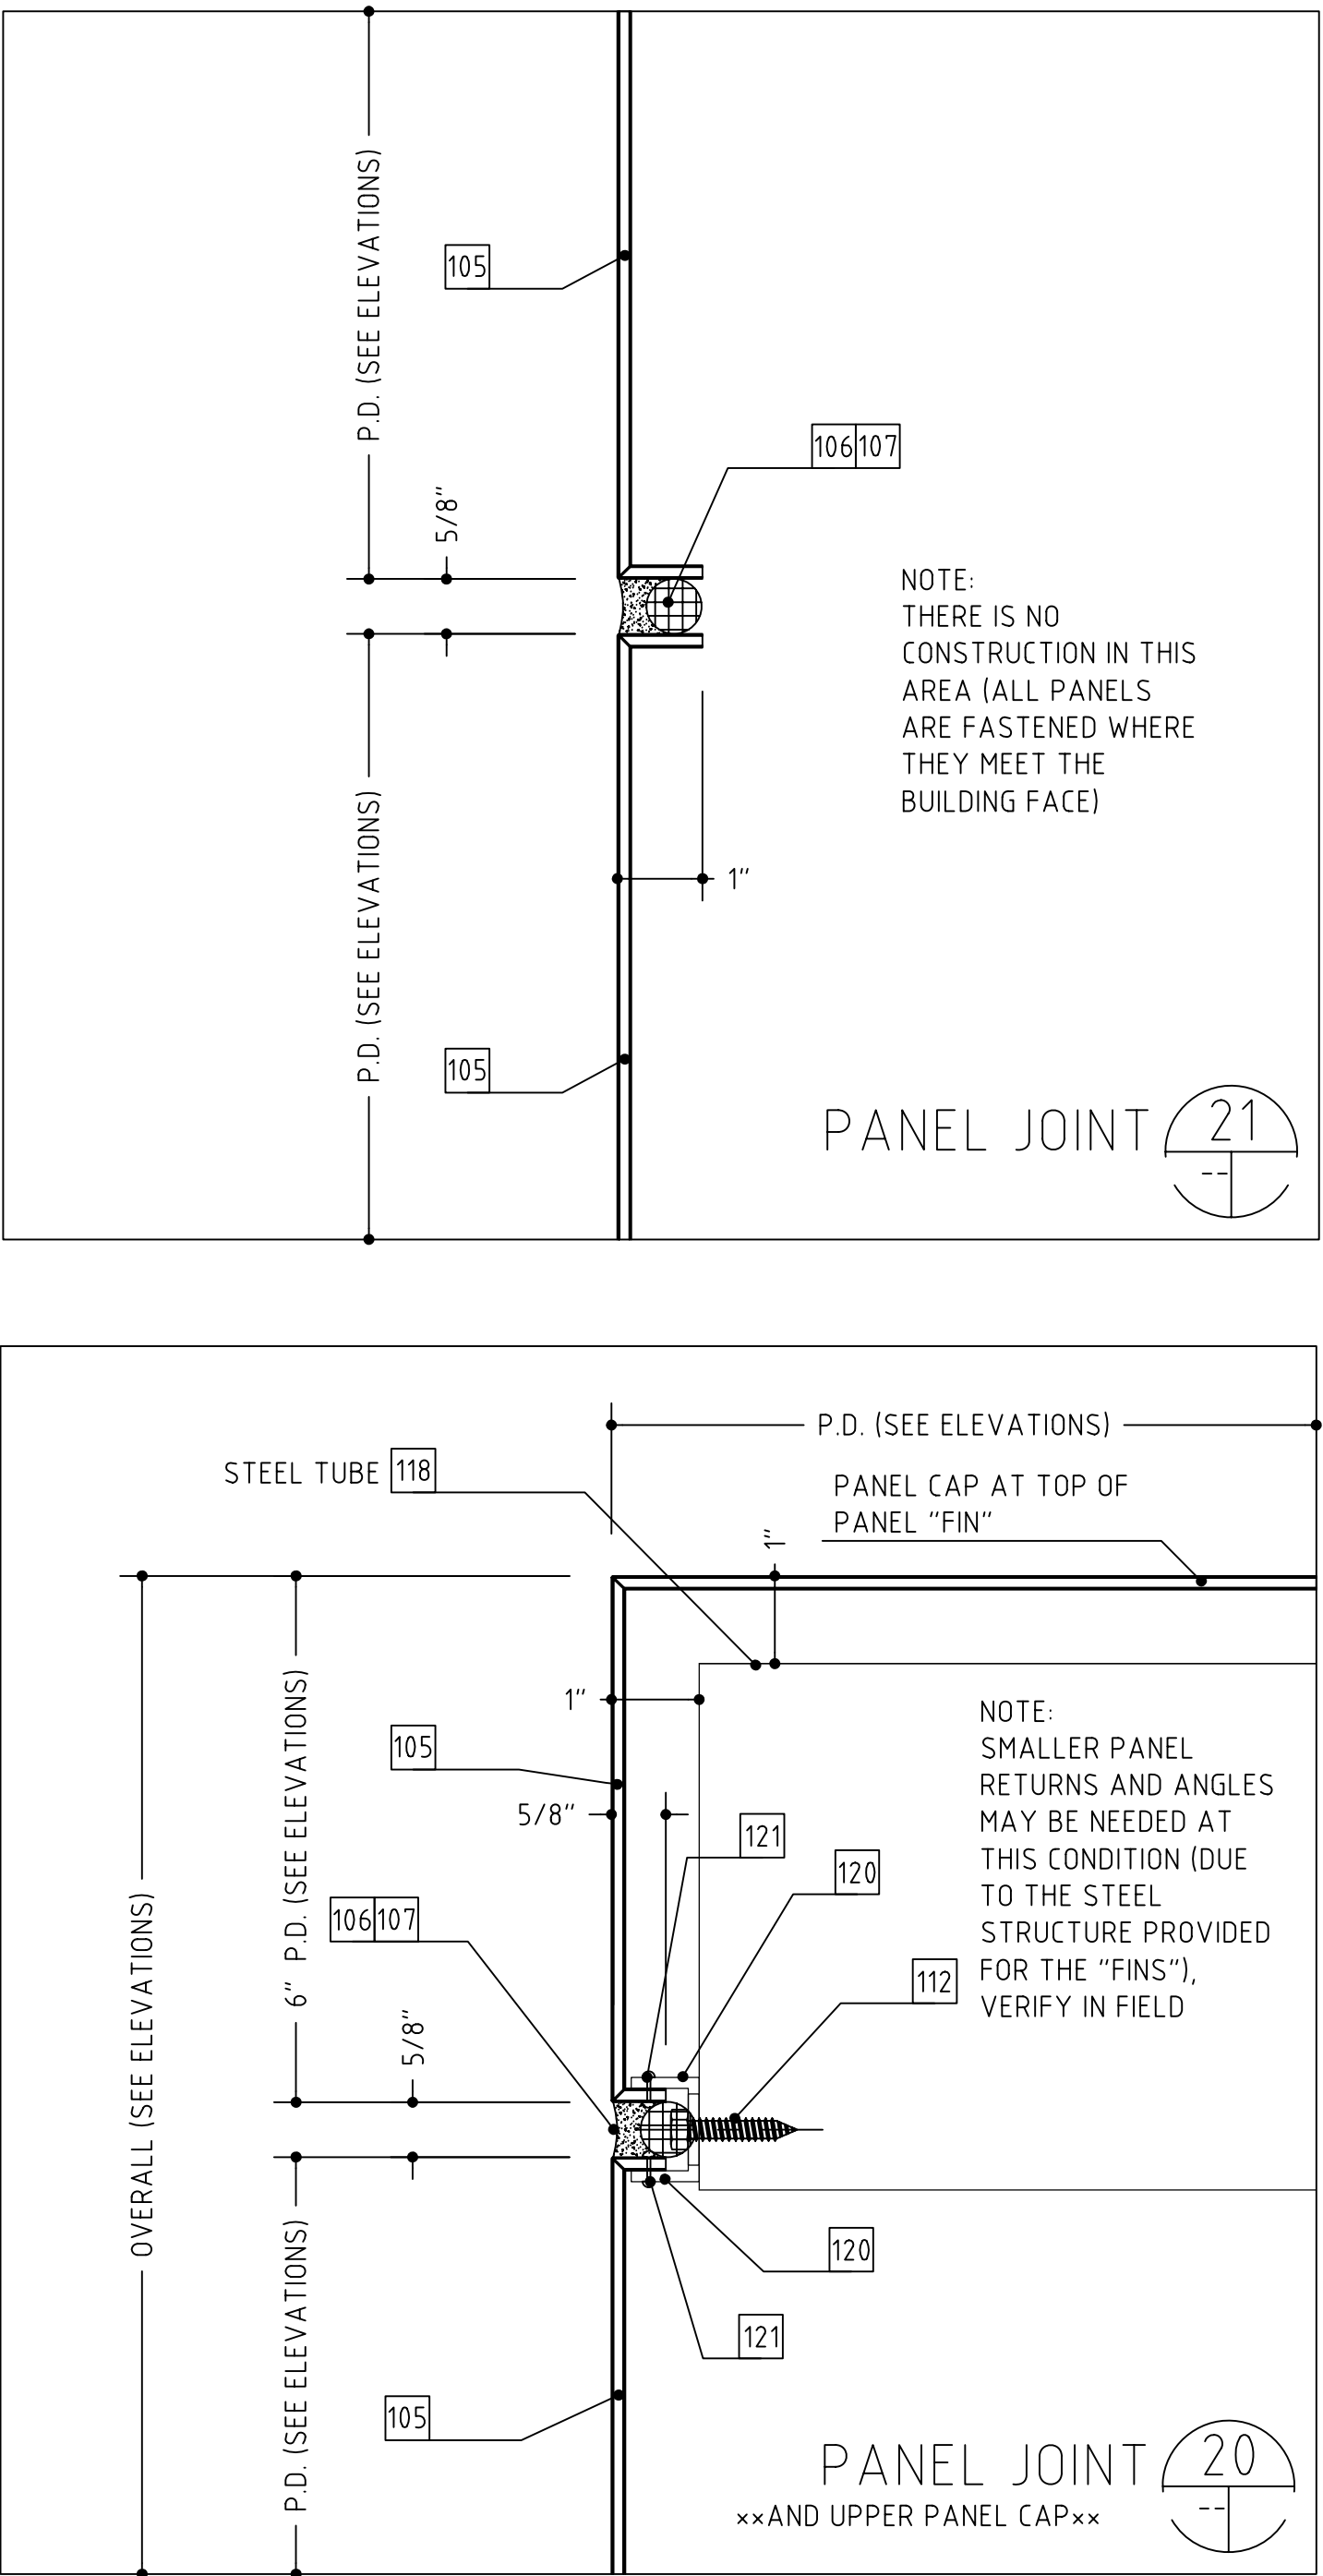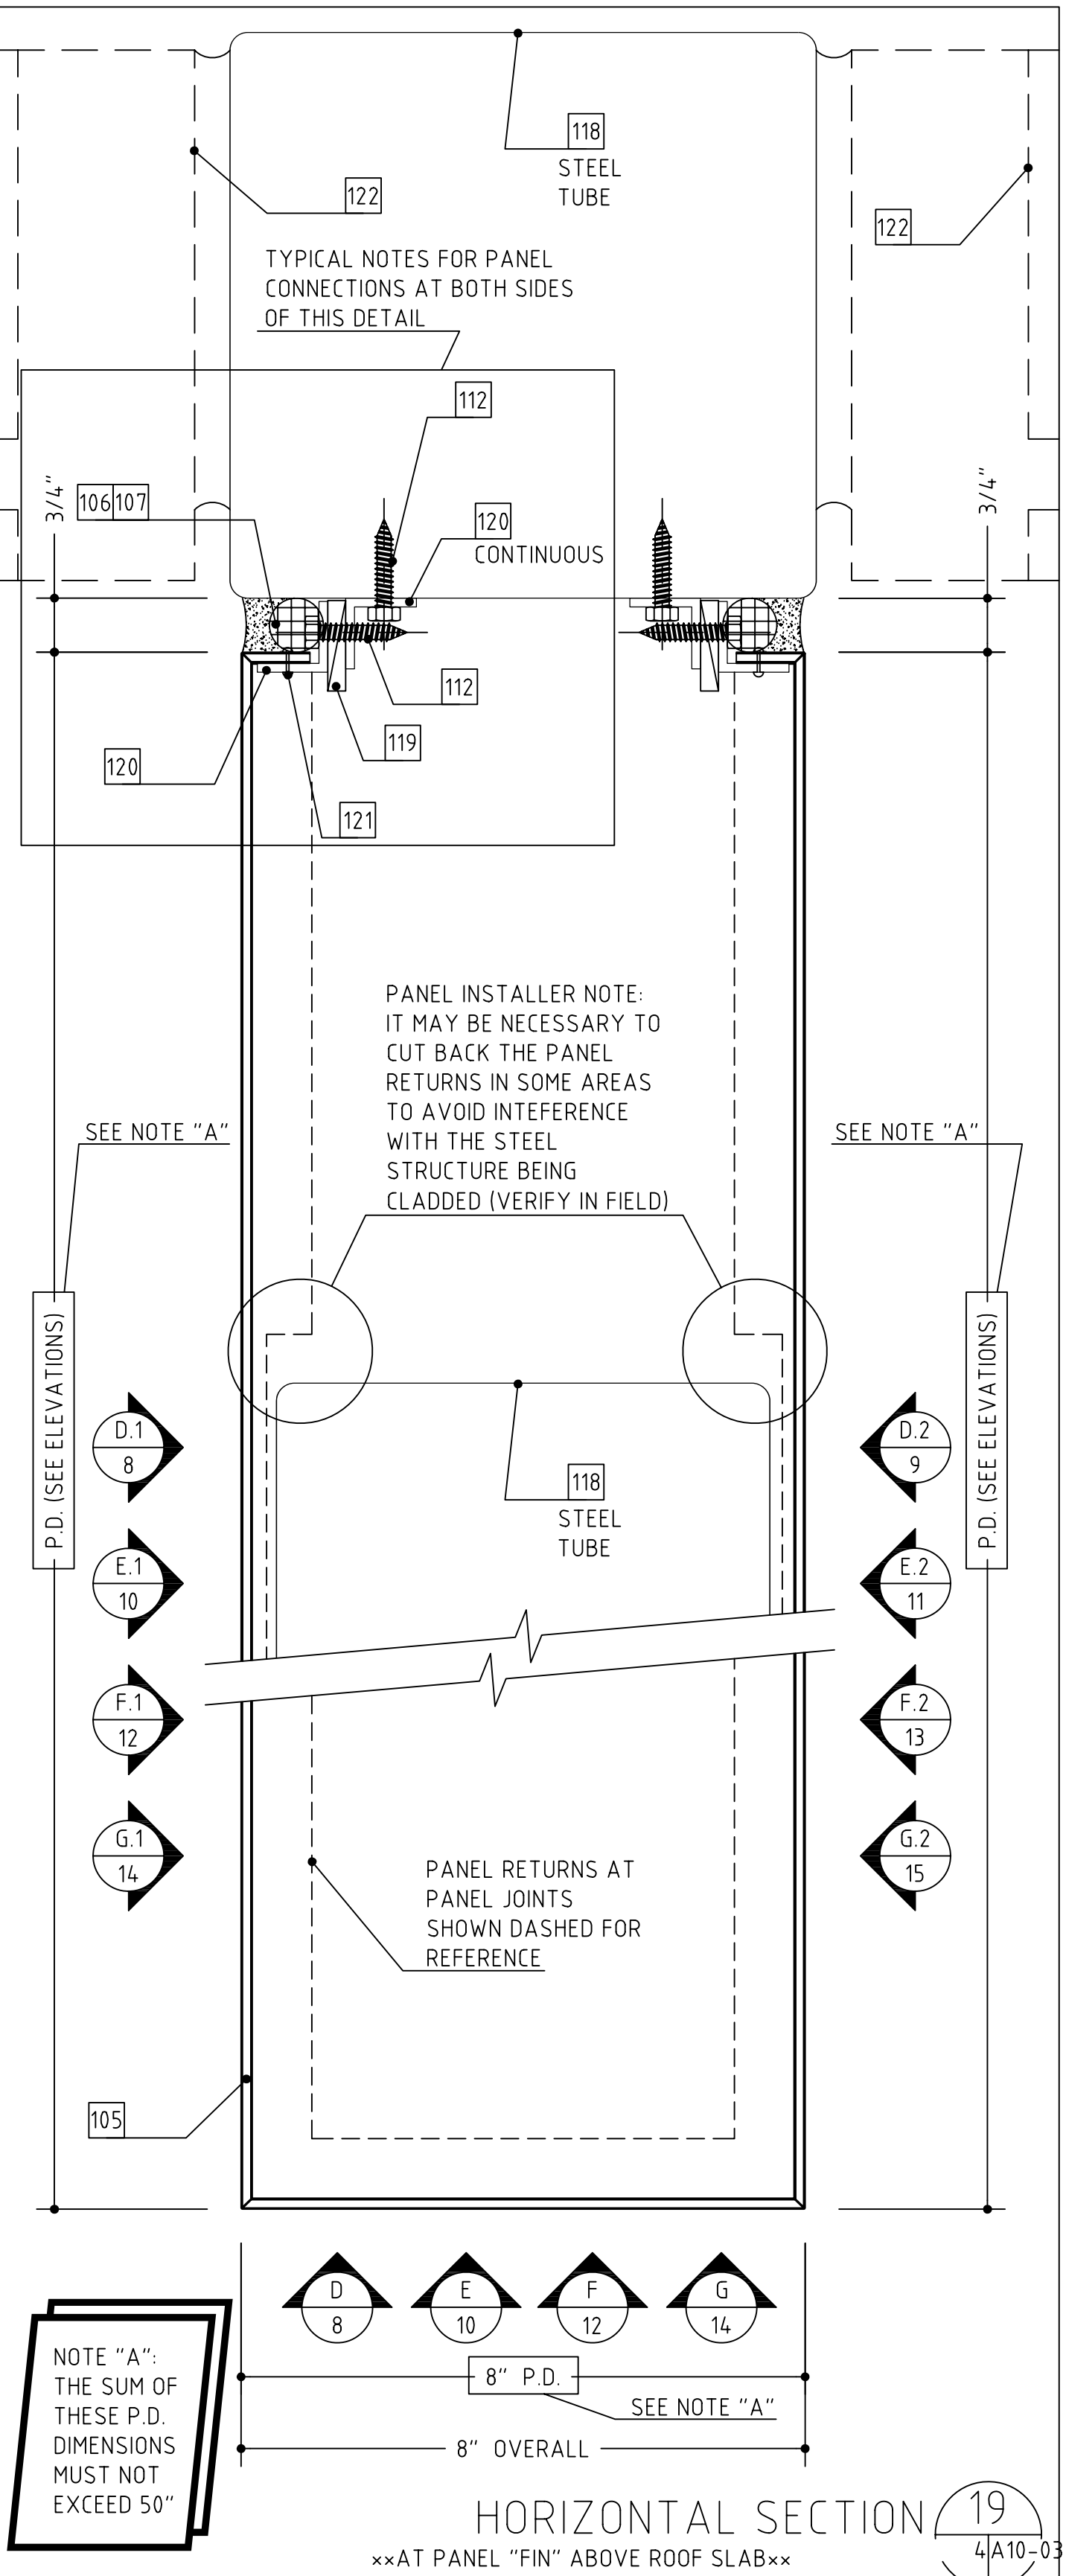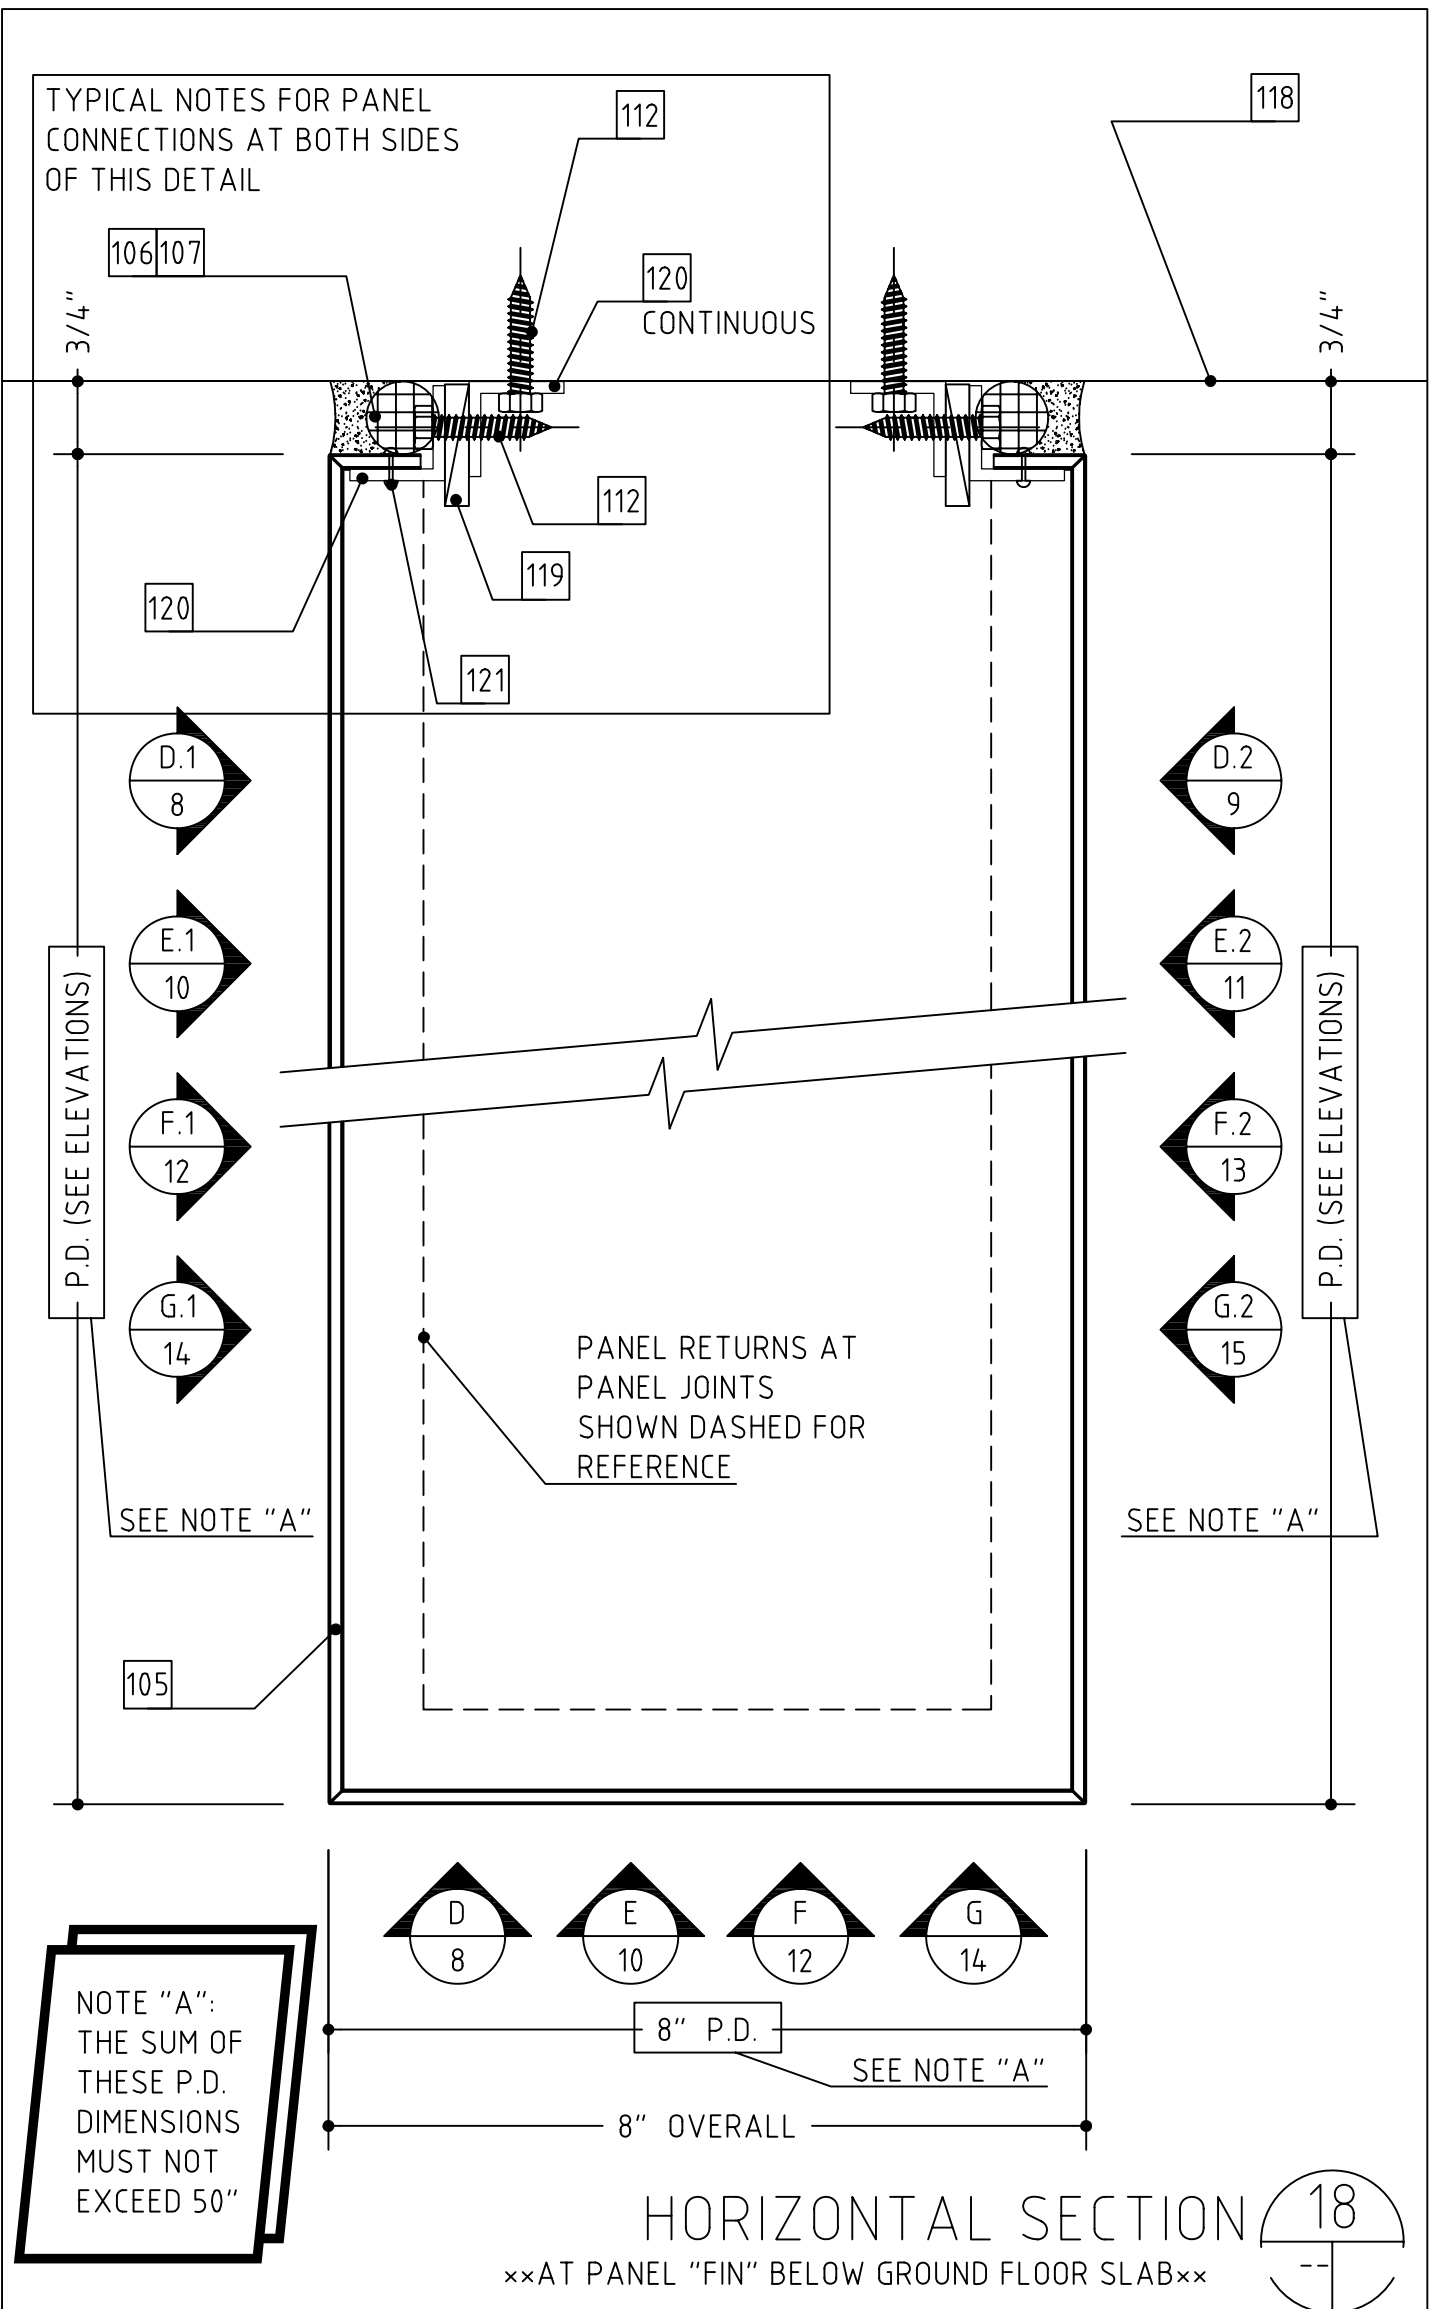

PANEL NOTES.....	
109	4mm REYNOLDBOND PANEL (SEE PANEL SCHEDULE ON SHEET #1 FOR MORE INFORMATION)
109	SEALANT NOT BY CAP
107	BACKING ROD, DENVER FOAM OR BOND BREAKER TAPE NOT BY CAP
110	ALUMINUM FLASHING NOT BY CAP
112	FASTENER NOT BY CAP
113	COPING AND ATTACHMENT NOT BY CAP
118	SLIGHTLY THICKENED LINE INDICATES PERIMETER CONSTRUCTION NOT BY CAP
119	SHIMS (SHIM AS NEEDED) NOT BY CAP
120	ALUMINUM CLIP ANGLE (INTERMITTENT UNLESS NOTED OTHERWISE) FURNISHED ONLY BY CAP IN STOCK LENGTHS
121	RIVET CONNECTION BETWEEN PANEL AND ALUMINUM ANGLE (RIVET BY CAP), ACTUAL CONNECTION NOT BY CAP
122	CURTAINWALL FRAMING NOT BY CAP
123	CAULK NOT BY CAP
124	ROOF CONSTRUCTION NOT BY CAP
129	DOOR AND/OR SIDELITE NOT BY CAP

FABRICATION RELEASE:
THE PANEL DIMENSIONS HAVE BEEN REVIEWED AND
APPROVED AS NOTED ON THIS DRAWING. THE
PANELS ARE HEREBY RELEASED FOR FABRICATION.

- PANEL NOTES.....
- 105 4mm REYNOBOND PANEL (SEE PANEL SCHEDULE ON SHEET #1 FOR MORE INFORMATION)
 - 106 SEALANT NOT BY CAP
 - 107 BACKING ROD, DENVER FOAM OR BOND BREAKER TAPE NOT BY CAP
 - 110 ALUMINUM FLASHING NOT BY CAP
 - 112 FASTENER NOT BY CAP
 - 113 COPING AND ATTACHMENT NOT BY CAP
 - 118 SLIGHTLY THICKENED LINE INDICATES PERIMETER CONSTRUCTION NOT BY CAP
 - 119 SHIMS (SHIM AS NEEDED) NOT BY CAP
 - 120 ALUMINUM CLIP ANGLE (INTERMITTENT UNLESS NOTED OTHERWISE) FURNISHED ONLY BY CAP IN STOCK LENGTHS
 - 121 RIVET CONNECTION BETWEEN PANEL AND ALUMINUM ANGLE (RIVET BY CAP), ACTUAL CONNECTION NOT BY CAP
 - 122 CURTAINWALL FRAMING NOT BY CAP
 - 123 CAULK NOT BY CAP
 - 124 ROOF CONSTRUCTION NOT BY CAP
 - 139 DOOR AND/OR SIDELITE NOT BY CAP

